


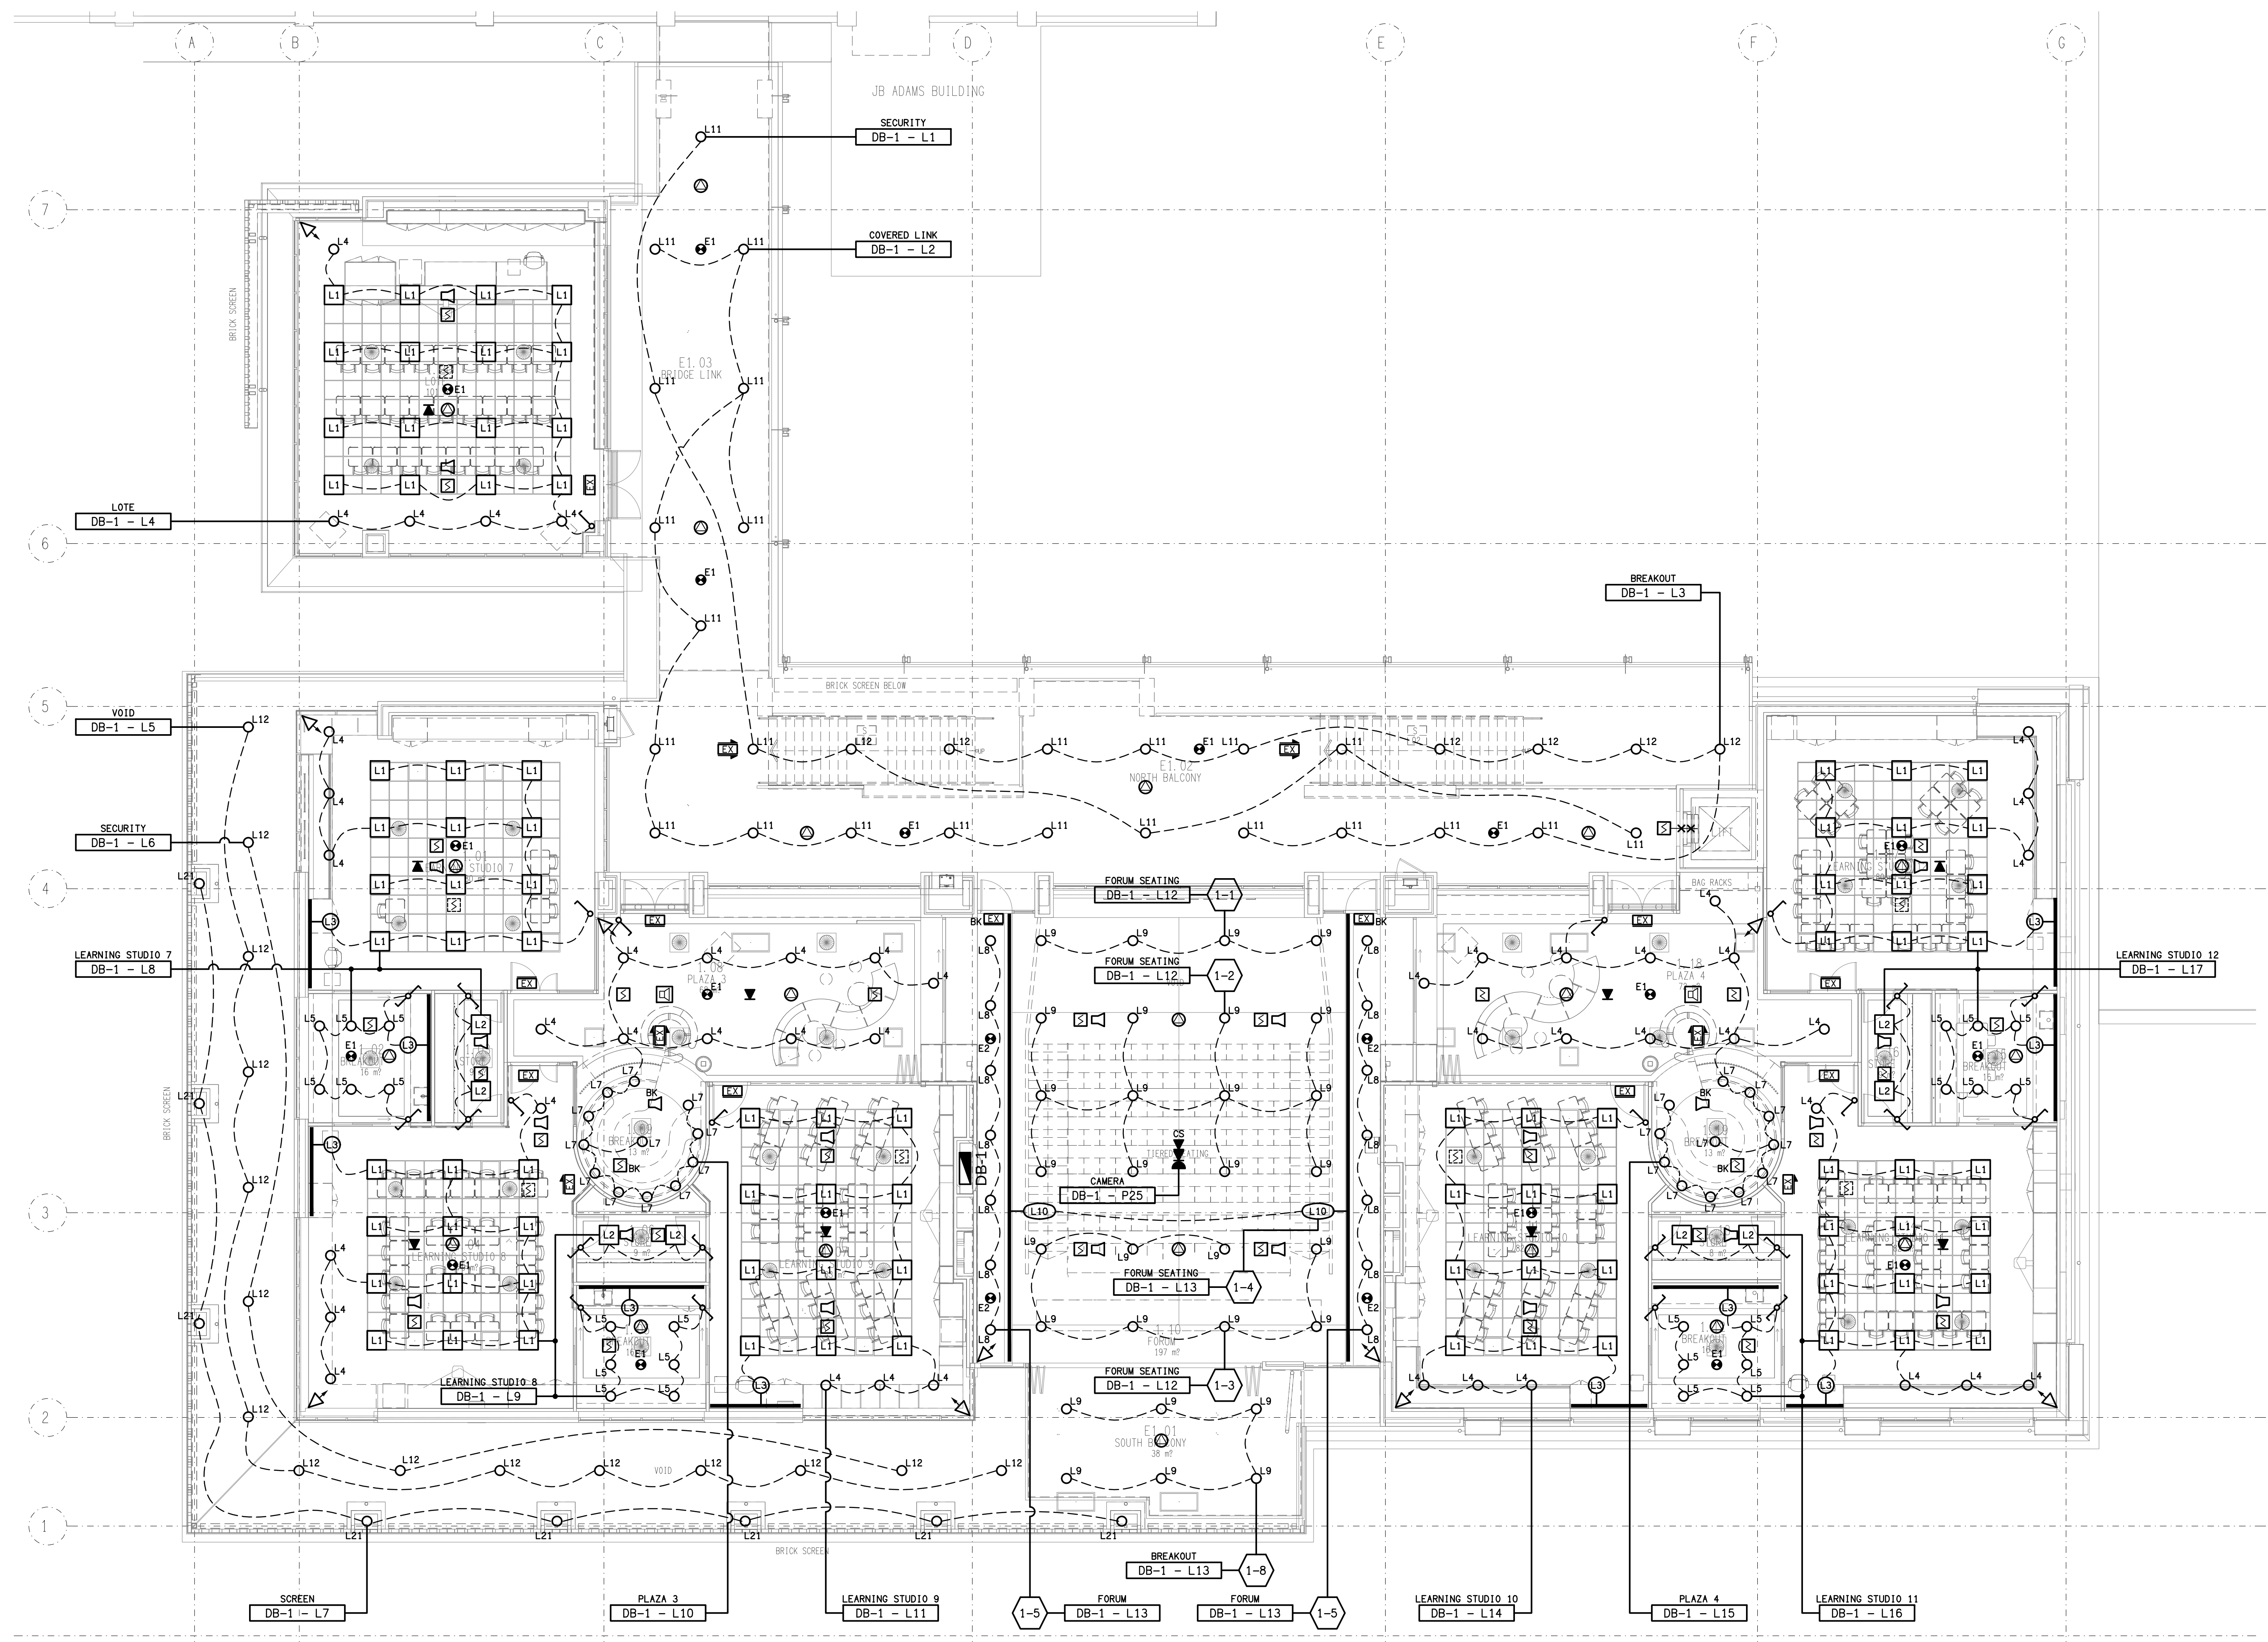

ELECTRICAL DESIGN GROUP BRISBANE
PTY LTD
ACN 092 710 793
TRADING AS:
ELECTRICAL DESIGN GROUP

THE COPYRIGHT OF THIS DRAWING
REMAINS THE PROPERTY OF THE
ELECTRICAL DESIGN GROUP.
USE FIGURED DIMENSIONS
IN PREFERENCE TO SCALE.
ALL DIMENSIONS TO BE
VERIFIED ON SITE.

ELECTRICAL DESIGN GROUP
ELECTRICAL BUILDING SERVICES CONSULTANTS
BRISBANE GOLD COAST

P.O. Box 15, Sherwood Q. 4075
Phone: (07) 3278 4375
Email: brisbane@edg.net.au
Web: www.edg.net.au

PROJECT:
ANGLICAN CHURCH GRAMMAR SCHOOL
YEAR 5 & 6 PRECINCT

OAKLANDS PARADE, EAST BRISBANE

T1	TENDER	11/09/2026
REV.	DESCRIPTION:	DATE:

DRAWING: ELECTRICAL SERVICES PRECINCT LEVEL 1 REFLECTED CEILING PLAN		PROJECT NO: C3733a	DRAWING NO: E11	REVISION: T1
SCALE: 1:100 UNO	AT A1			