


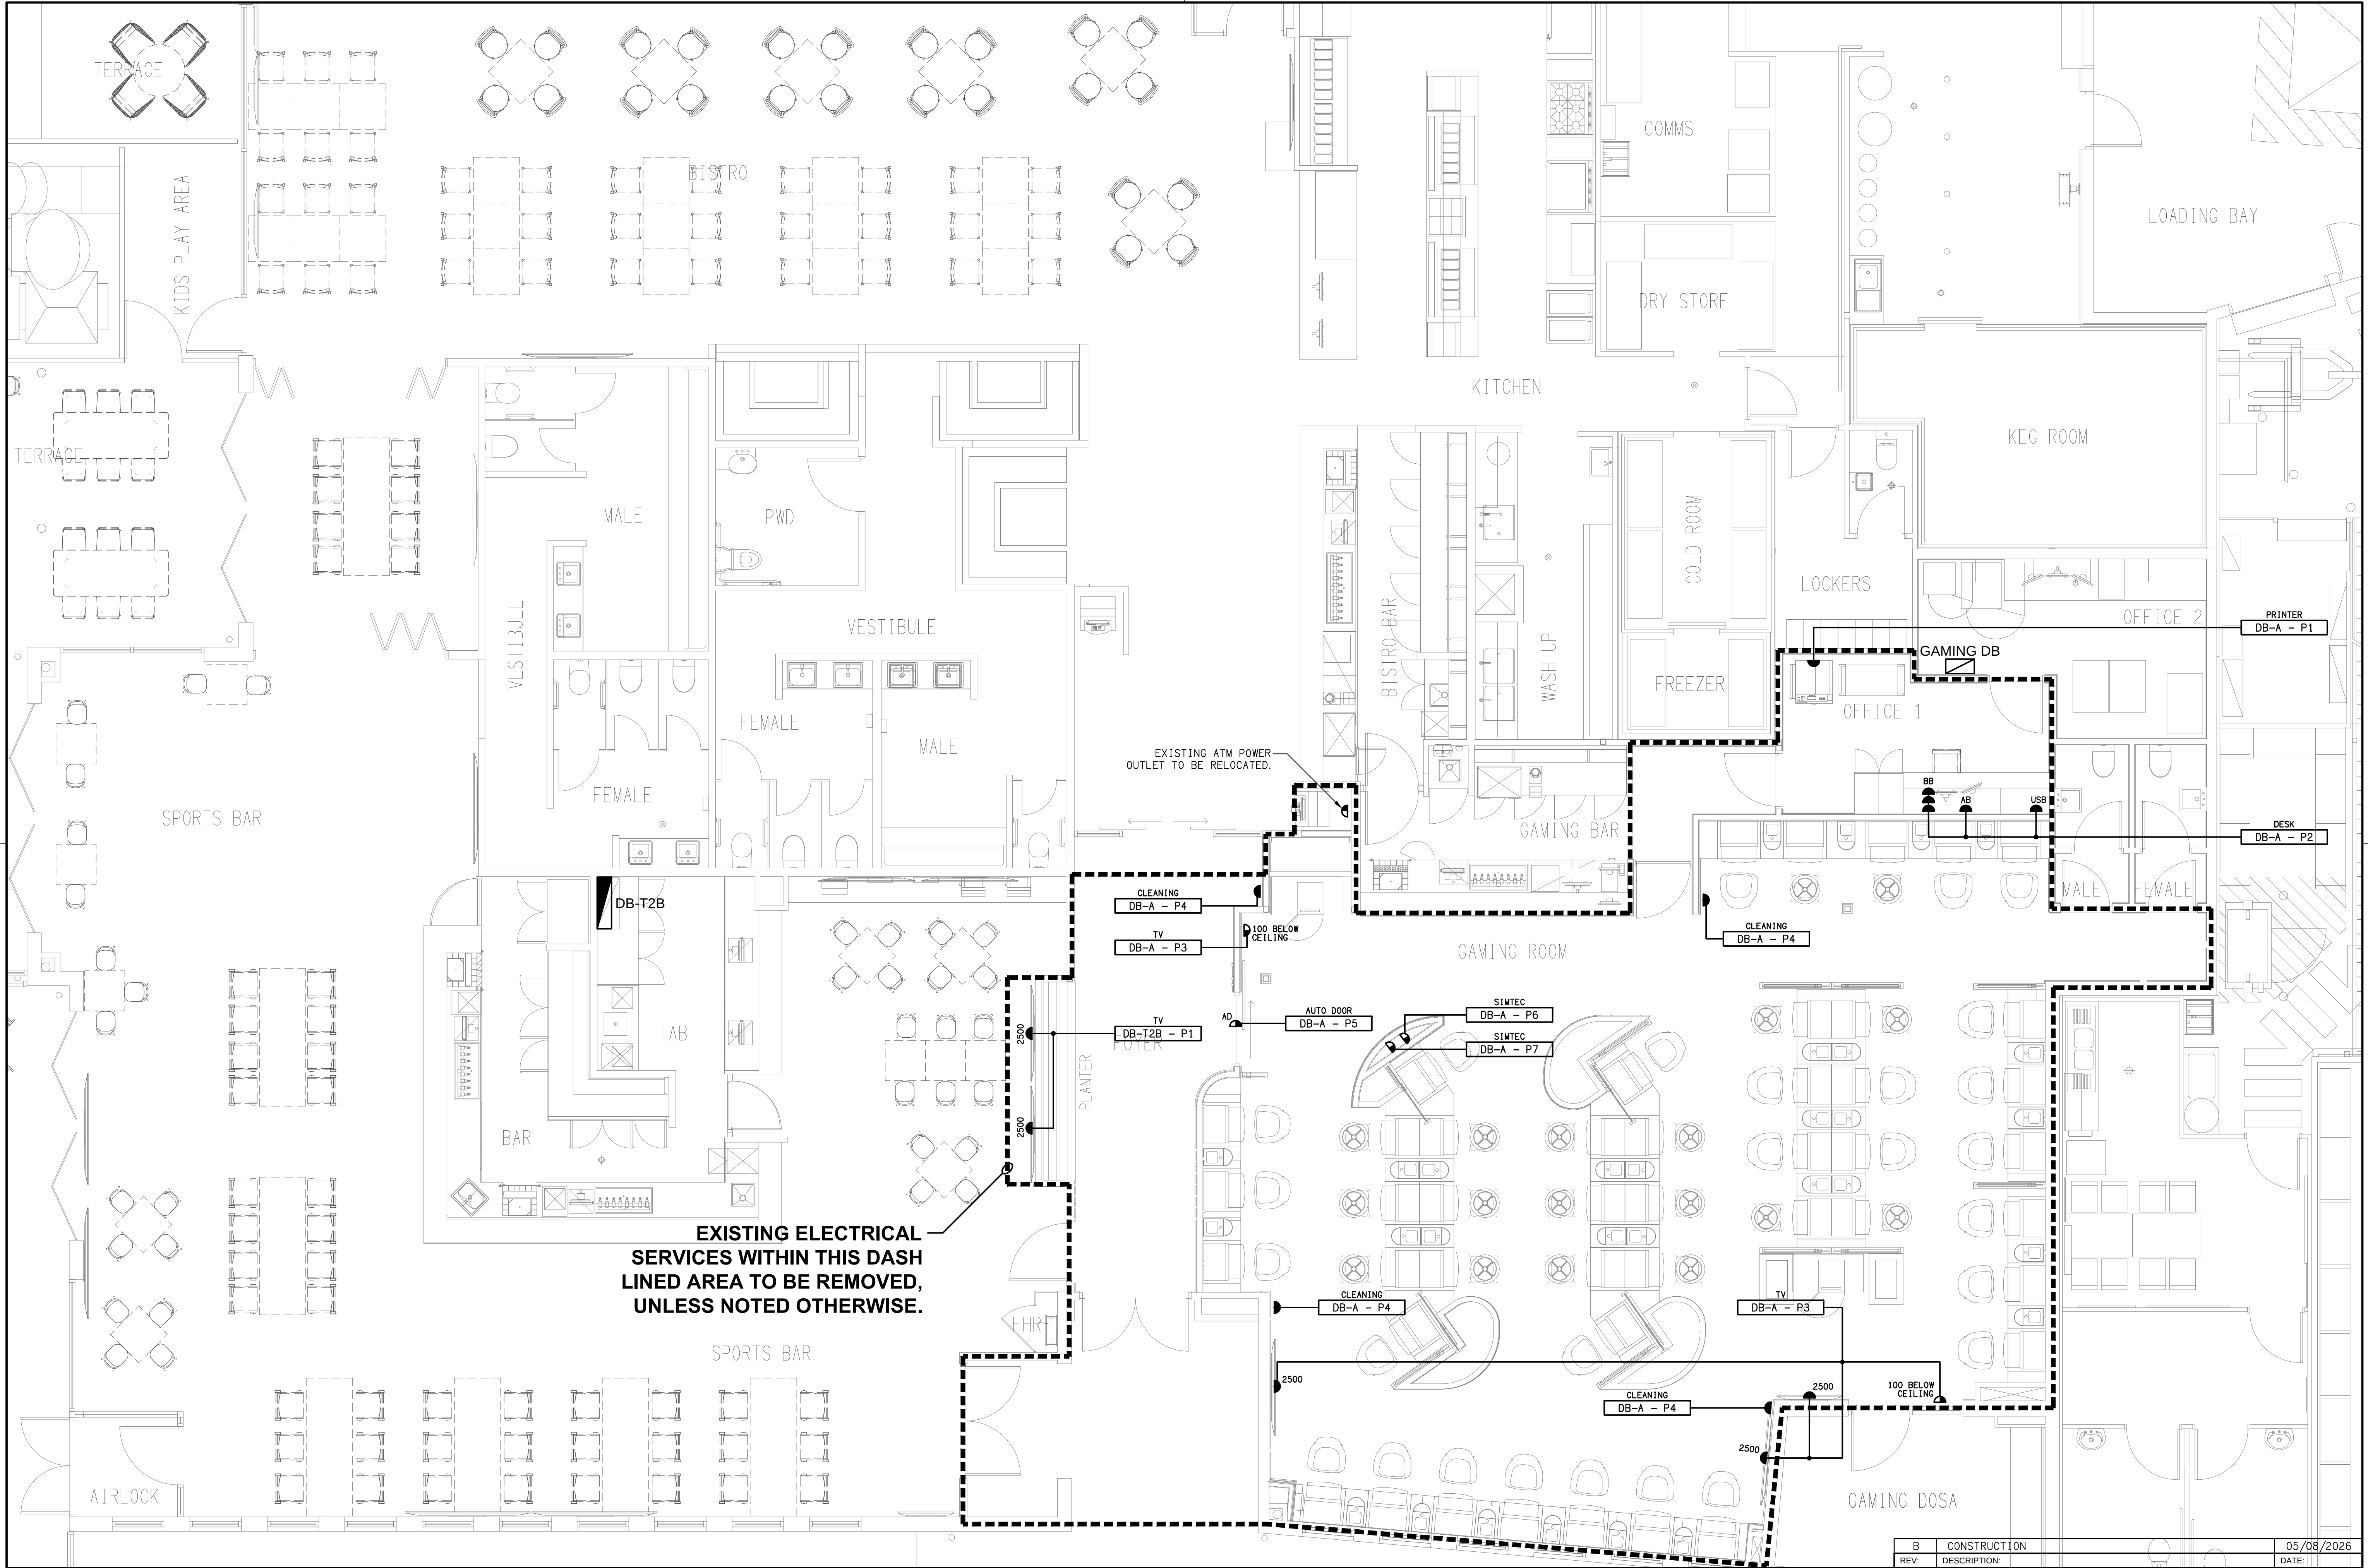

ELECTRICAL DESIGN GROUP BRISBANE PTY LTD ACN 092 710 793 TRADING AS: ELECTRICAL DESIGN GROUP	THE COPYRIGHT OF THIS DRAWING REMAINS THE PROPERTY OF THE ELECTRICAL DESIGN GROUP. USE FIGURED DIMENSIONS IN PREFERENCE TO SCALE. ALL DIMENSIONS TO BE VERIFIED ONSITE.	ELECTRICAL DESIGN GROUP ELECTRICAL BUILDING SERVICES CONSULTANTS BRISBANE GOLD COAST P.O.Box 15, Sherwood Q.4075 Phone: (07) 3278 4375 Email: brisbane@edg.net.au Web: www.edg.net.au	PROJECT: COOMERA TAVERN 2 CITY CENTRE DRIVE, UPPER COOMERA, QUEENSLAND	B CONSTRUCTION 05/08/2026 REV. DESCRIPTION: DATE:	
				DRAWING: ELECTRICAL SERVICES FLOOR PLAN	
				SCALE: 1:50 UNO AT A1	PROJECT NO: C3734a DRAWING NO: E03 REVISION: B