



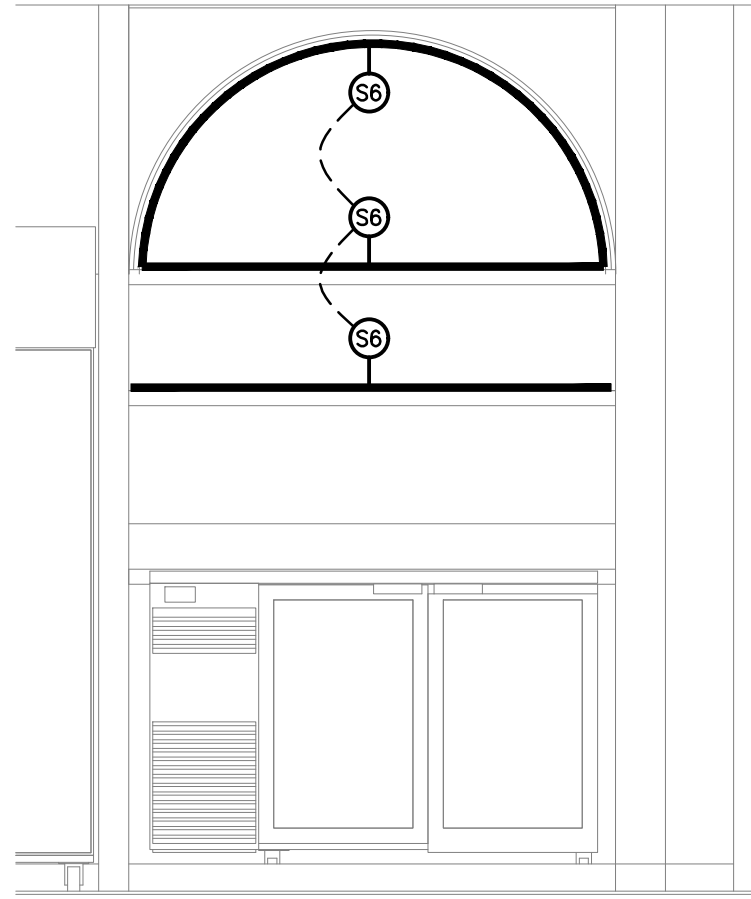


DETAIL A
CANTEEN BAR ELEVATION 1
SCALE 1:25

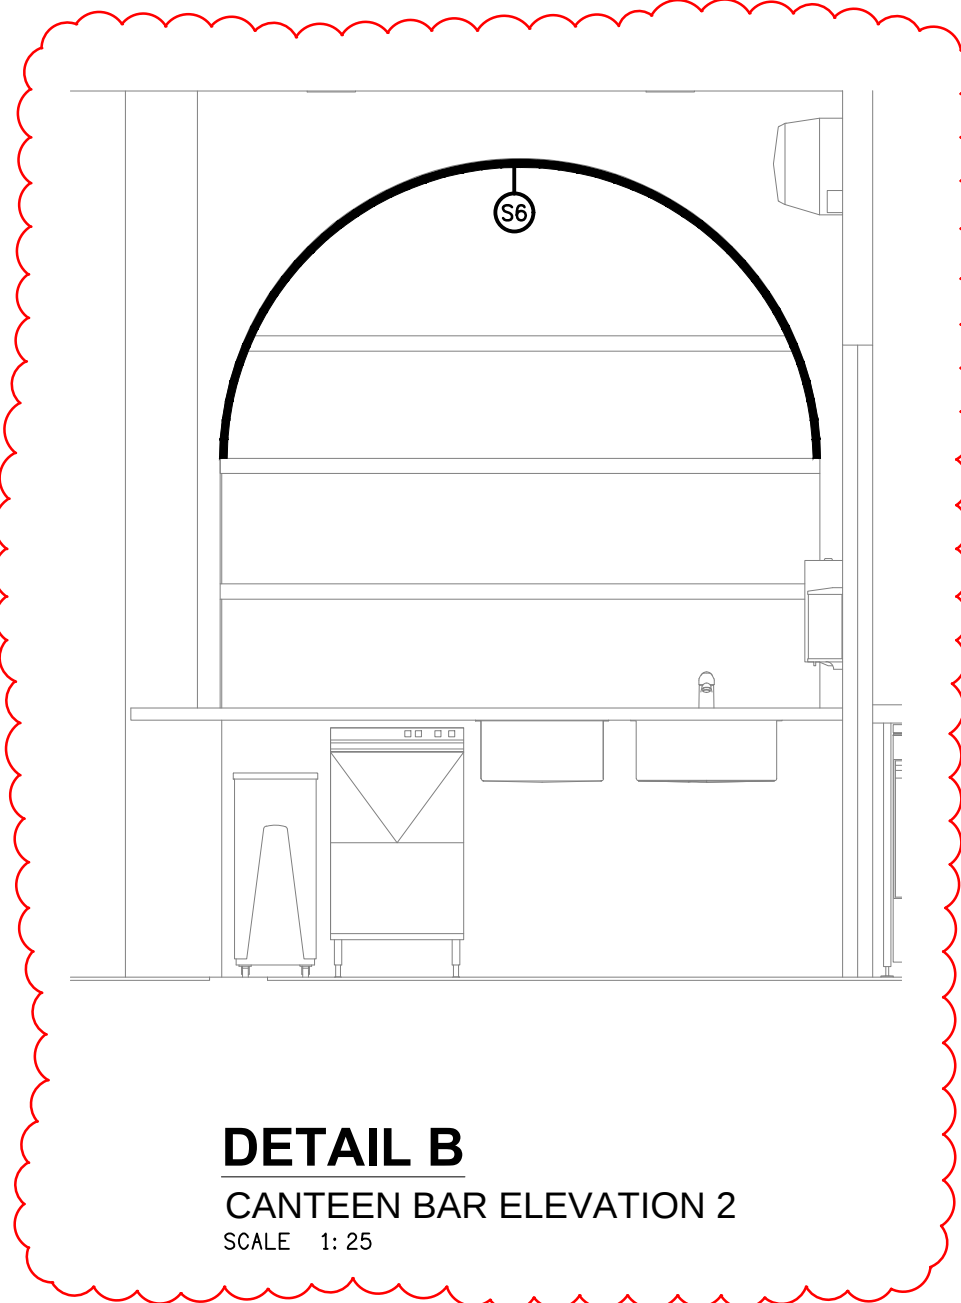


DETAIL B
CANTEEN BAR ELEVATION 2
SCALE 1:25

REMOVE ALL OF THE EXISTING
LIGHTING SERVICES AND CONTROLS
WITHIN THIS DASH LINED AREA,
UNLESS NOTED OTHERWISE.

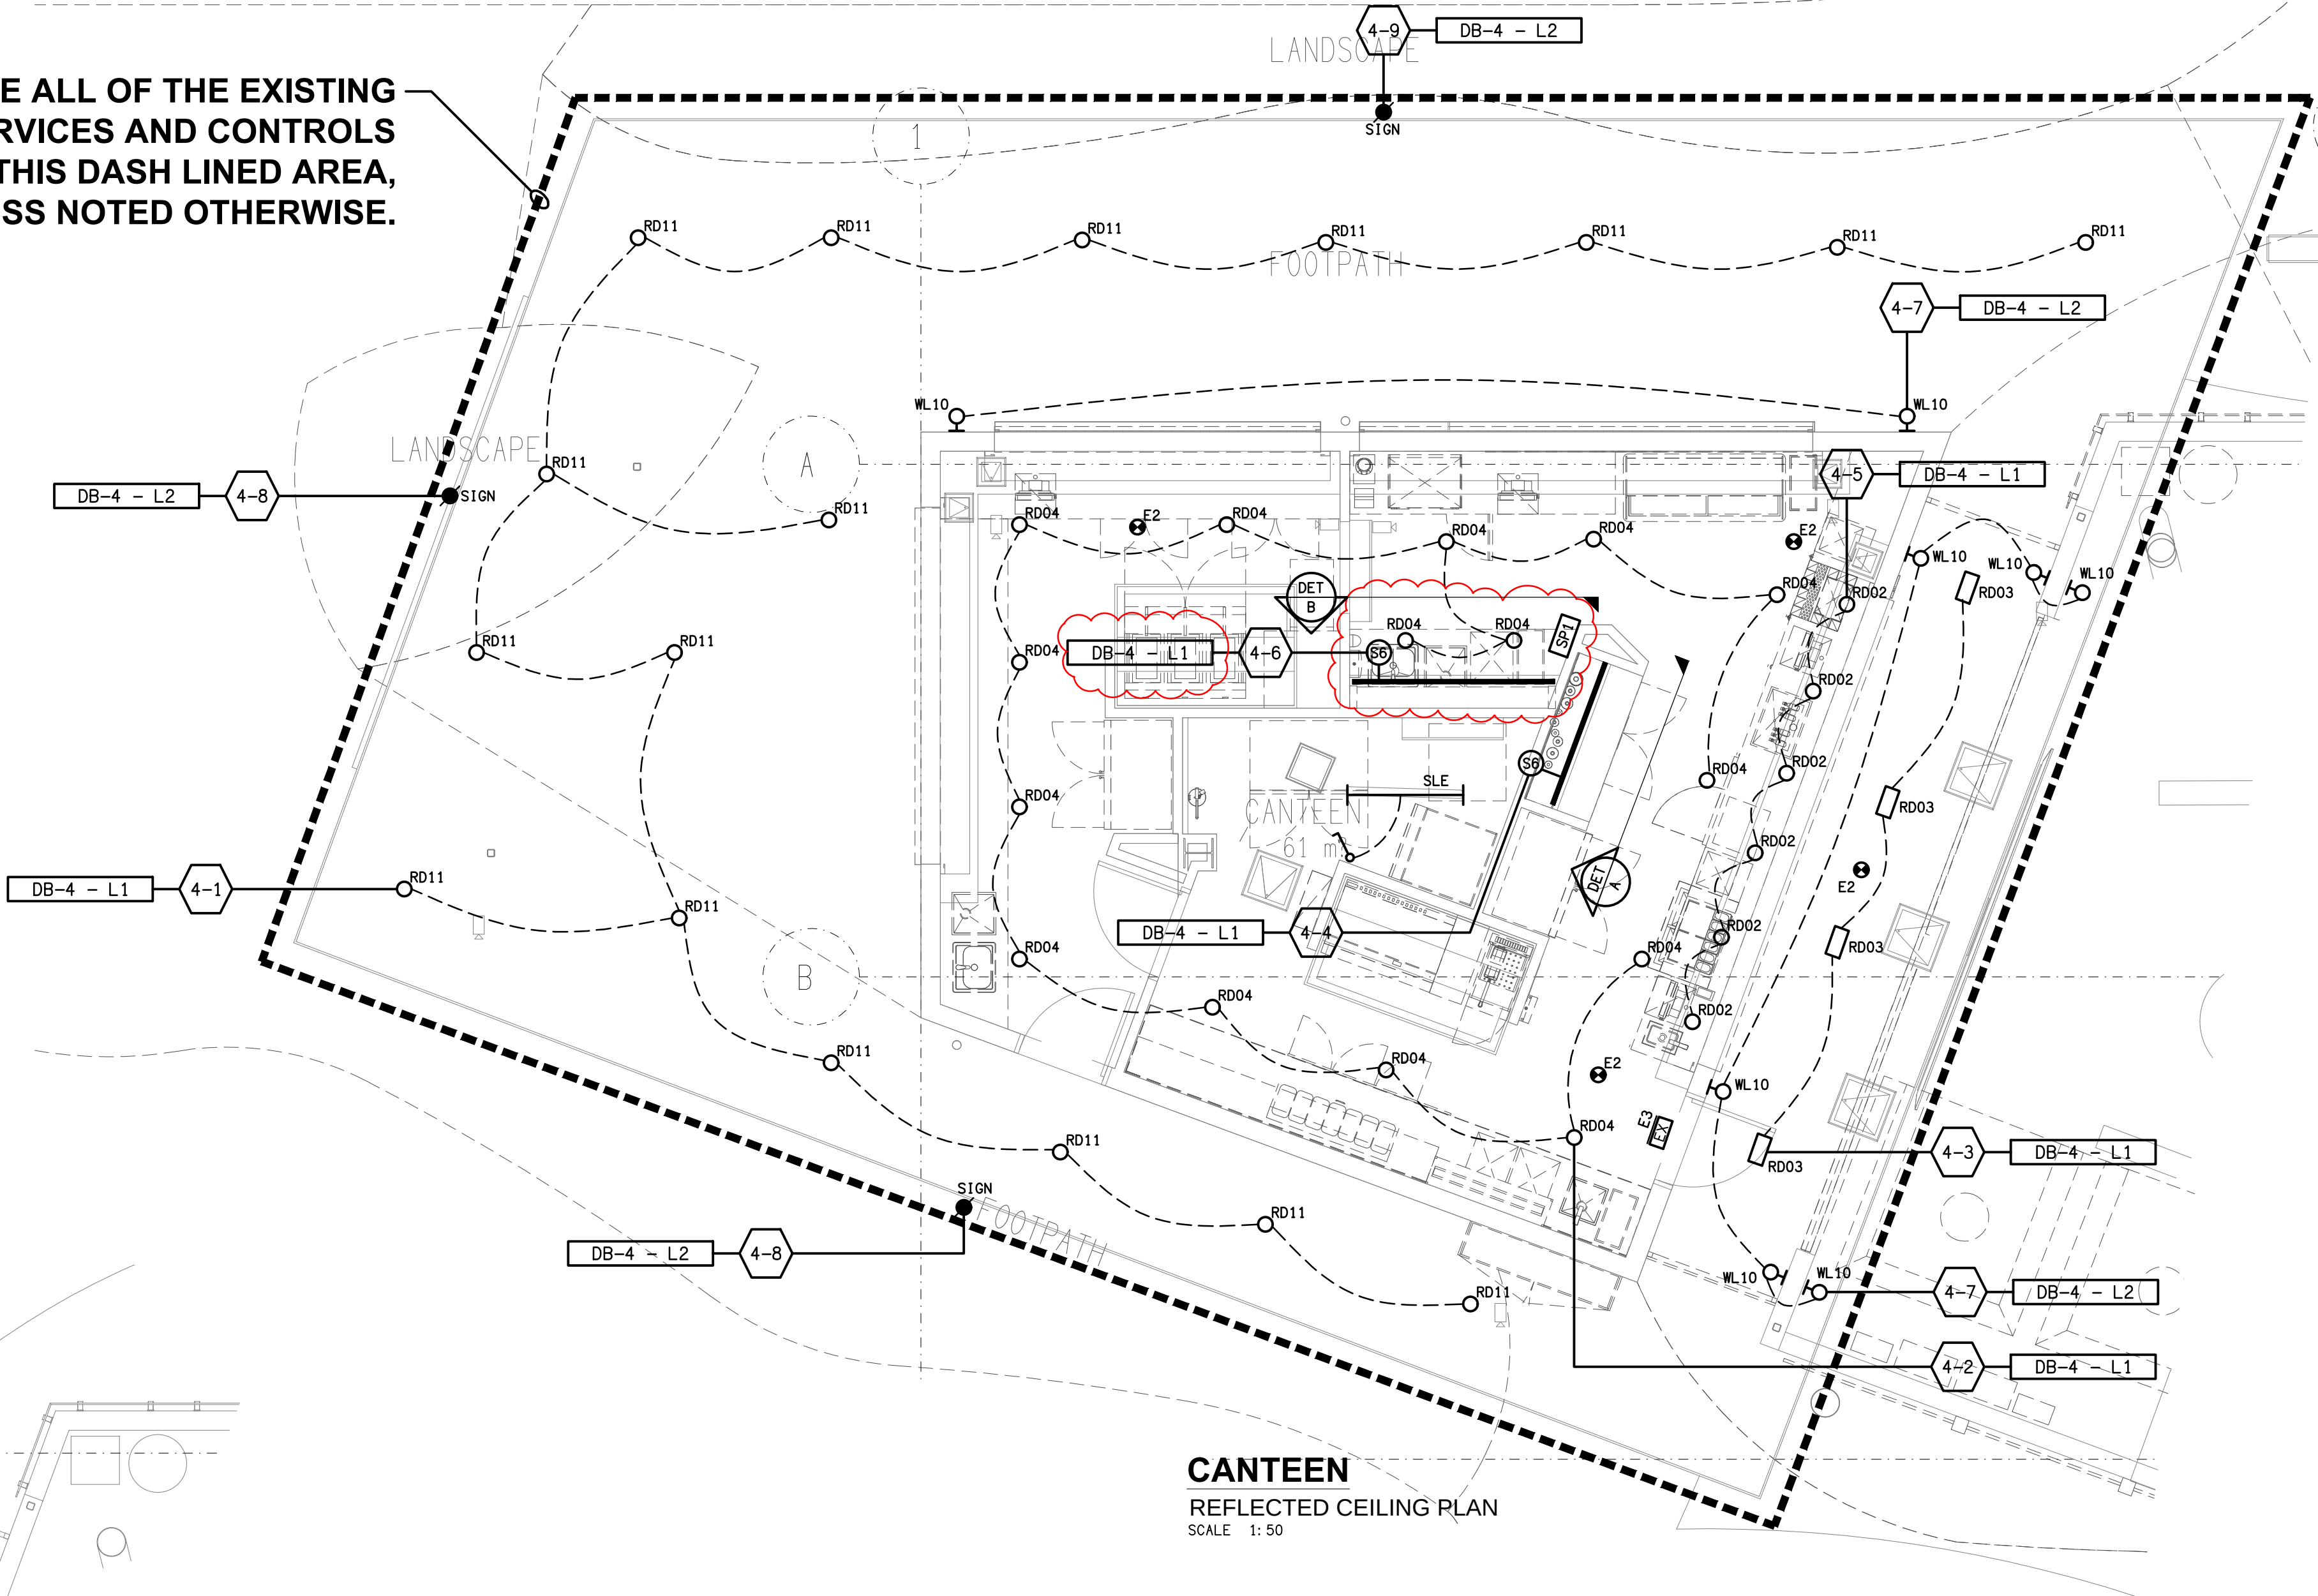

CANTEEN
REFLECTED CEILING PLAN
SCALE 1:50

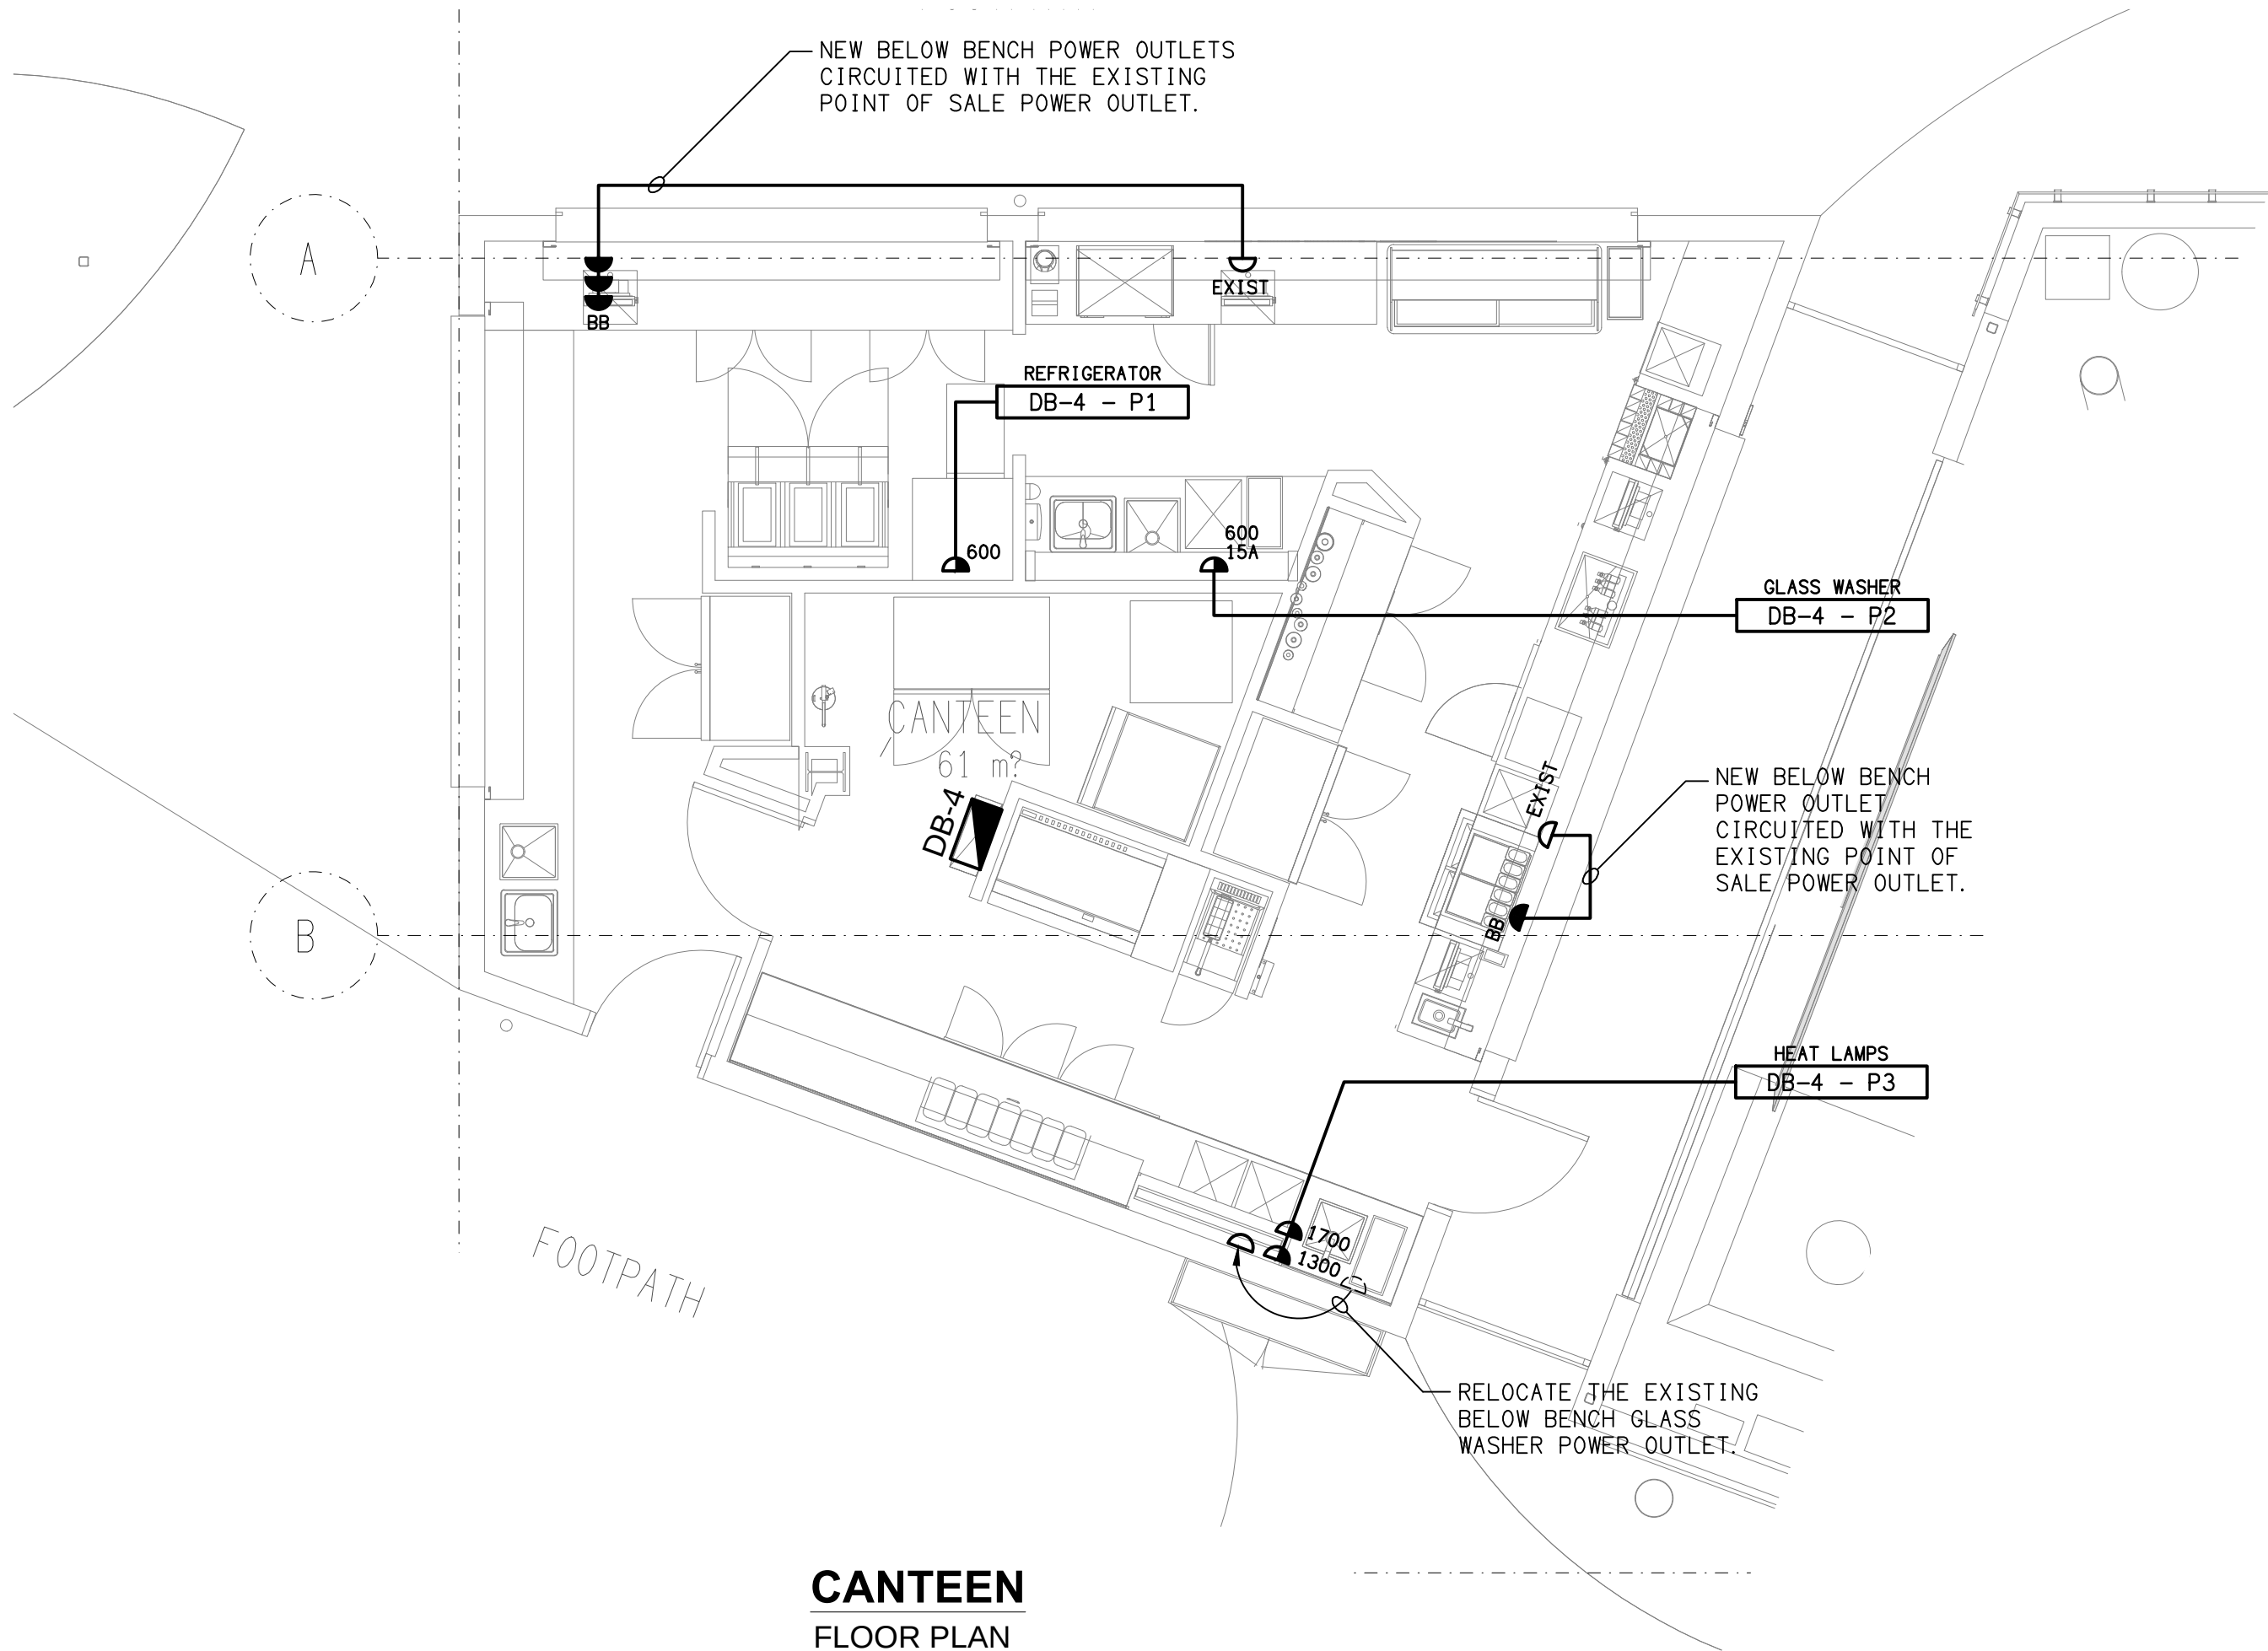

CANTEEN
FLOOR PLAN
SCALE 1:50

ELECTRICAL DESIGN GROUP BRISBANE
PTY LTD
ACN 092 710 793
TRADING AS:
ELECTRICAL DESIGN GROUP

THE COPYRIGHT OF THIS DRAWING
REMAINS THE PROPERTY OF THE
ELECTRICAL DESIGN GROUP.
USE FIGURED DIMENSIONS
IN PREFERENCE TO SCALE.
ALL DIMENSIONS TO BE
VERIFIED ONSITE.

ELECTRICAL DESIGN GROUP
ELECTRICAL BUILDING SERVICES CONSULTANTS
BRISBANE GOLD COAST

P.O.Box 15, Sherwood Q.4075
Phone: (07) 3278 4375
Email: brisbane@edg.net.au
Web: www.edg.net.au

PROJECT:
COOLUM BEACH HOTEL

CORNER BIRTWILL STREET & DAVID LOW WAY, COOLUM BEACH

D	CONSTRUCTION	15/07/2026
REV.	DESCRIPTION:	DATE:

DRAWING:
**ELECTRICAL SERVICES
CANTEEN PLANS**

SCALE: 1:50 UNO	AT A1	PROJECT NO: C3743a	DRAWING NO: E06	REVISION: D
--------------------	-------	------------------------------	---------------------------	-----------------------