



**DETAIL A**  
CANTEEN BAR ELEVATION  
SCALE 1: 25

REMOVE ALL OF THE EXISTING  
LIGHTING SERVICES AND CONTROLS  
WITHIN THIS DASH LINED AREA,  
UNLESS NOTED OTHERWISE.

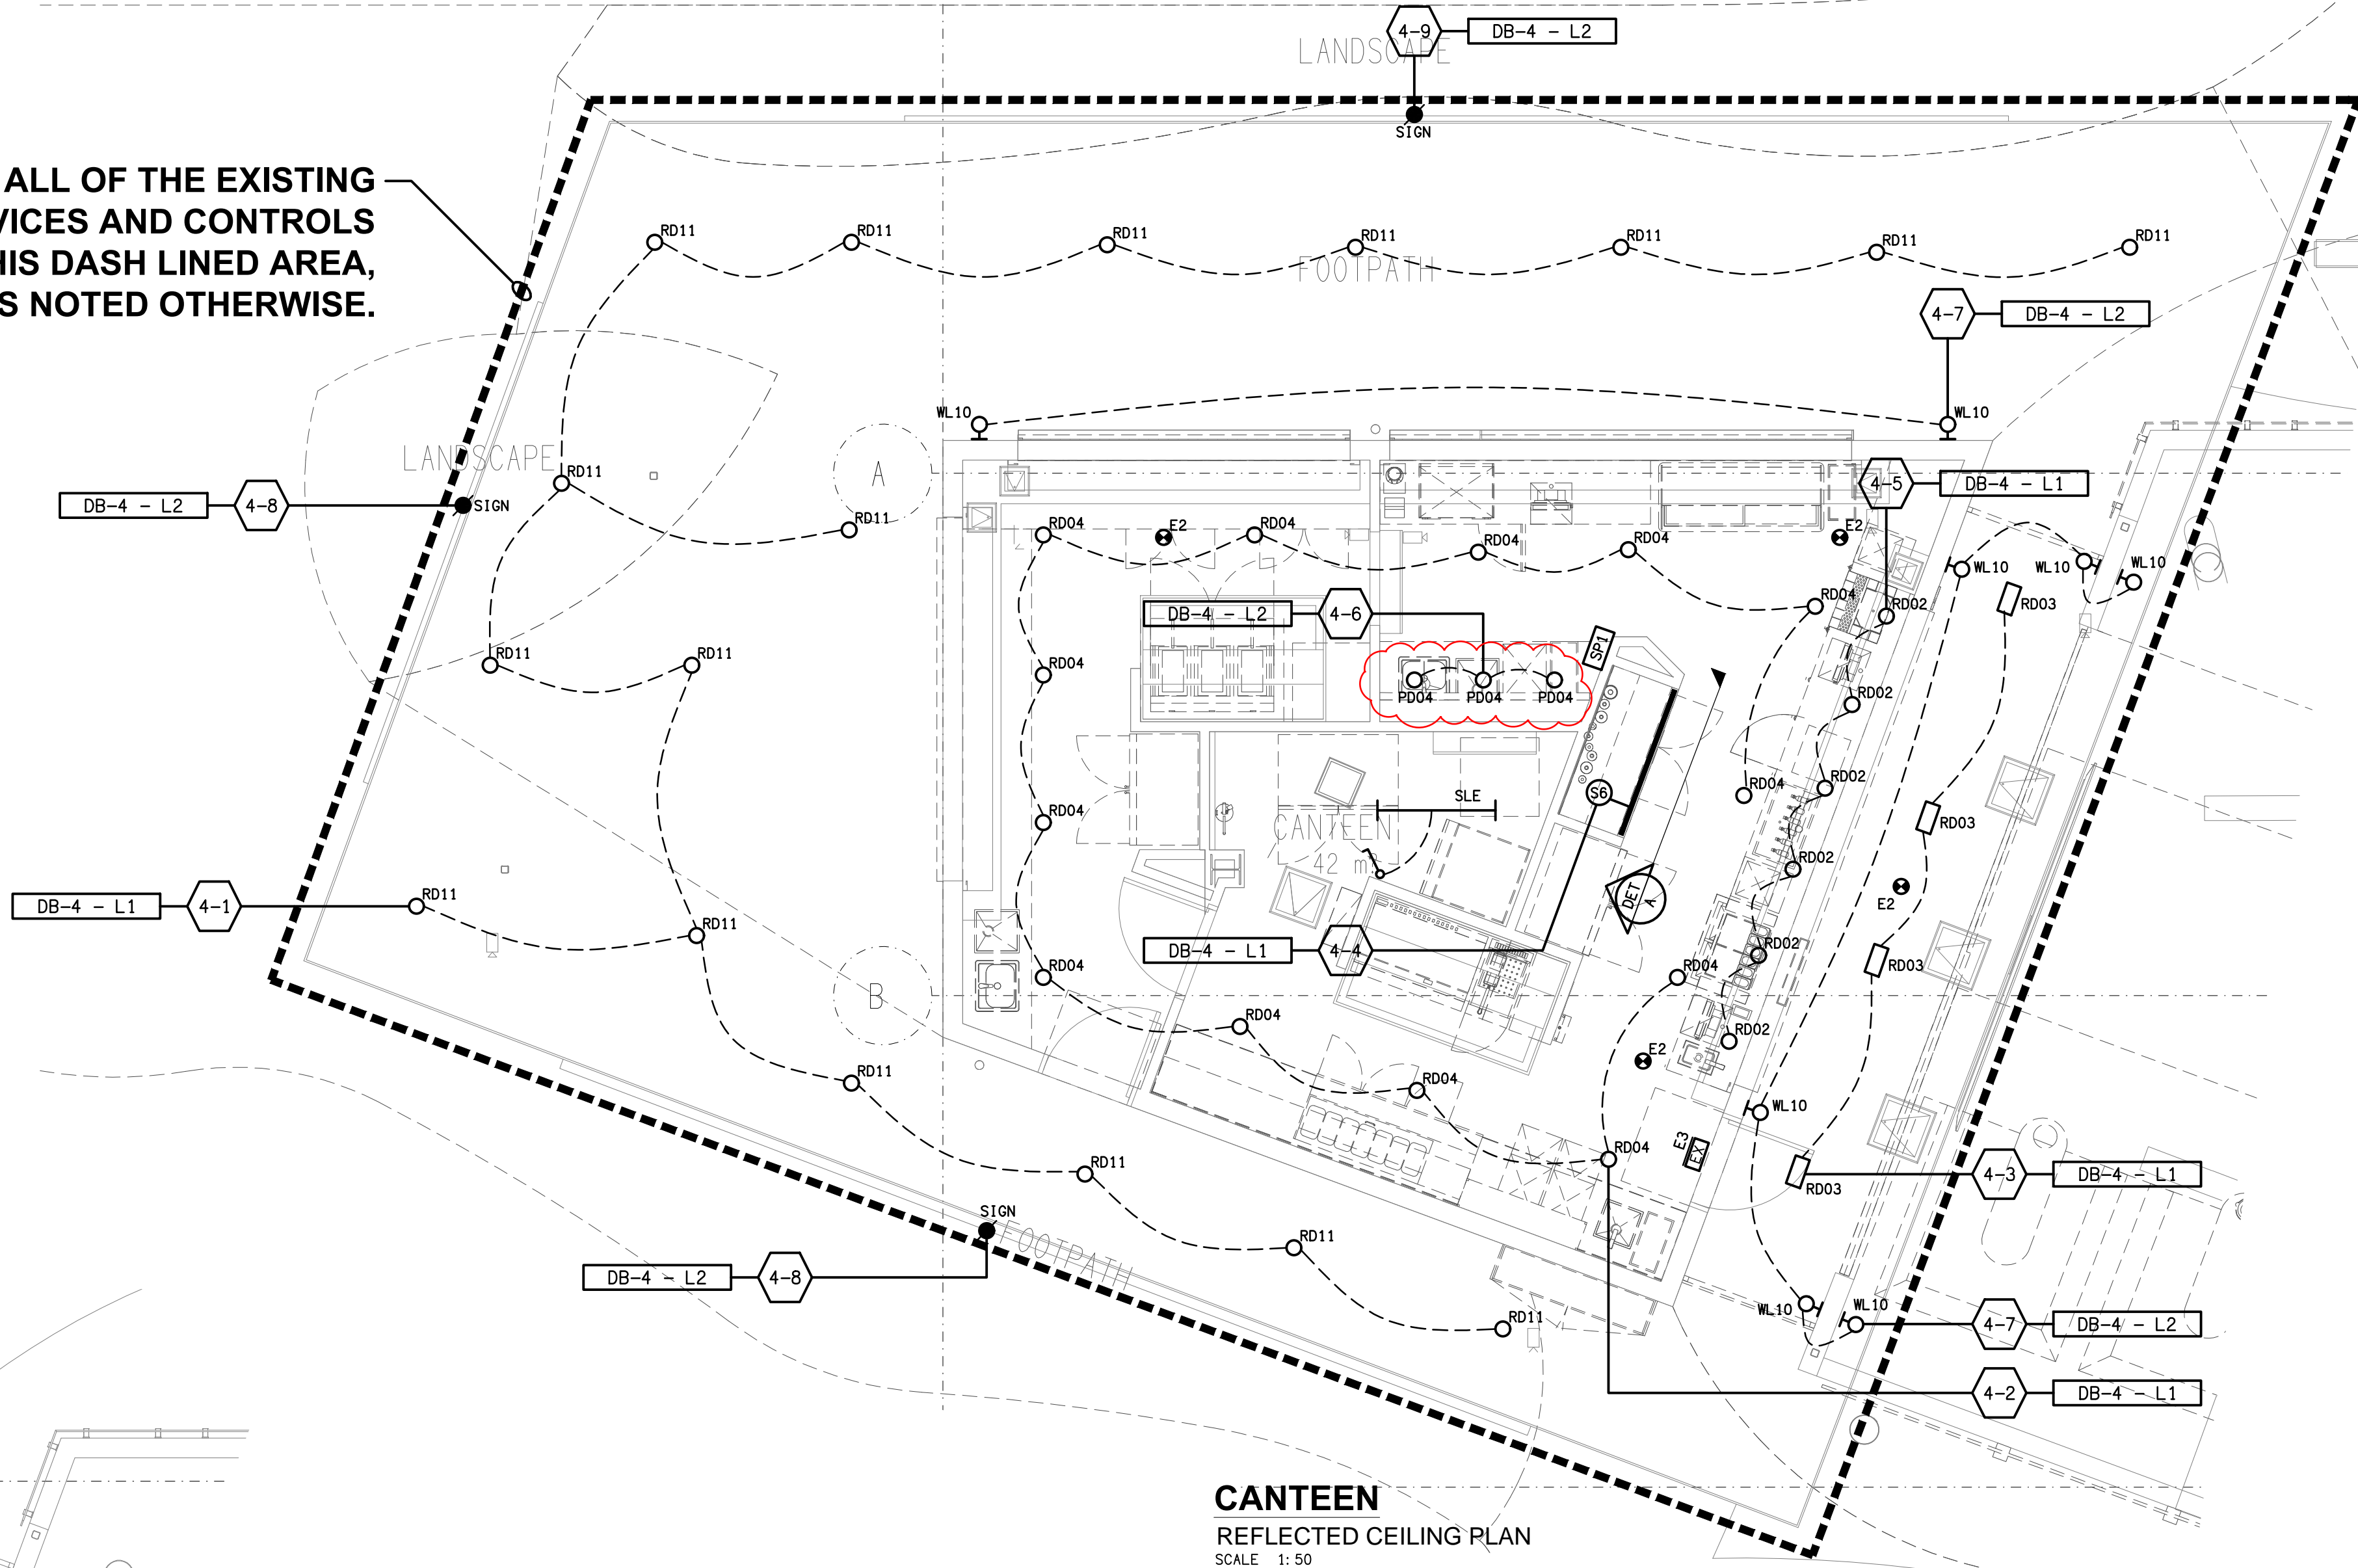

**CANTEEN**  
REFLECTED CEILING PLAN  
SCALE 1: 50

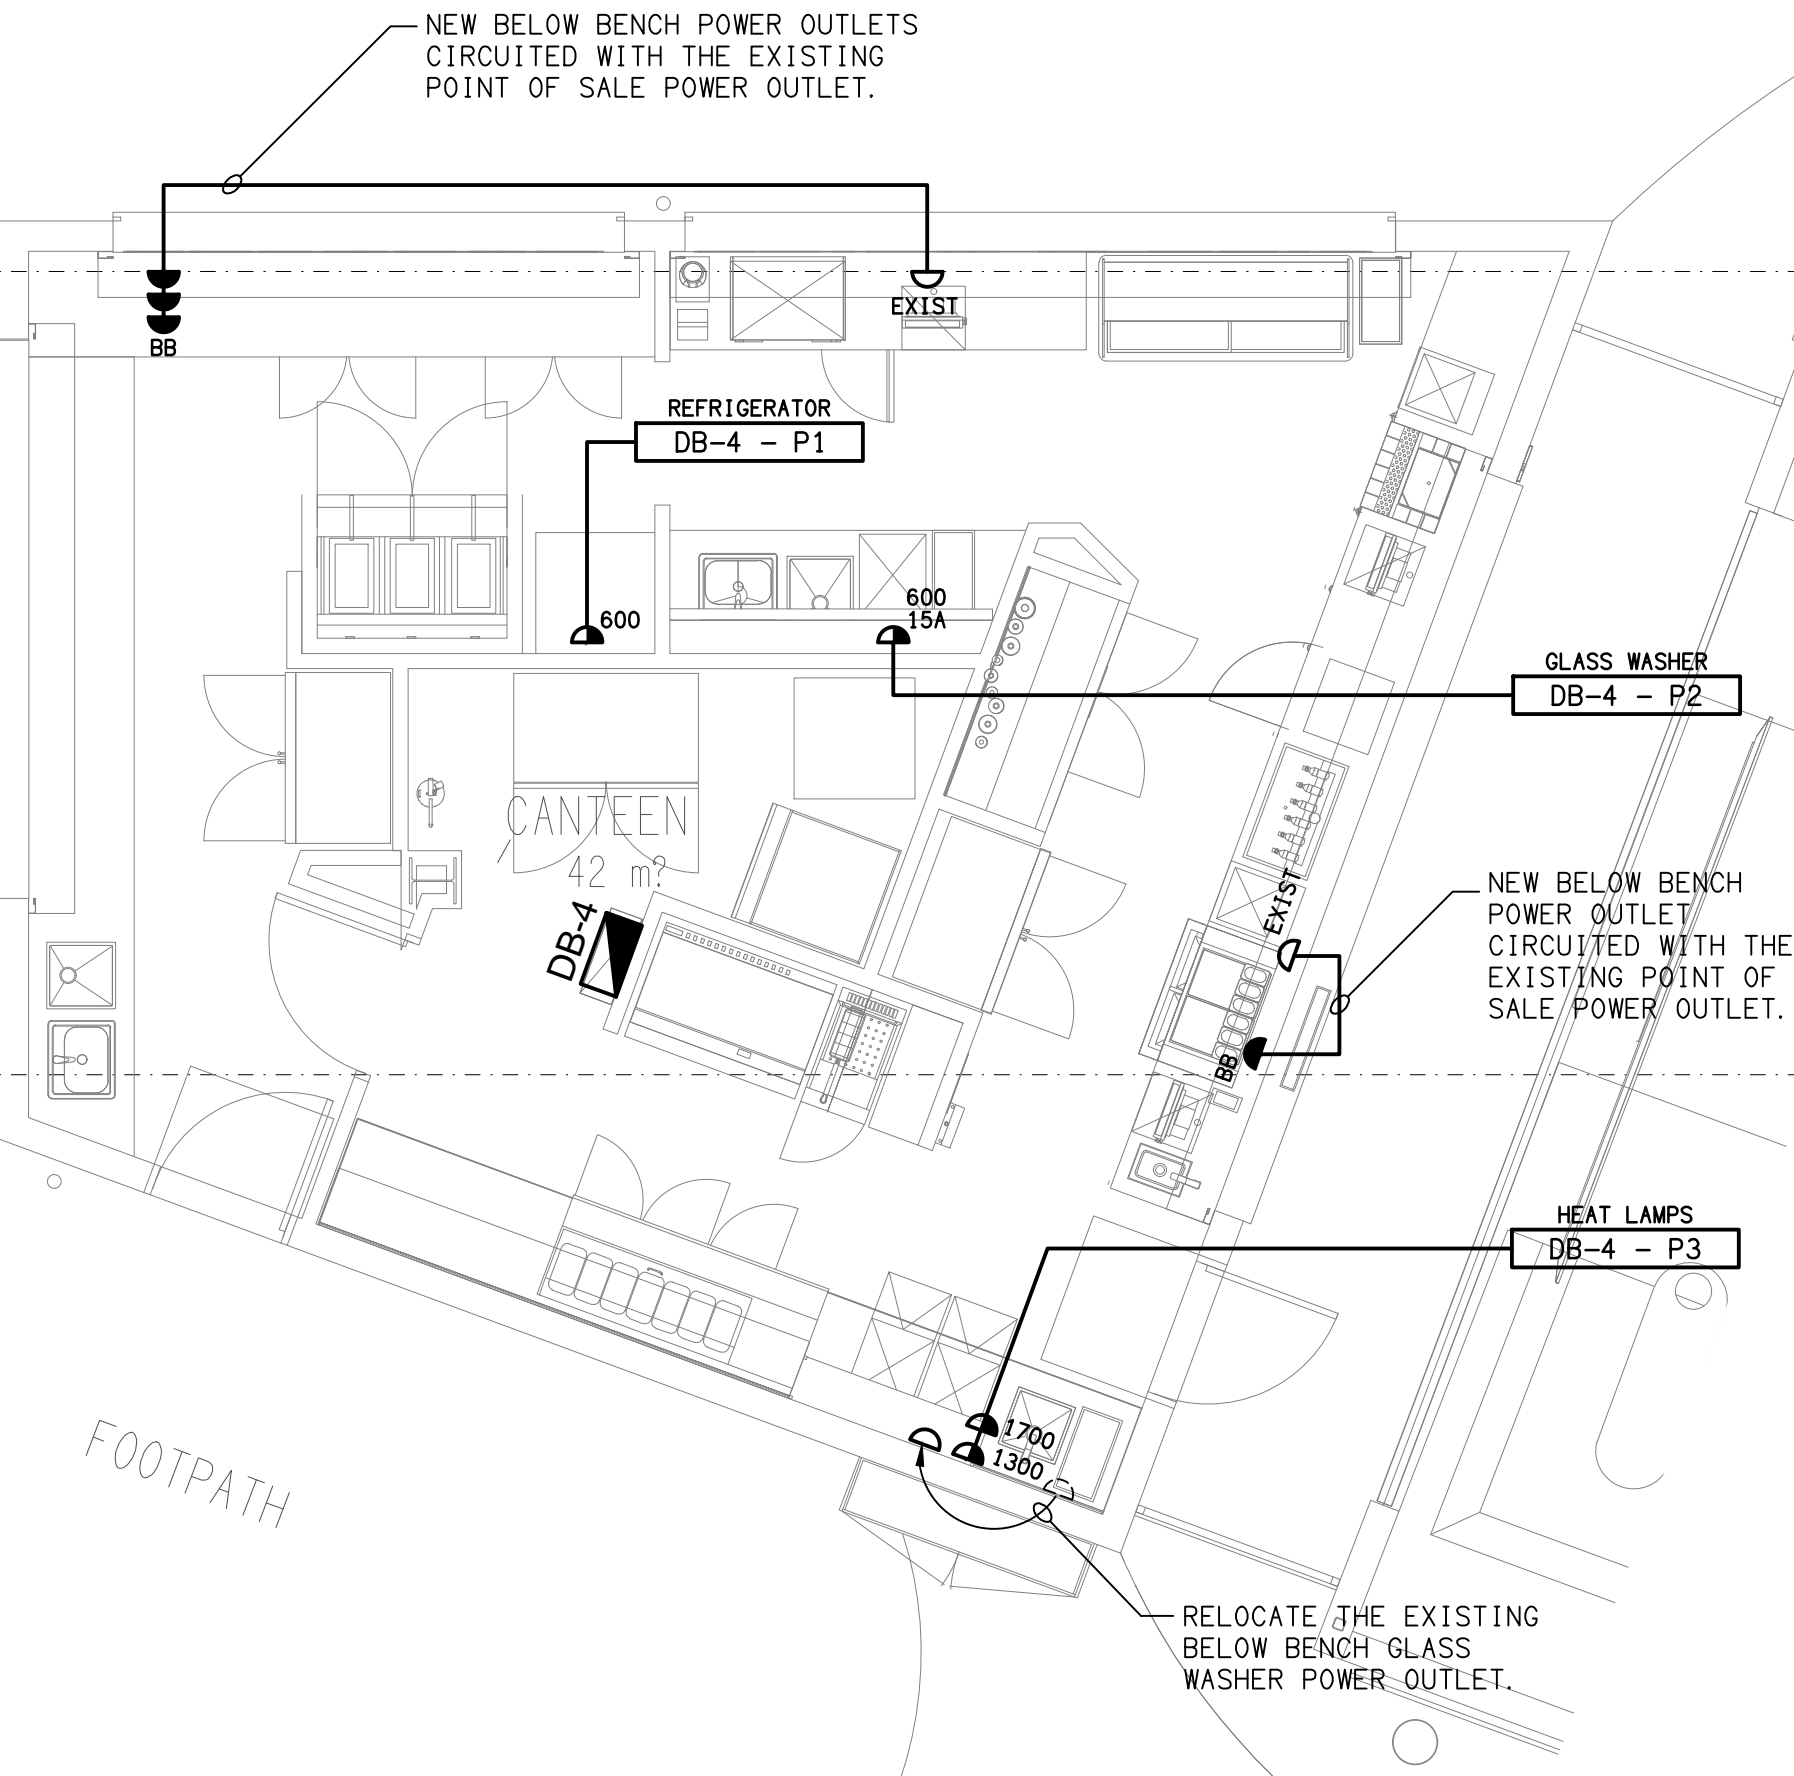

**CANTEEN**  
FLOOR PLAN  
SCALE 1: 50

ELECTRICAL DESIGN GROUP BRISBANE  
PTY LTD  
ACN 092 710 793  
TRADING AS:  
ELECTRICAL DESIGN GROUP

THE COPYRIGHT OF THIS DRAWING  
REMAINS THE PROPERTY OF THE  
ELECTRICAL DESIGN GROUP.  
USE FIGURED DIMENSIONS  
IN PREFERENCE TO SCALE.  
ALL DIMENSIONS TO BE  
VERIFIED ONSITE.

**ELECTRICAL DESIGN GROUP**  
ELECTRICAL BUILDING SERVICES CONSULTANTS  
BRISBANE GOLD COAST

P.O.Box 15, Sherwood Q.4075  
Phone: (07) 3278 4375  
Email: brisbane@edg.net.au  
Web: www.edg.net.au

PROJECT:  
**COOLUM BEACH HOTEL**  
  
CORNER BIRTWILL STREET & DAVID LOW WAY, COOLUM BEACH

C	TENDER	27/05/2026
REV.	DESCRIPTION:	DATE:

DRAWING:  
**ELECTRICAL SERVICES  
CANTEEN PLANS**

SCALE: 1:50 UNO	AT A1	PROJECT NO: <b>C3743a</b>	DRAWING NO: <b>E06</b>	REVISION: <b>C</b>
--------------------	-------	------------------------------	---------------------------	-----------------------