


LEGEND


-  ELECTRICAL SERVICES SWITCHBOARD.
-  SWITCHBOARD / CONTROL PANEL NOT PROVIDED AS PART OF THE ELECTRICAL SUBCONTRACT.
-  SINGLE POWER OUTLET.
-  DOUBLE POWER OUTLET.
-  SIGNAGE CONNECTION.
-  SINGLE PHASE ISOLATOR.
-  THREE PHASE ISOLATOR.
-  CONDUIT ROUTE.
-  LIGHTING CONTROL SWITCHPANEL, TYPE x.
-  ONE WAY LIGHT SWITCH.
-  CIRCUIT LINE.
-  SWITCH LINE.
-  POWER CIRCUIT DESIGNATION. DENOTES DB AND CIRCUIT.
-  LIGHTING CONTROL CHANNEL REFERENCE.
-  ELECTRICAL EQUIPMENT AS NOTED.
-  REFER TO DETAIL NOTED FOR THE AREA SHOWN HATCHED. ADDITIONAL OUTLETS & FITTINGS MAY BE SHOWN ON DETAIL.
-  Sx: LED JOINERY / CEILING STRIP LIGHT, TYPE AS NOTED.
-  Px: DECORATIVE PENDANT, TYPE AS NOTED.
-  E1: GENERAL CEILING RECESSED LED EMERGENCY LIGHT, BLACK.
-  E2: GENERAL CEILING RECESSED LED EMERGENCY LIGHT, WHITE.
-  EX: EMERGENCY LED EXIT LIGHT, WHITE.
-  EX BK: EMERGENCY LED EXIT LIGHT, BLACK.
-  L1: BISTRO BAR BULKHEAD LED STRIP LIGHT.
-  L2: GAMING BAR BULKHEAD LED STRIP LIGHT.
-  L3: GAMING CURTAIN PELMET LED STRIP LIGHT.
-  L4: GAMING CEILING FEATURE LED STRIP LIGHT.
-  L5: SPORTS BAR JOINERY LED STRIP LIGHT.
-  L6: RECESSED DOWNLIGHT, WHITE.
-  L7: RECESSED DOWNLIGHT, BLACK.
-  L8: RECESSED DOWNLIGHT, WHITE.
-  L9: RECESSED DOWNLIGHT, BLACK.
-  L10: 1200 x 300 RECESSED FLAT PLATE, WHITE TRIM.
-  WL01: DECORATIVE WALL LIGHT.
-  WL02: EXISTING WALL LIGHT REPLACED WITH NEW.
-  WL03: DECORATIVE WALL LIGHT.
-  WL04: DECORATIVE WALL LIGHT.
-  WL05: EXISTING HIGH LEVEL WALL LIGHT REPLACED WITH NEW.
-  HE1: EXISTING HEATER AND CONTROLS TO BE RETAINED.

LEGEND

-  P1: DECORATIVE PENDANT.
-  P2: DECORATIVE PENDANT.
-  P3: DECORATIVE PENDANT.
-  P4: DECORATIVE PENDANT.
-  P5: CLUSTER OF FOUR DECORATIVE PENDANTS.

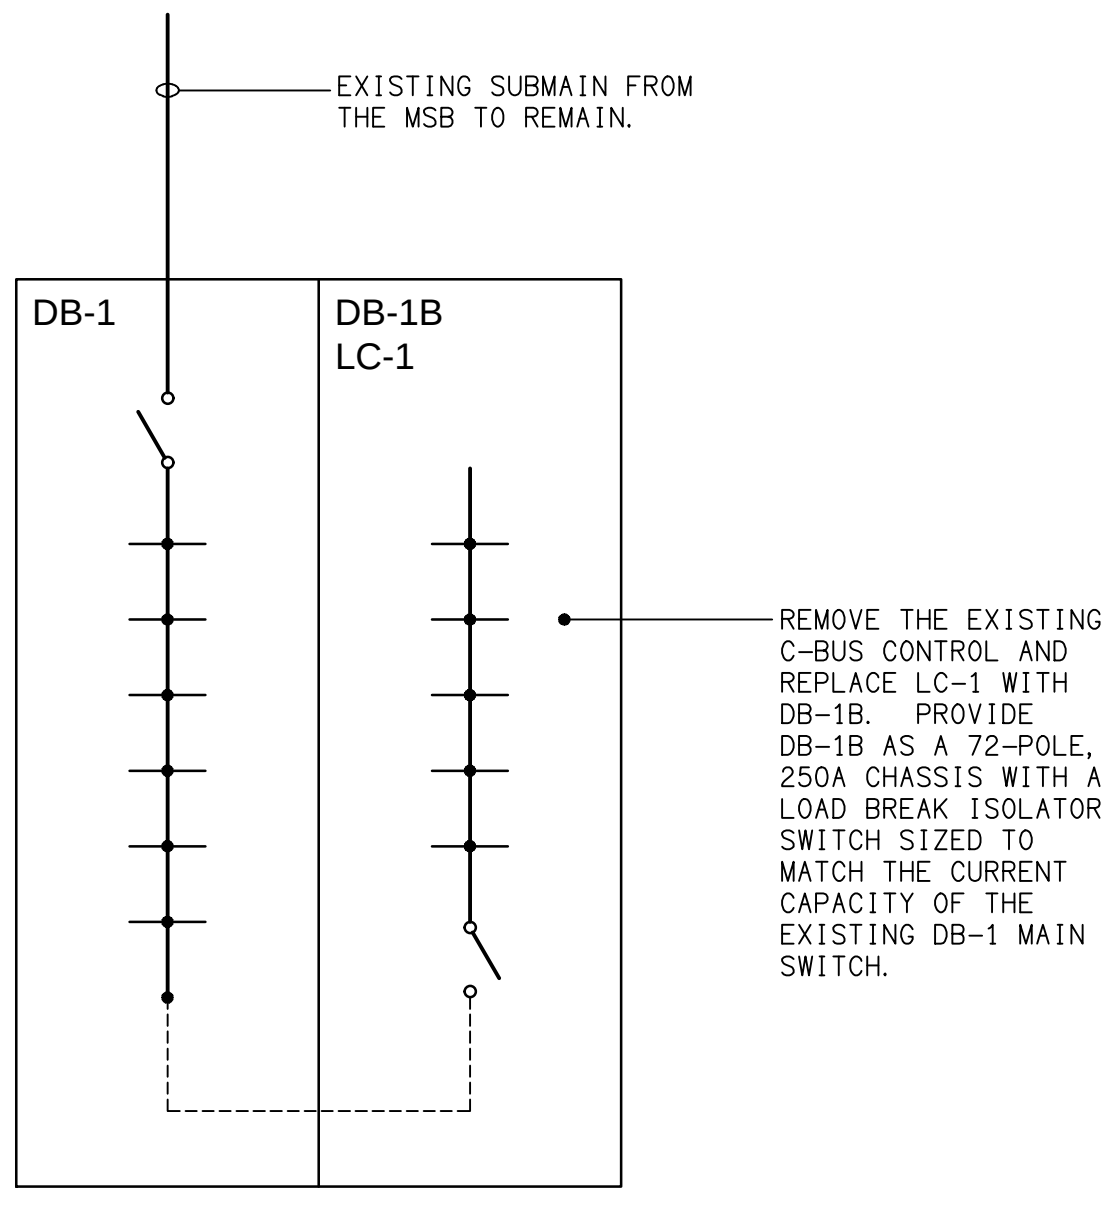


DETAIL
DB-1 / LC-1 / DB-1B ELEVATION
NOT TO SCALE

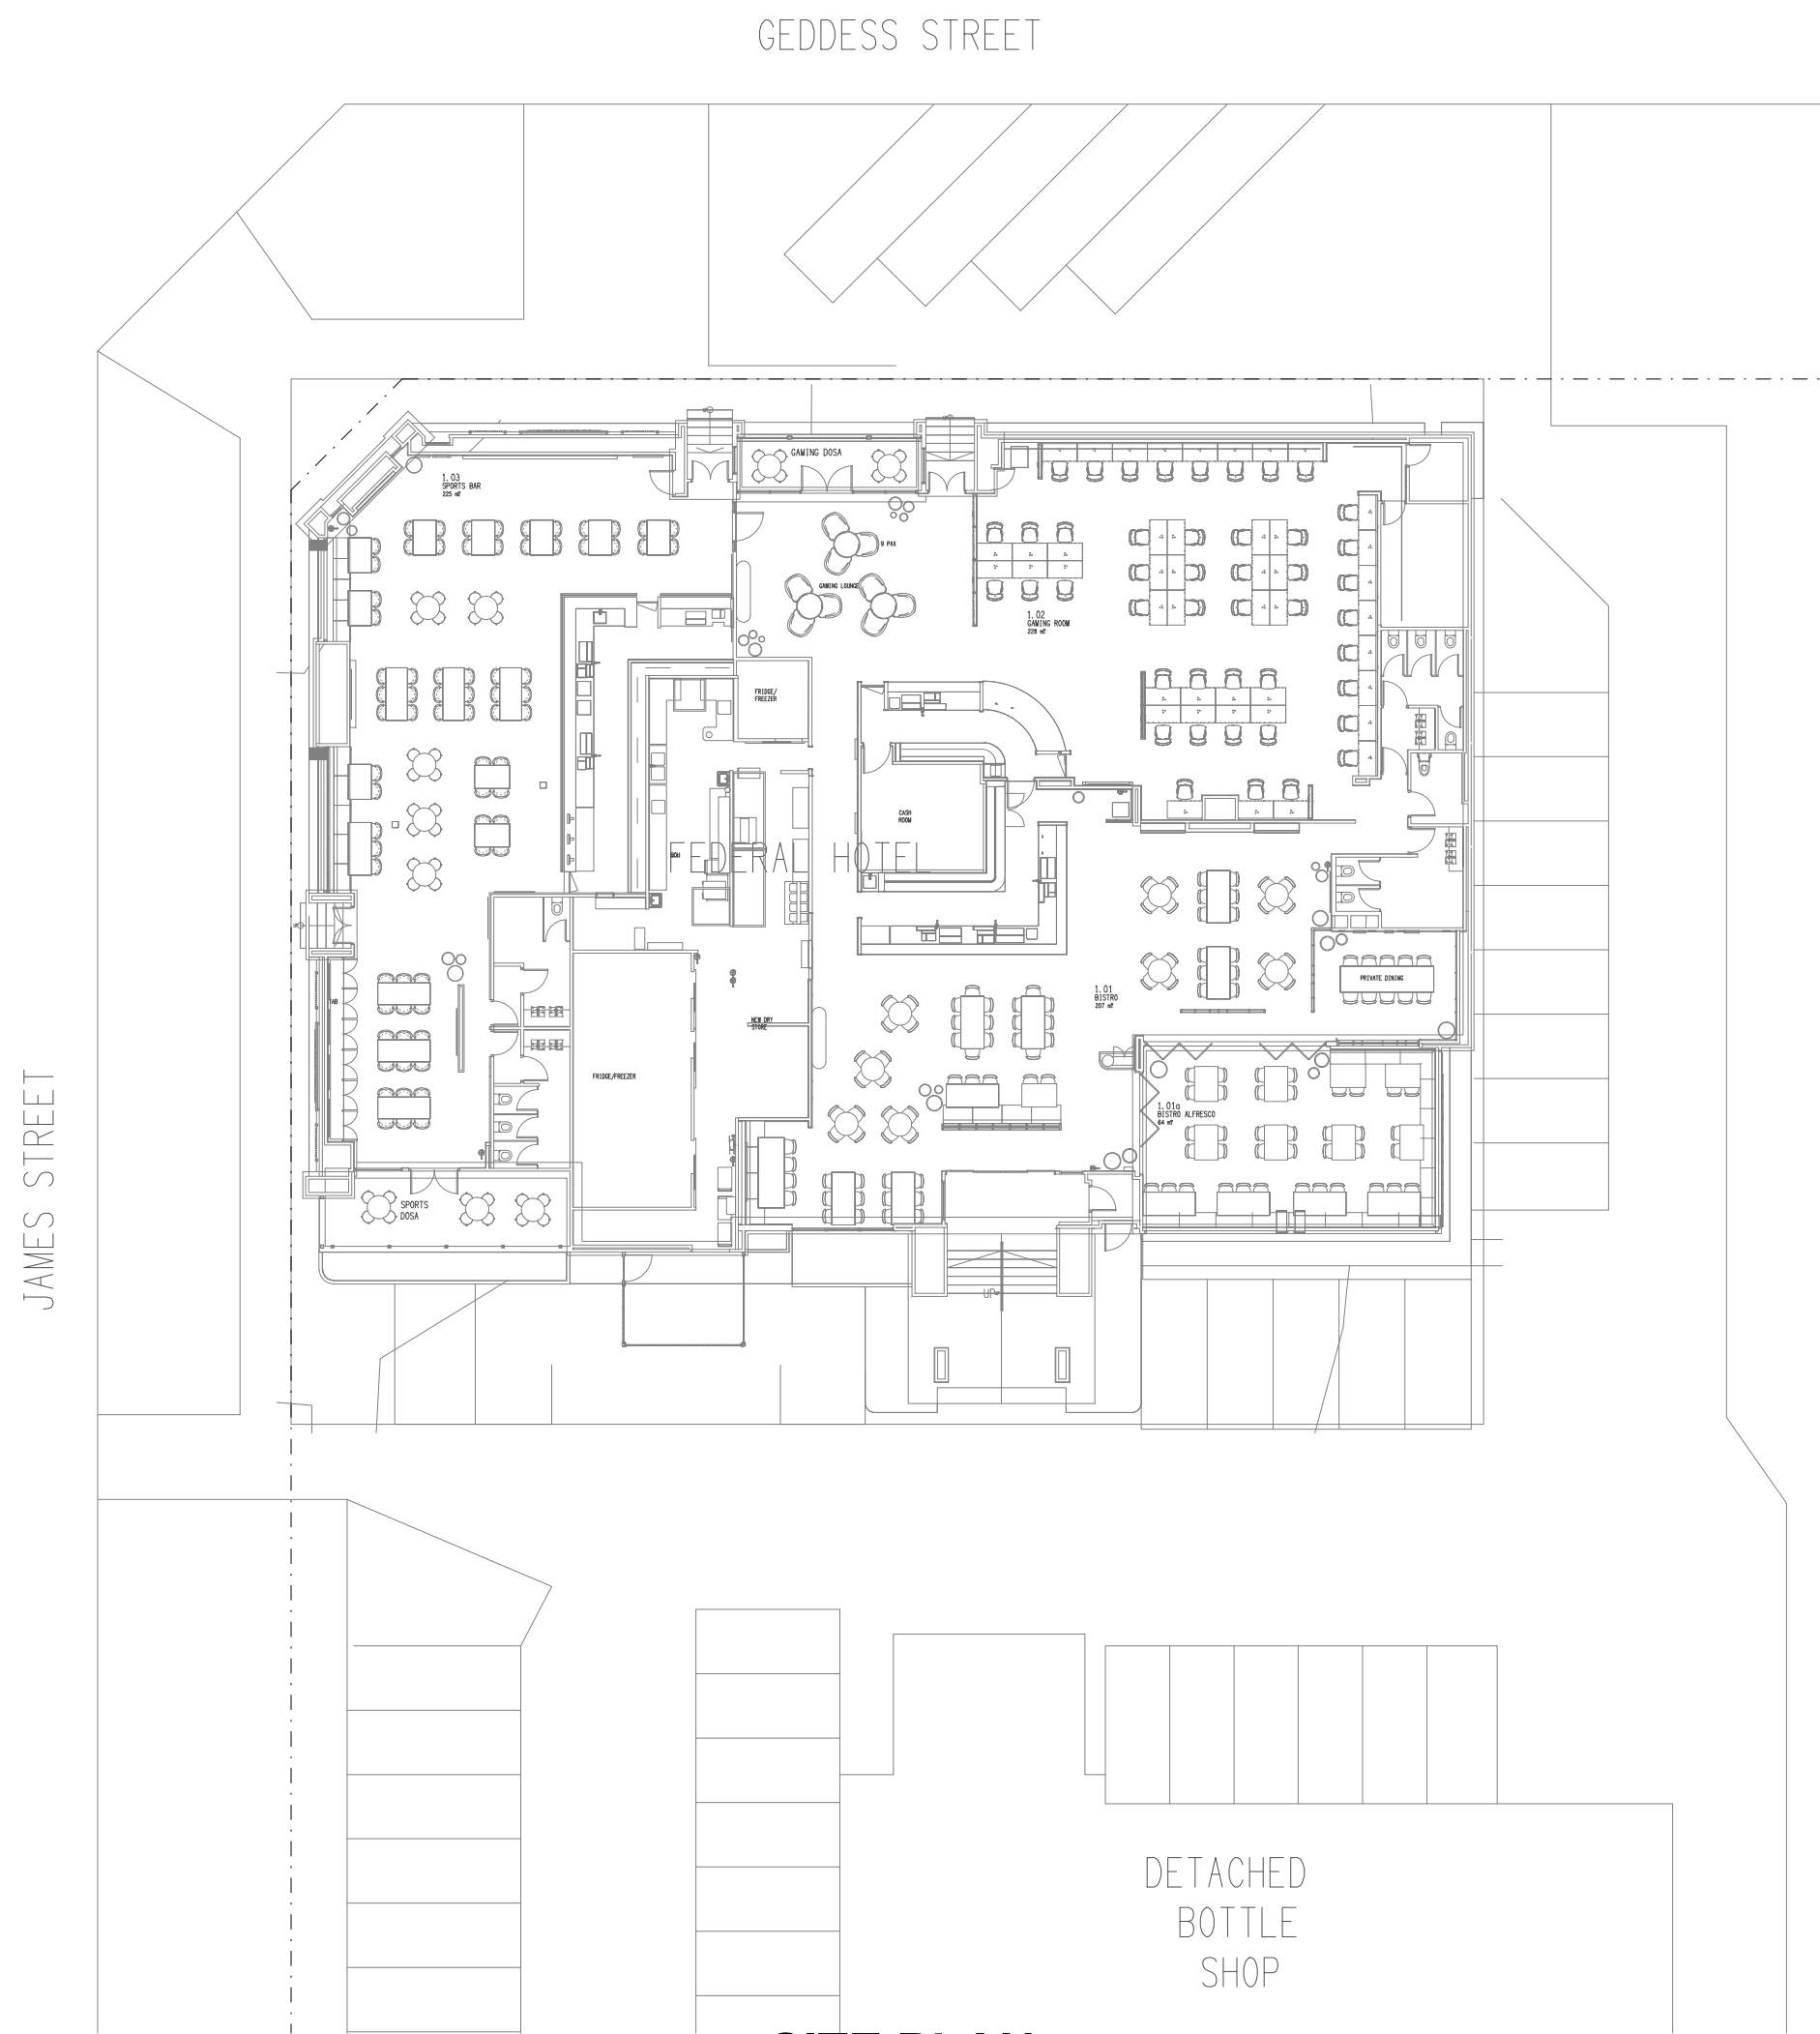

SITE PLAN
FEDERAL HOTEL
SCALE 1:250

EQUIPMENT:


- TEST - TEST PUSH BUTTON MOUNTED ON THE DISTRIBUTION BOARD ESCUTCHEON.
- RESET - RESET PUSH BUTTON MOUNTED ON THE DISTRIBUTION BOARD ESCUTCHEON.
- LAMP - AMBER TEST INDICATING LAMP MOUNTED ON THE DISTRIBUTION BOARD ESCUTCHEON.
- Ta - ADJUSTABLE 0-3 HOUR TIMED RELAY.
- Tb - 15 MINUTE RUN-ON TIMER TO OPERATE UPON THE RETURN OF MAINS POWER.
- Cx - CONTACTOR x.
- CRx - CONTROL RELAY x.
- Rx - RELAY x.

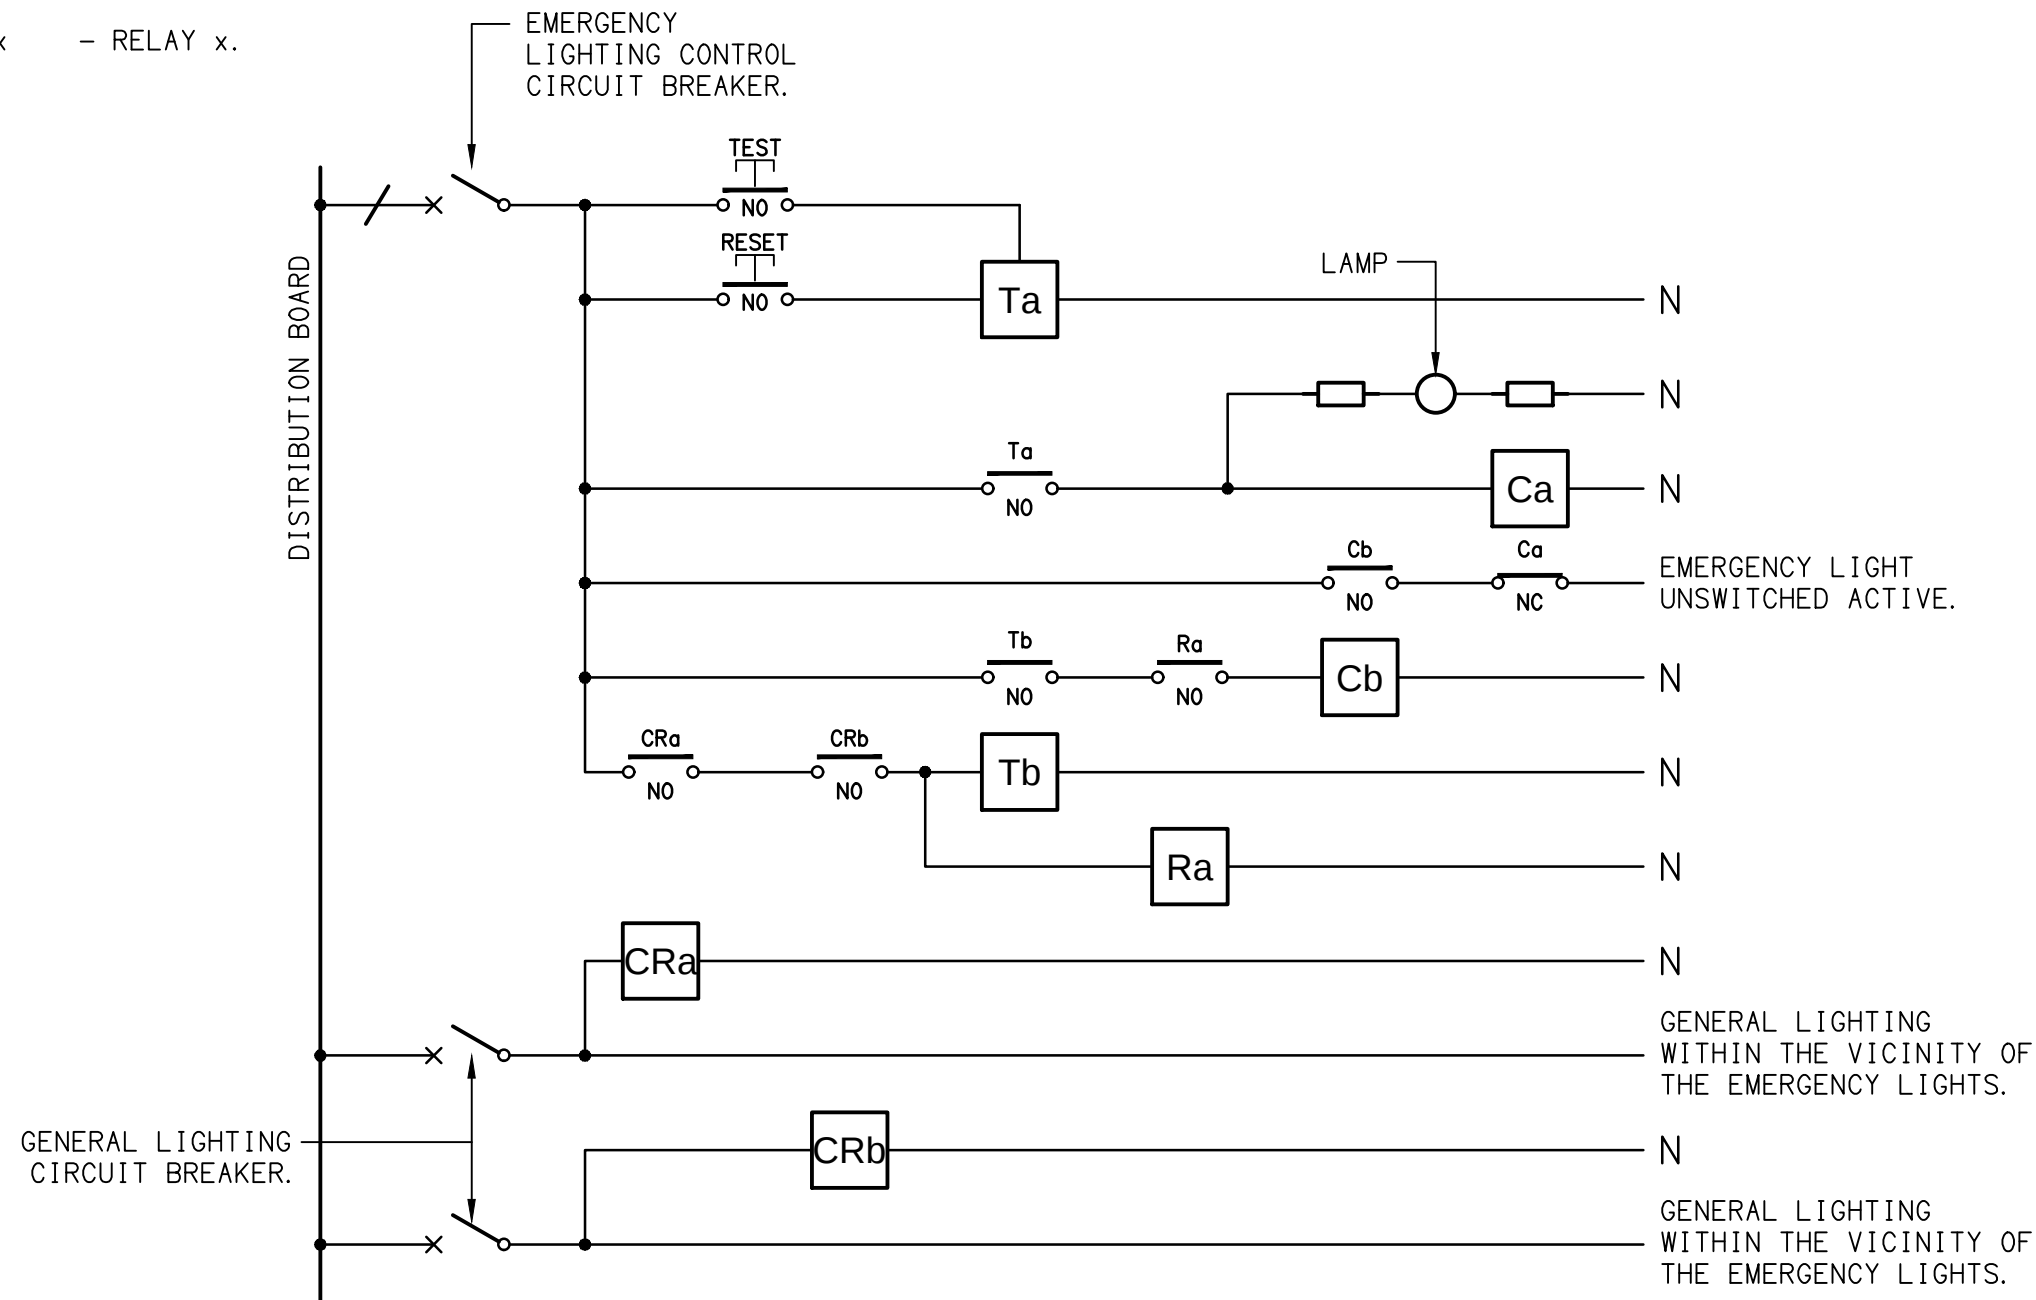

NOTES

- THE EMERGENCY LIGHT UNSWITCHED ACTIVE / GENERAL LIGHTING SWITCHED ACTIVE CIRCUIT ARRANGEMENT AND CONTROL IS TYPICAL FOR ALL CIRCUITS SUPPLYING EMERGENCY LIGHTS.
- PROVIDE ADDITIONAL CONTROL RELAYS (CRx) CONFIGURED AS PER CRa AND CRb FOR ALL ADDITIONAL LIGHTING CIRCUITS THAT SUPPLY LIGHTS IN THE VICINITY OF THE EMERGENCY LIGHTS.

SCHEMATIC
EMERGENCY LIGHTING
NOT TO SCALE

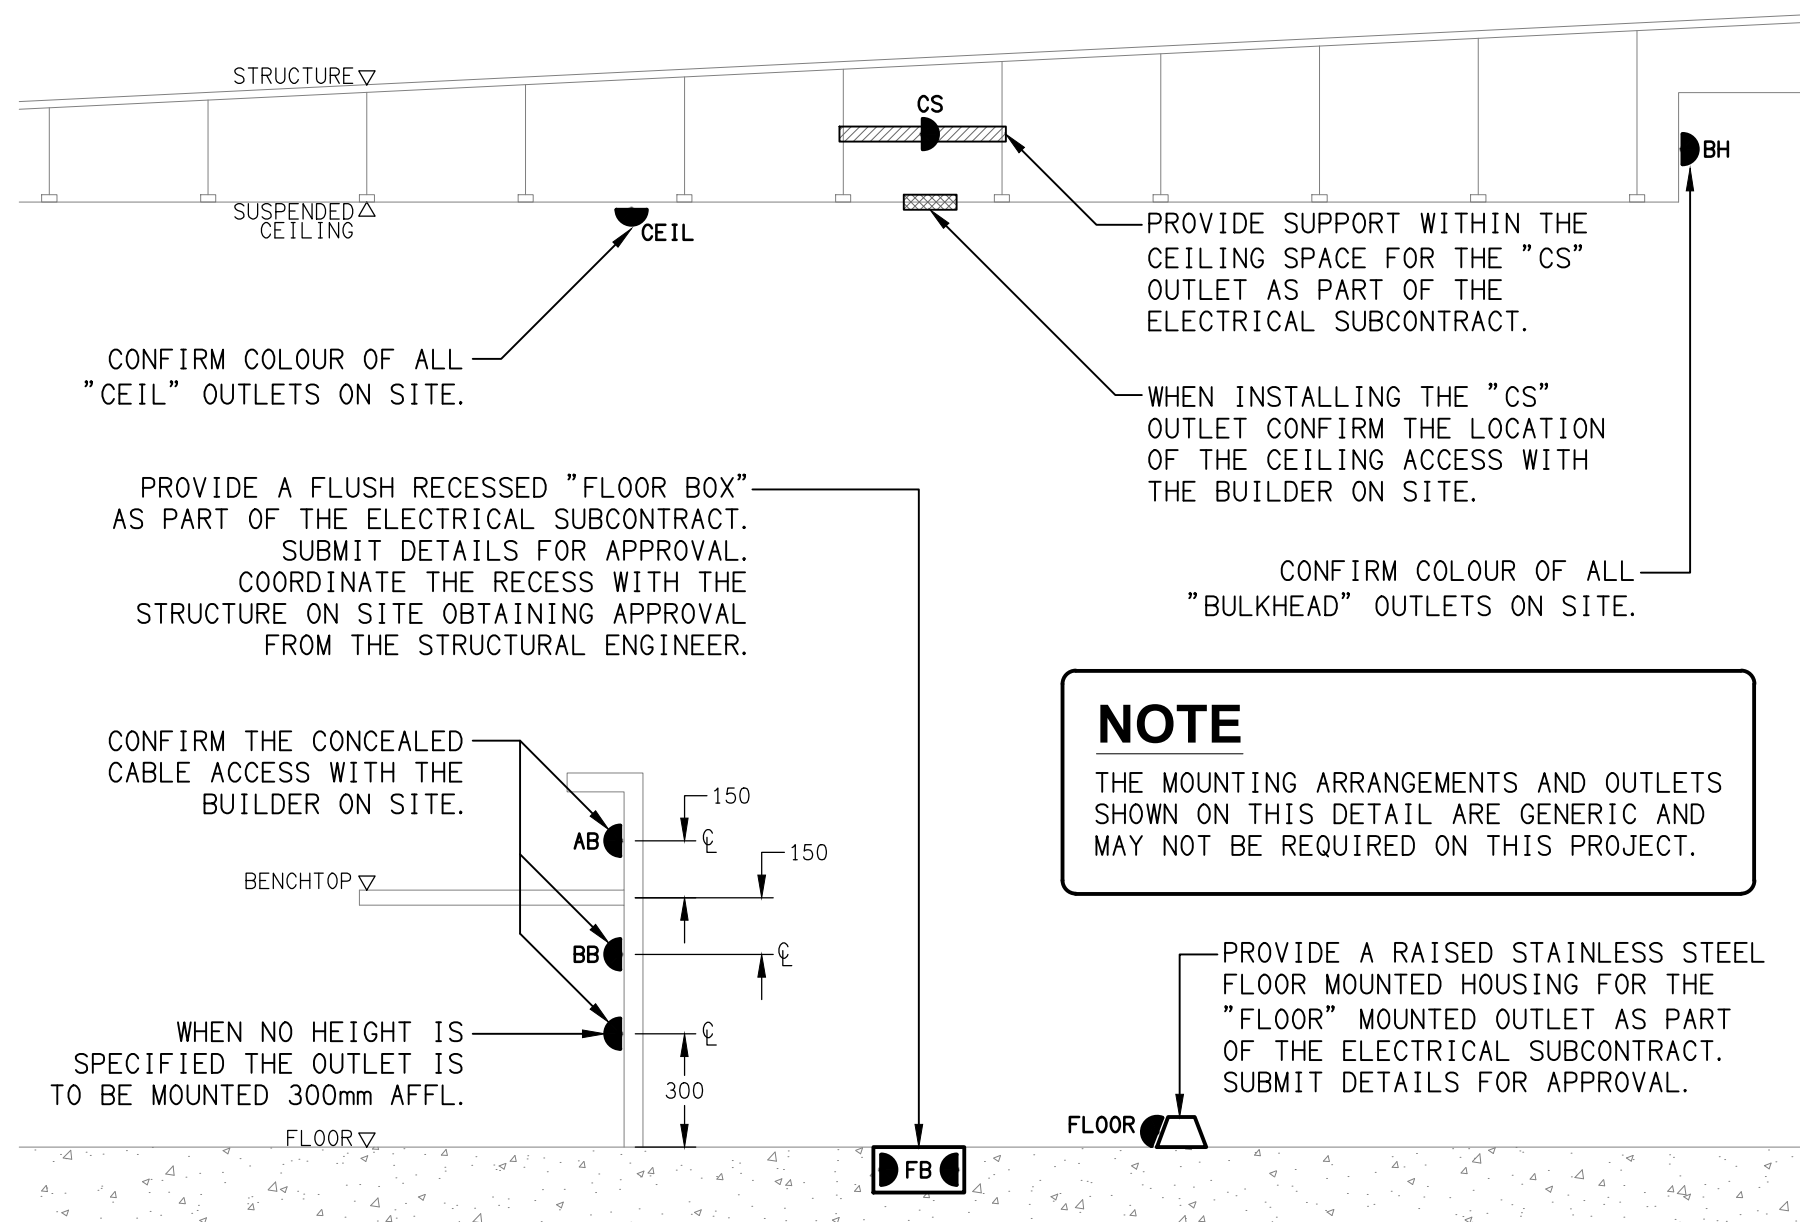

DETAIL
TYPICAL OUTLET MOUNTINGS
NOT TO SCALE