



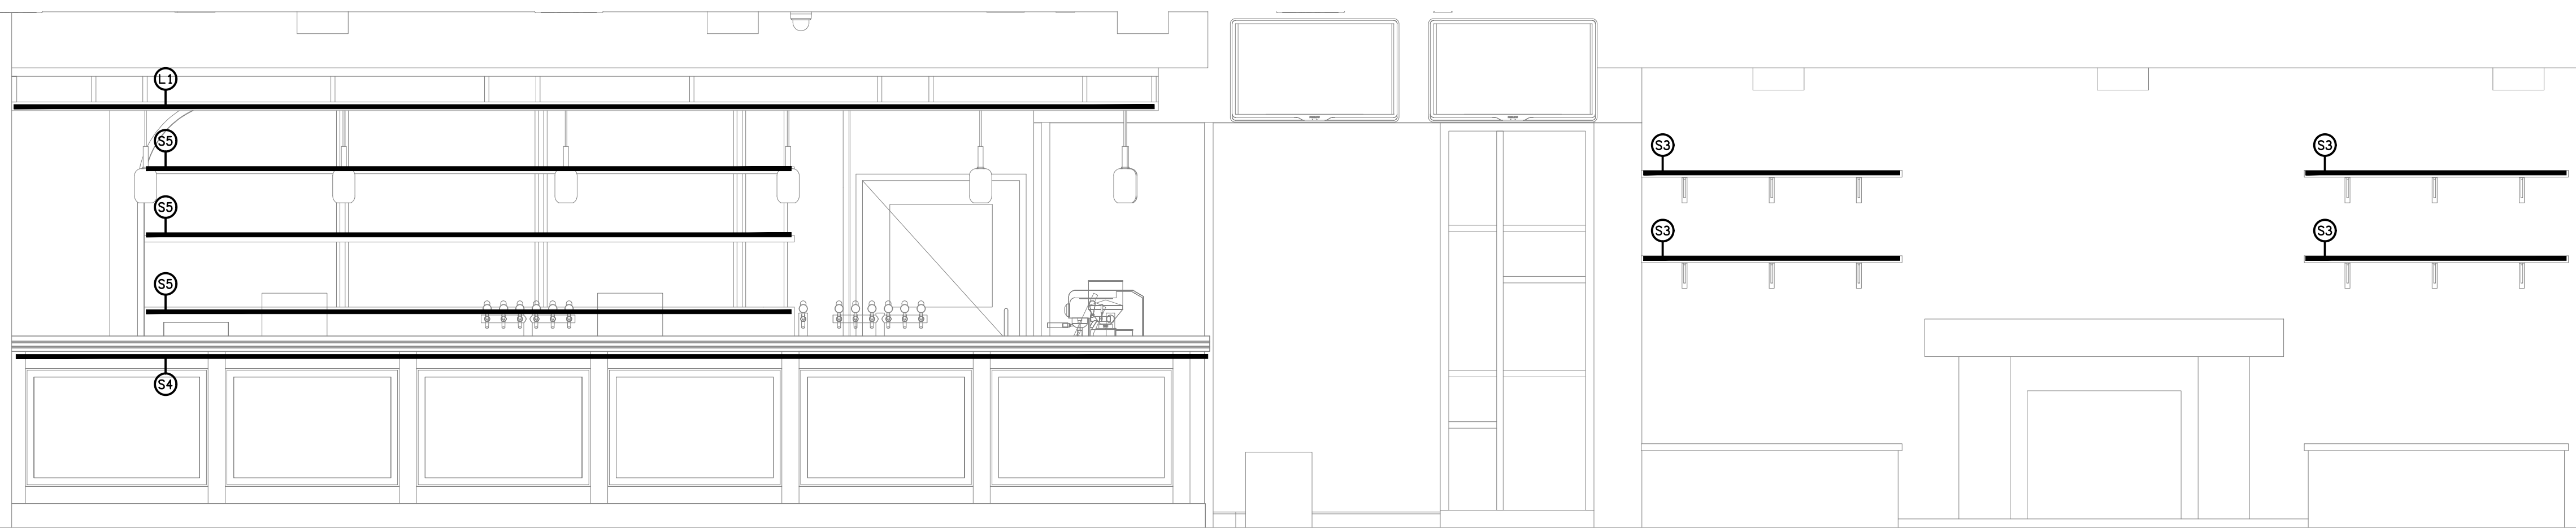


DETAIL A
BISTRO BAR & WALL ELEVATION
SCALE 1: 25


DETAIL E
TYPICAL SEATING S2 STRIP LIGHT SECTION
SCALE 1: 10

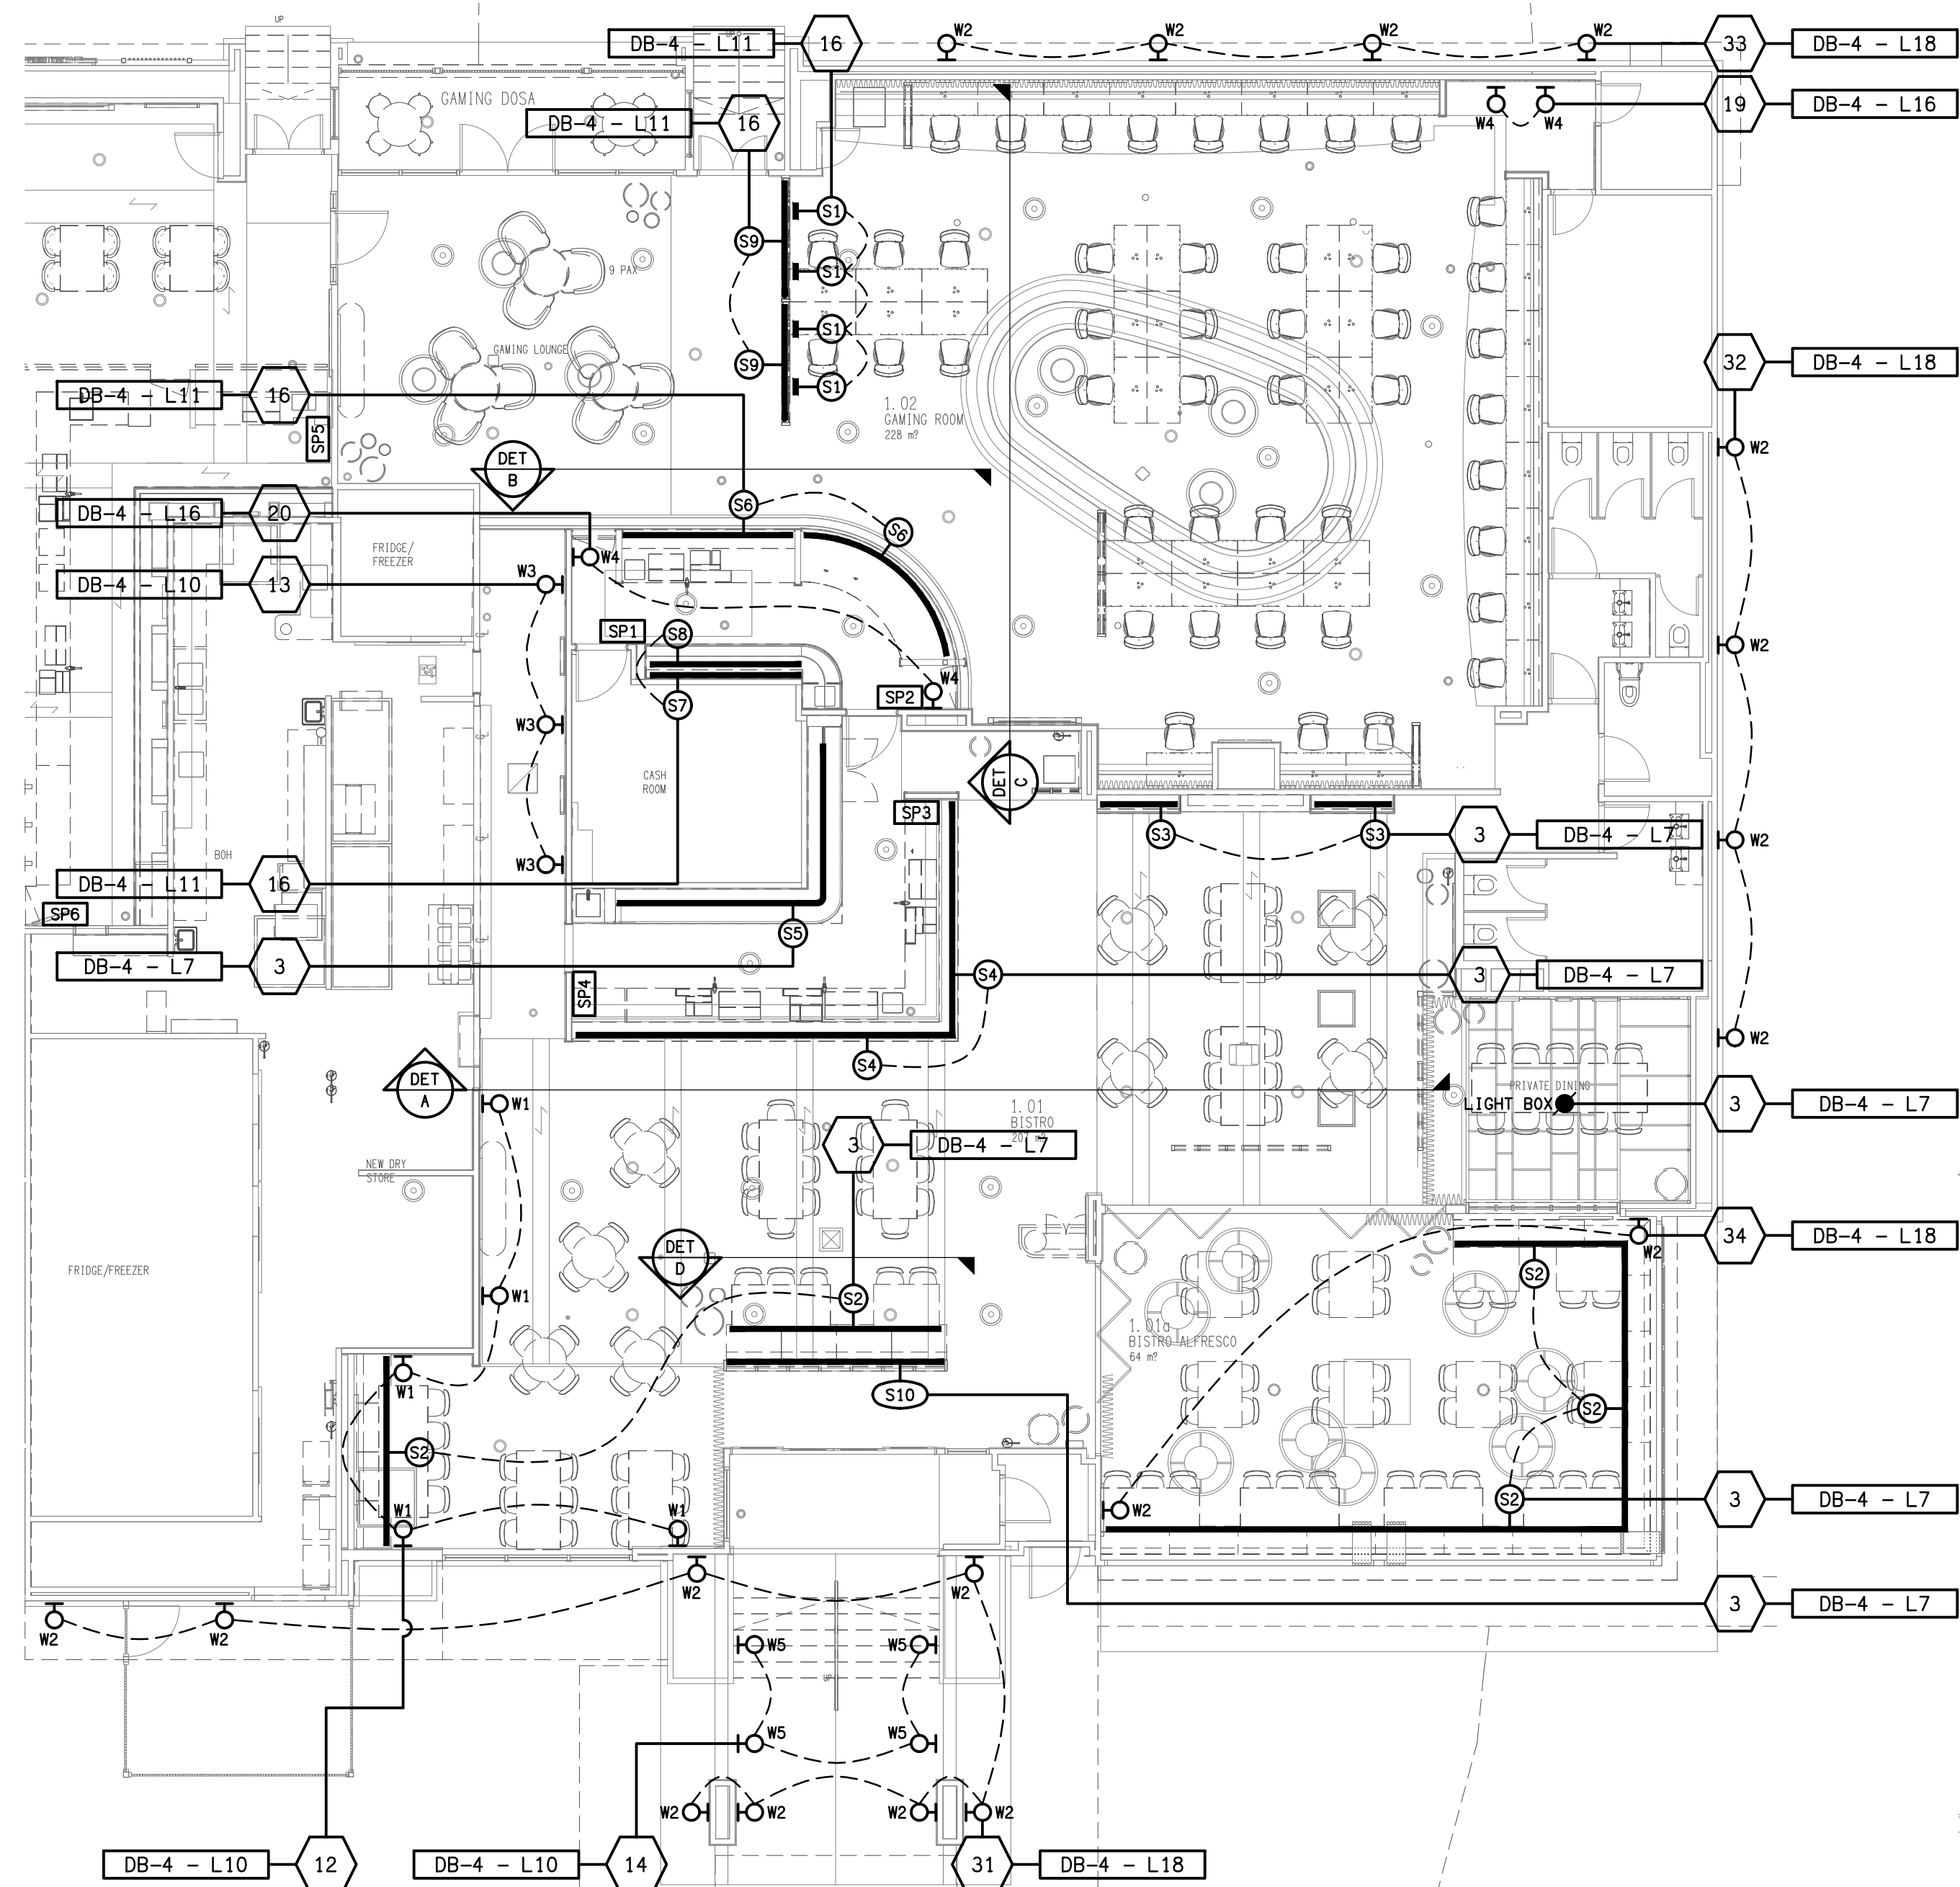


PLAN
JOINERY & WALL LIGHTING
SCALE 1: 100

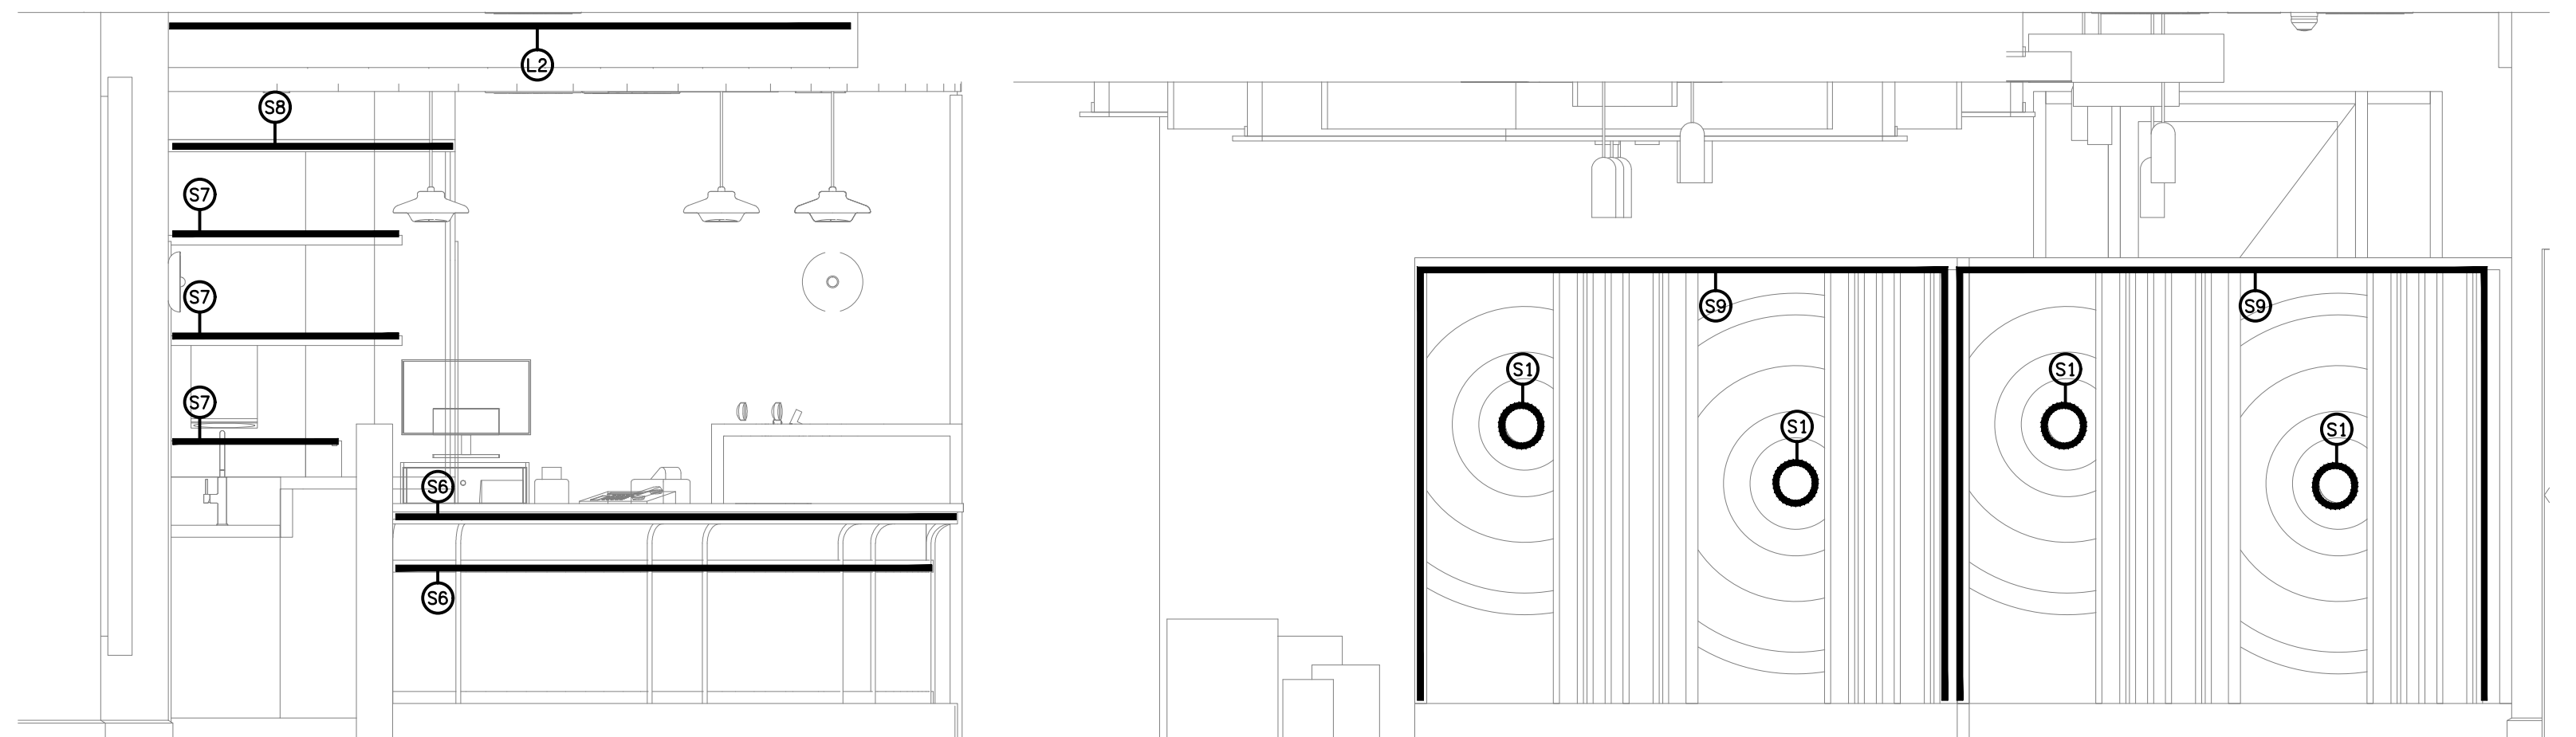

DETAIL C
GAMING BAR & SCREEN ELEVATION
SCALE 1: 25

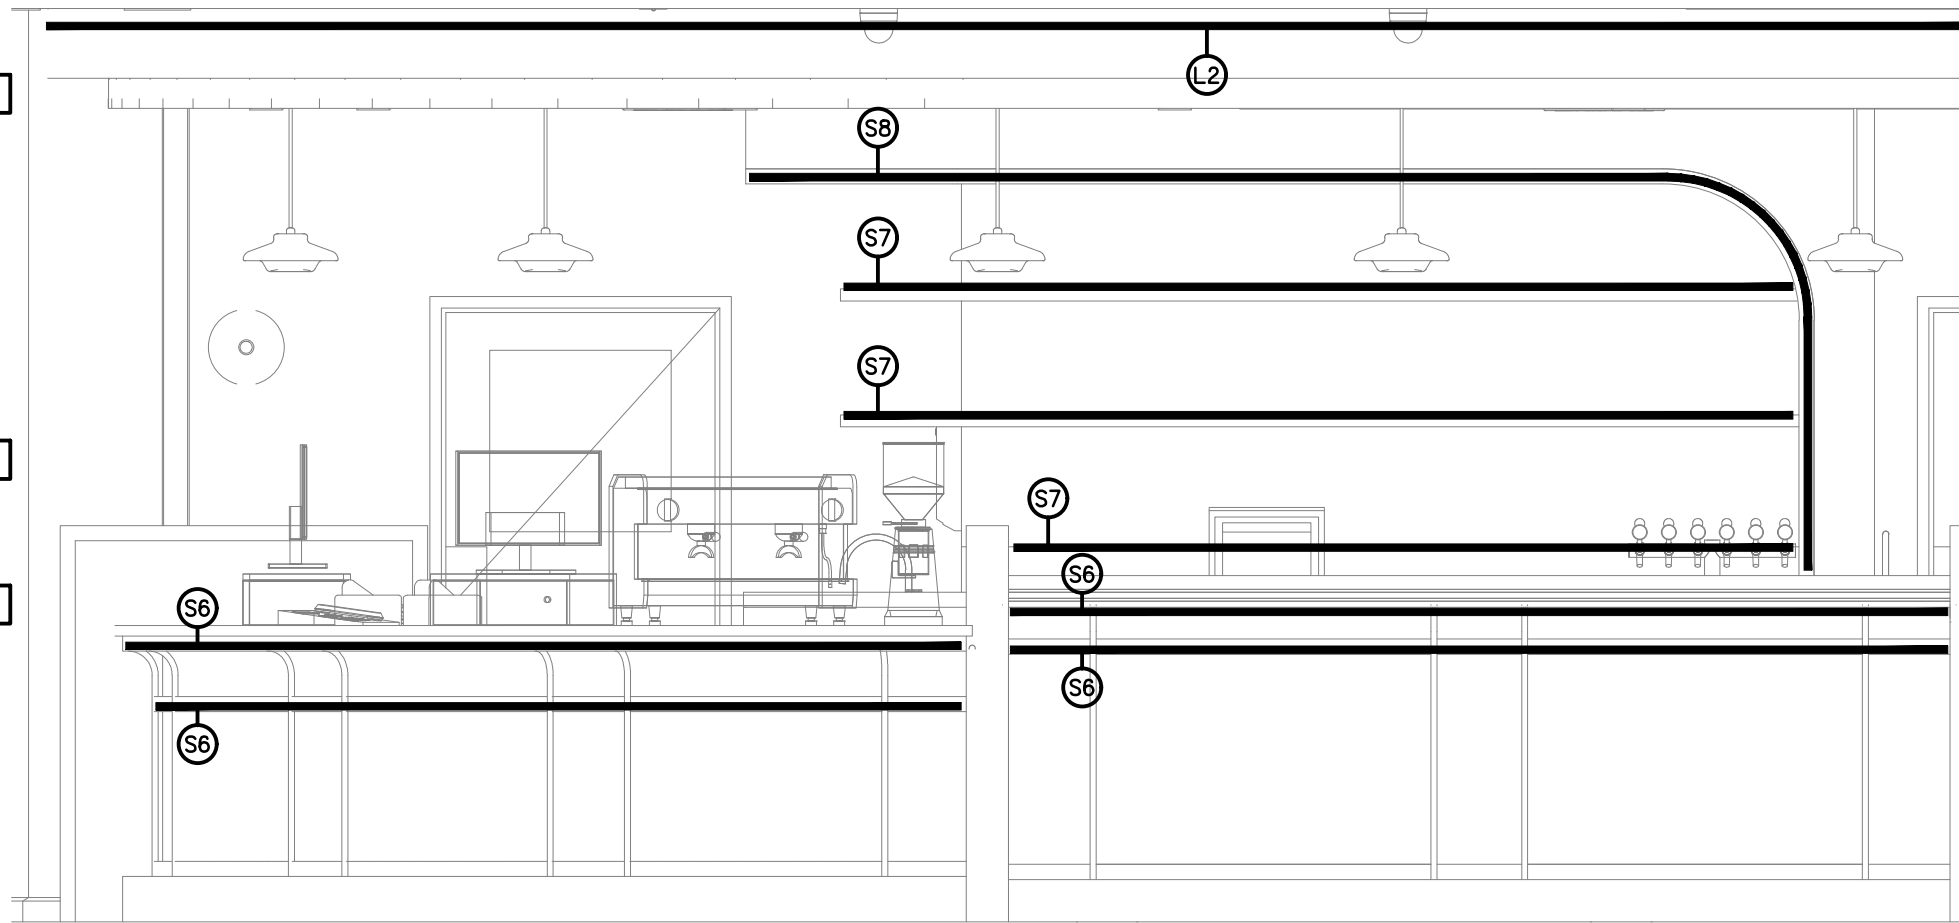

DETAIL B
GAMING BAR & WALL ELEVATION
SCALE 1: 25

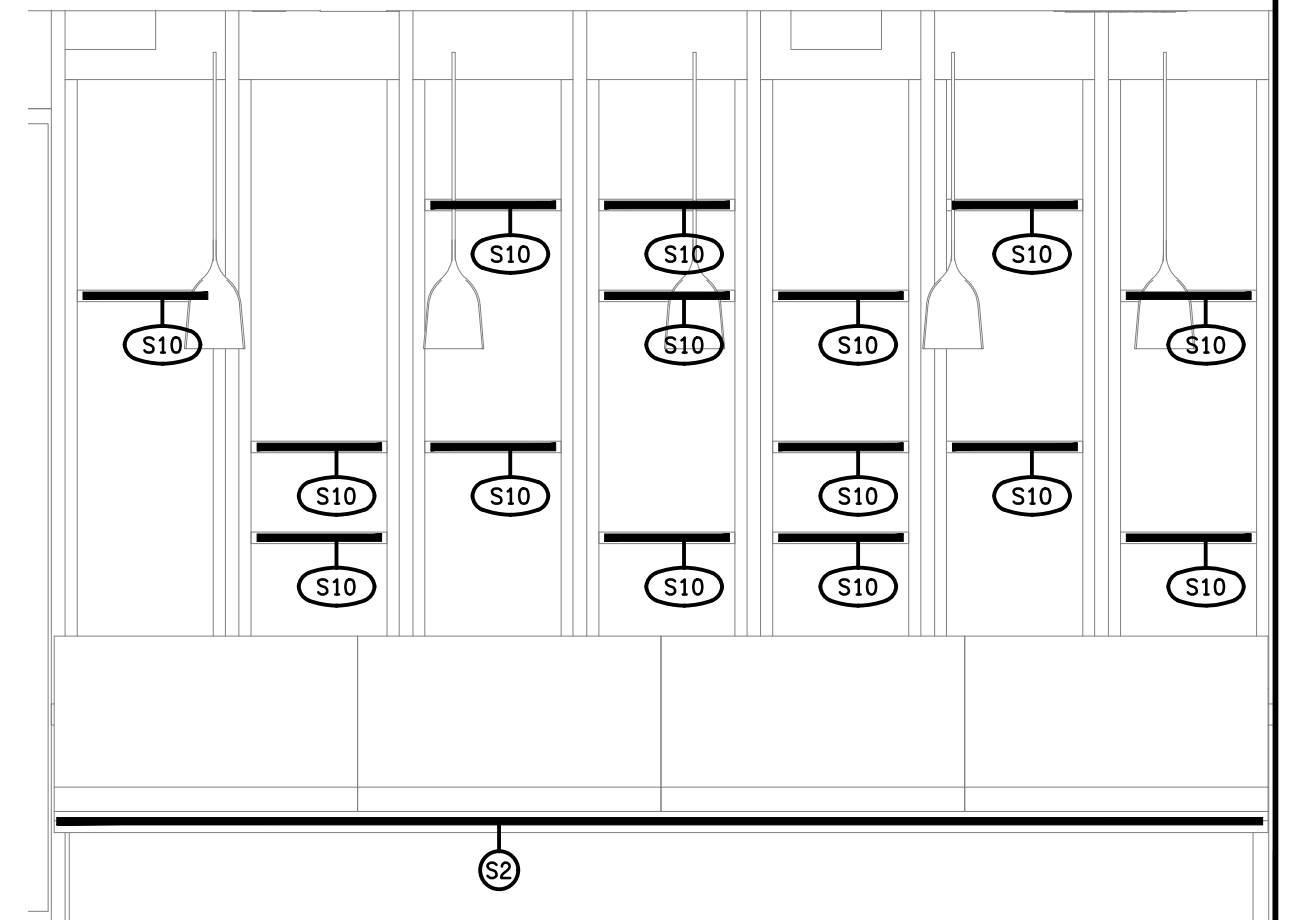

DETAIL D
BISTRO DINING FEATURE WALL ELEVATION
SCALE 1: 25

ELECTRICAL DESIGN GROUP BRISBANE
PTY LTD
ACN 092 710 793
TRADING AS:
ELECTRICAL DESIGN GROUP

THE COPYRIGHT OF THIS DRAWING
REMAINS THE PROPERTY OF THE
ELECTRICAL DESIGN GROUP.
USE FIGURED DIMENSIONS
IN PREFERENCE TO SCALE.
ALL DIMENSIONS TO BE
VERIFIED ONSITE.

ELECTRICAL DESIGN GROUP
ELECTRICAL BUILDING SERVICES CONSULTANTS
BRISBANE GOLD COAST

P.O.Box 15, Sherwood Q.4075
Phone: (07) 3278 4375
Email: brisbane@edg.net.au
Web: www.edg.net.au

PROJECT:
FEDERAL HOTEL, TOOWOOMBA

111 JAMES STREET, TOOWOOMBA CITY, QUEENSLAND

A	TENDER	14/08/2026
REV.	DESCRIPTION:	DATE:

DRAWING:
ELECTRICAL SERVICES
JOINERY & WALL LIGHTING PLAN

SCALE:
1:100 UNO

AT A1

PROJECT NO:
C3770a

DRAWING NO:
E05

REVISION:
A