



#### DETAIL A

RECEPTION KITCHENETTE ELEVATION  
SCALE 1: 25

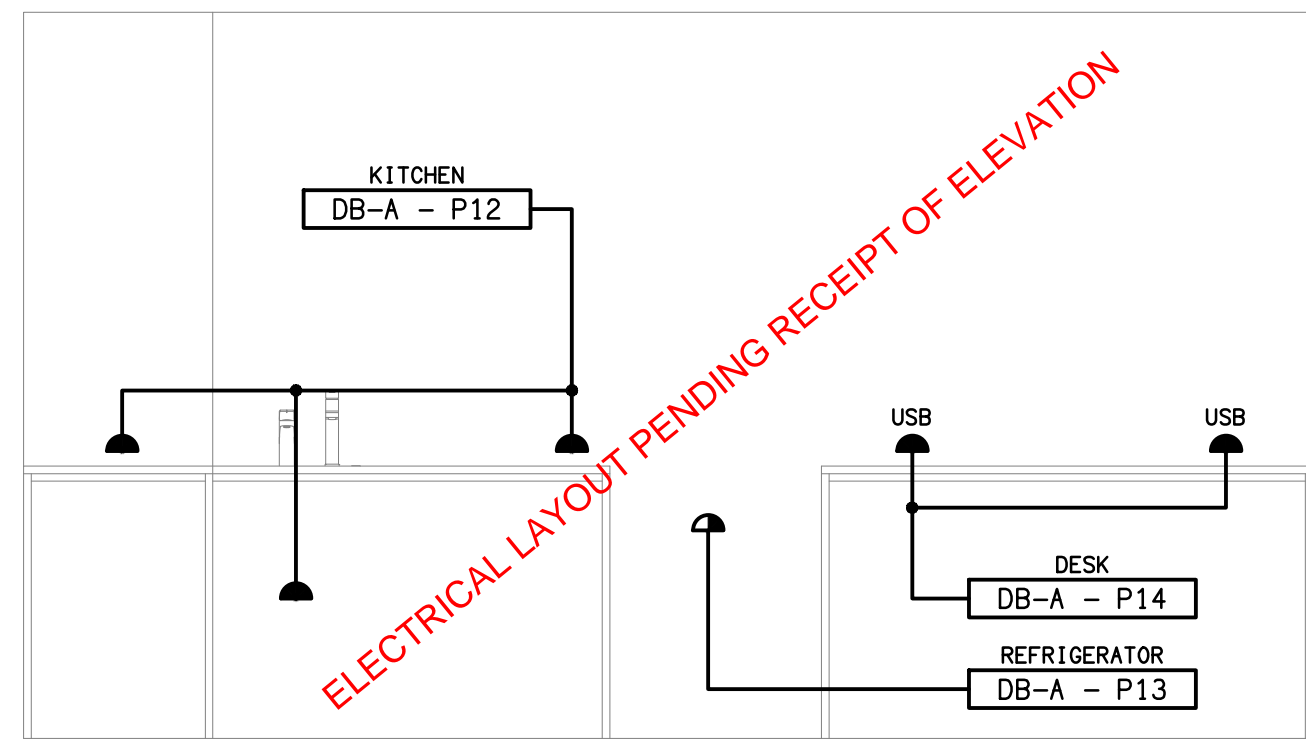


#### DETAIL B

STAFF KITCHENETTE ELEVATION  
SCALE 1: 25

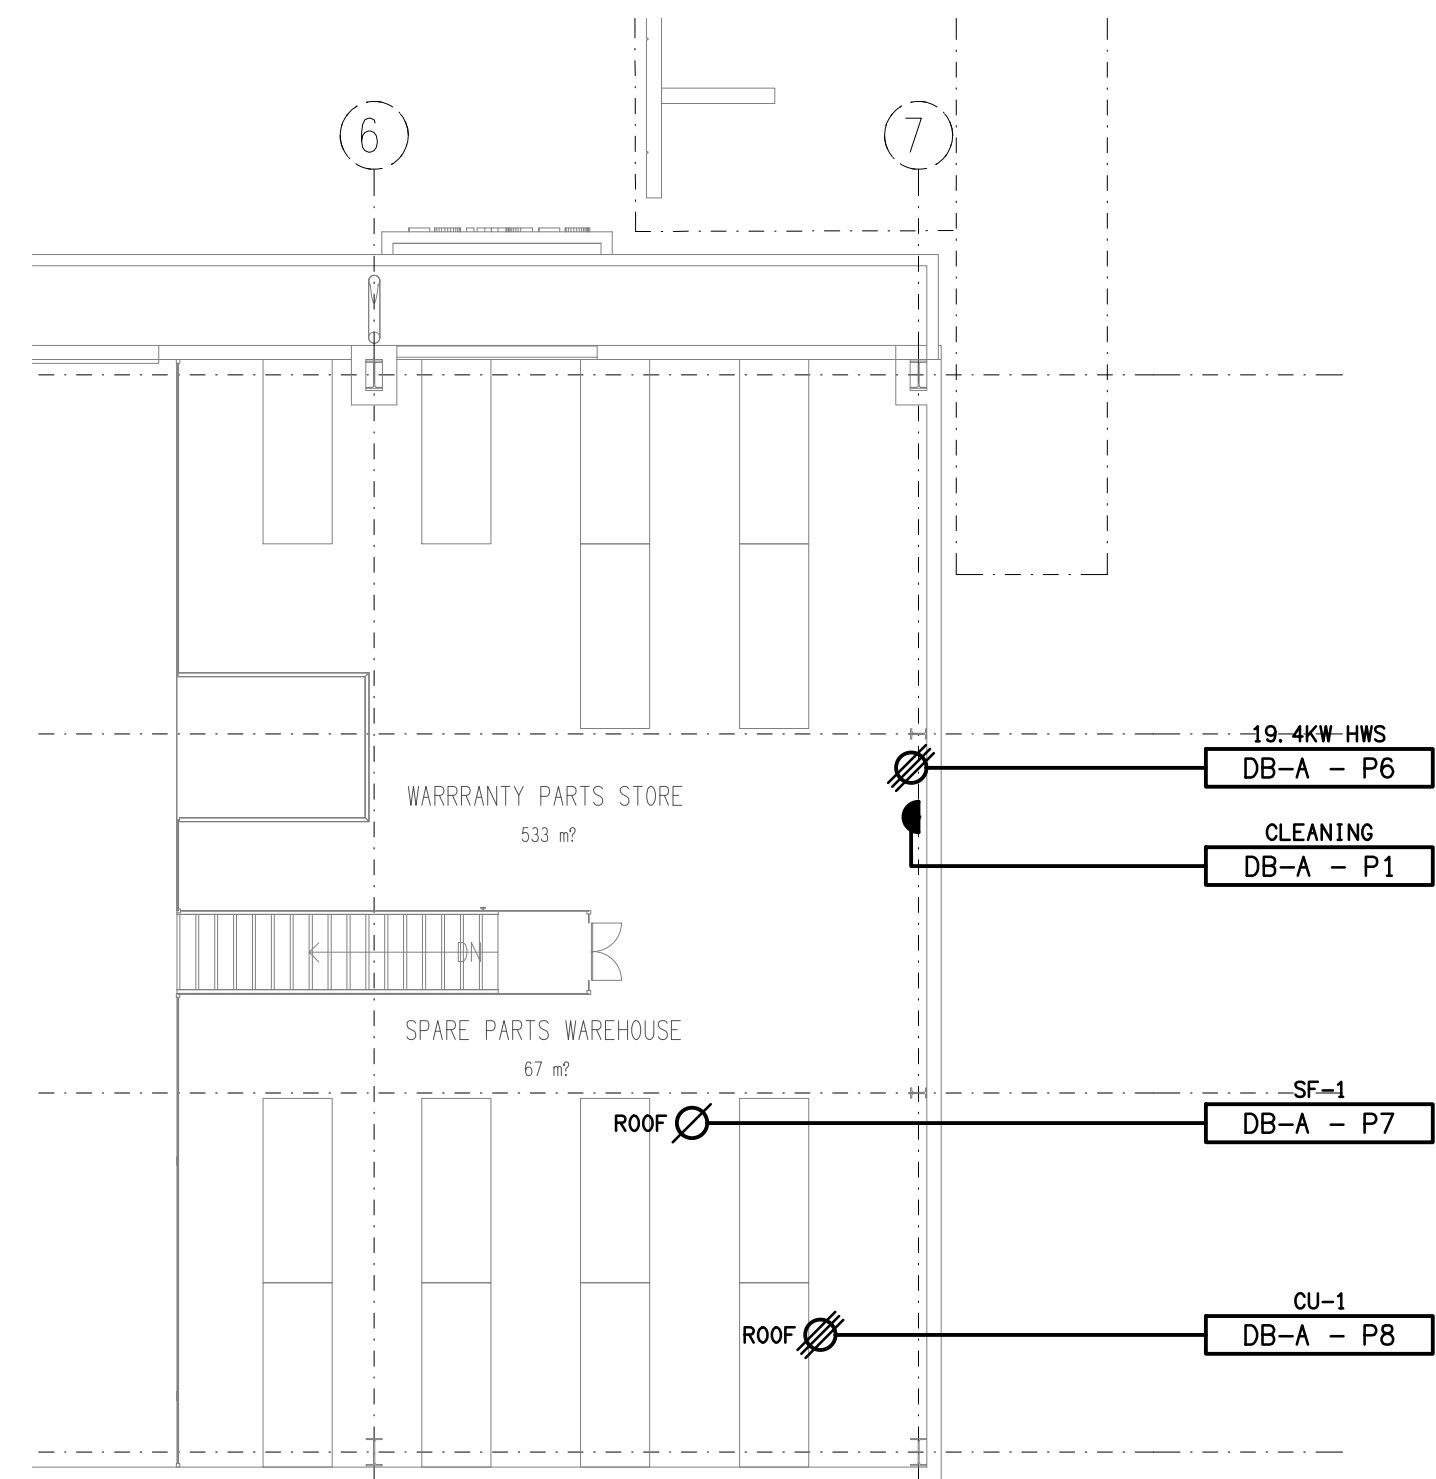

#### MEZZANINE LEVEL

FLOOR PLAN  
SCALE 1: 100

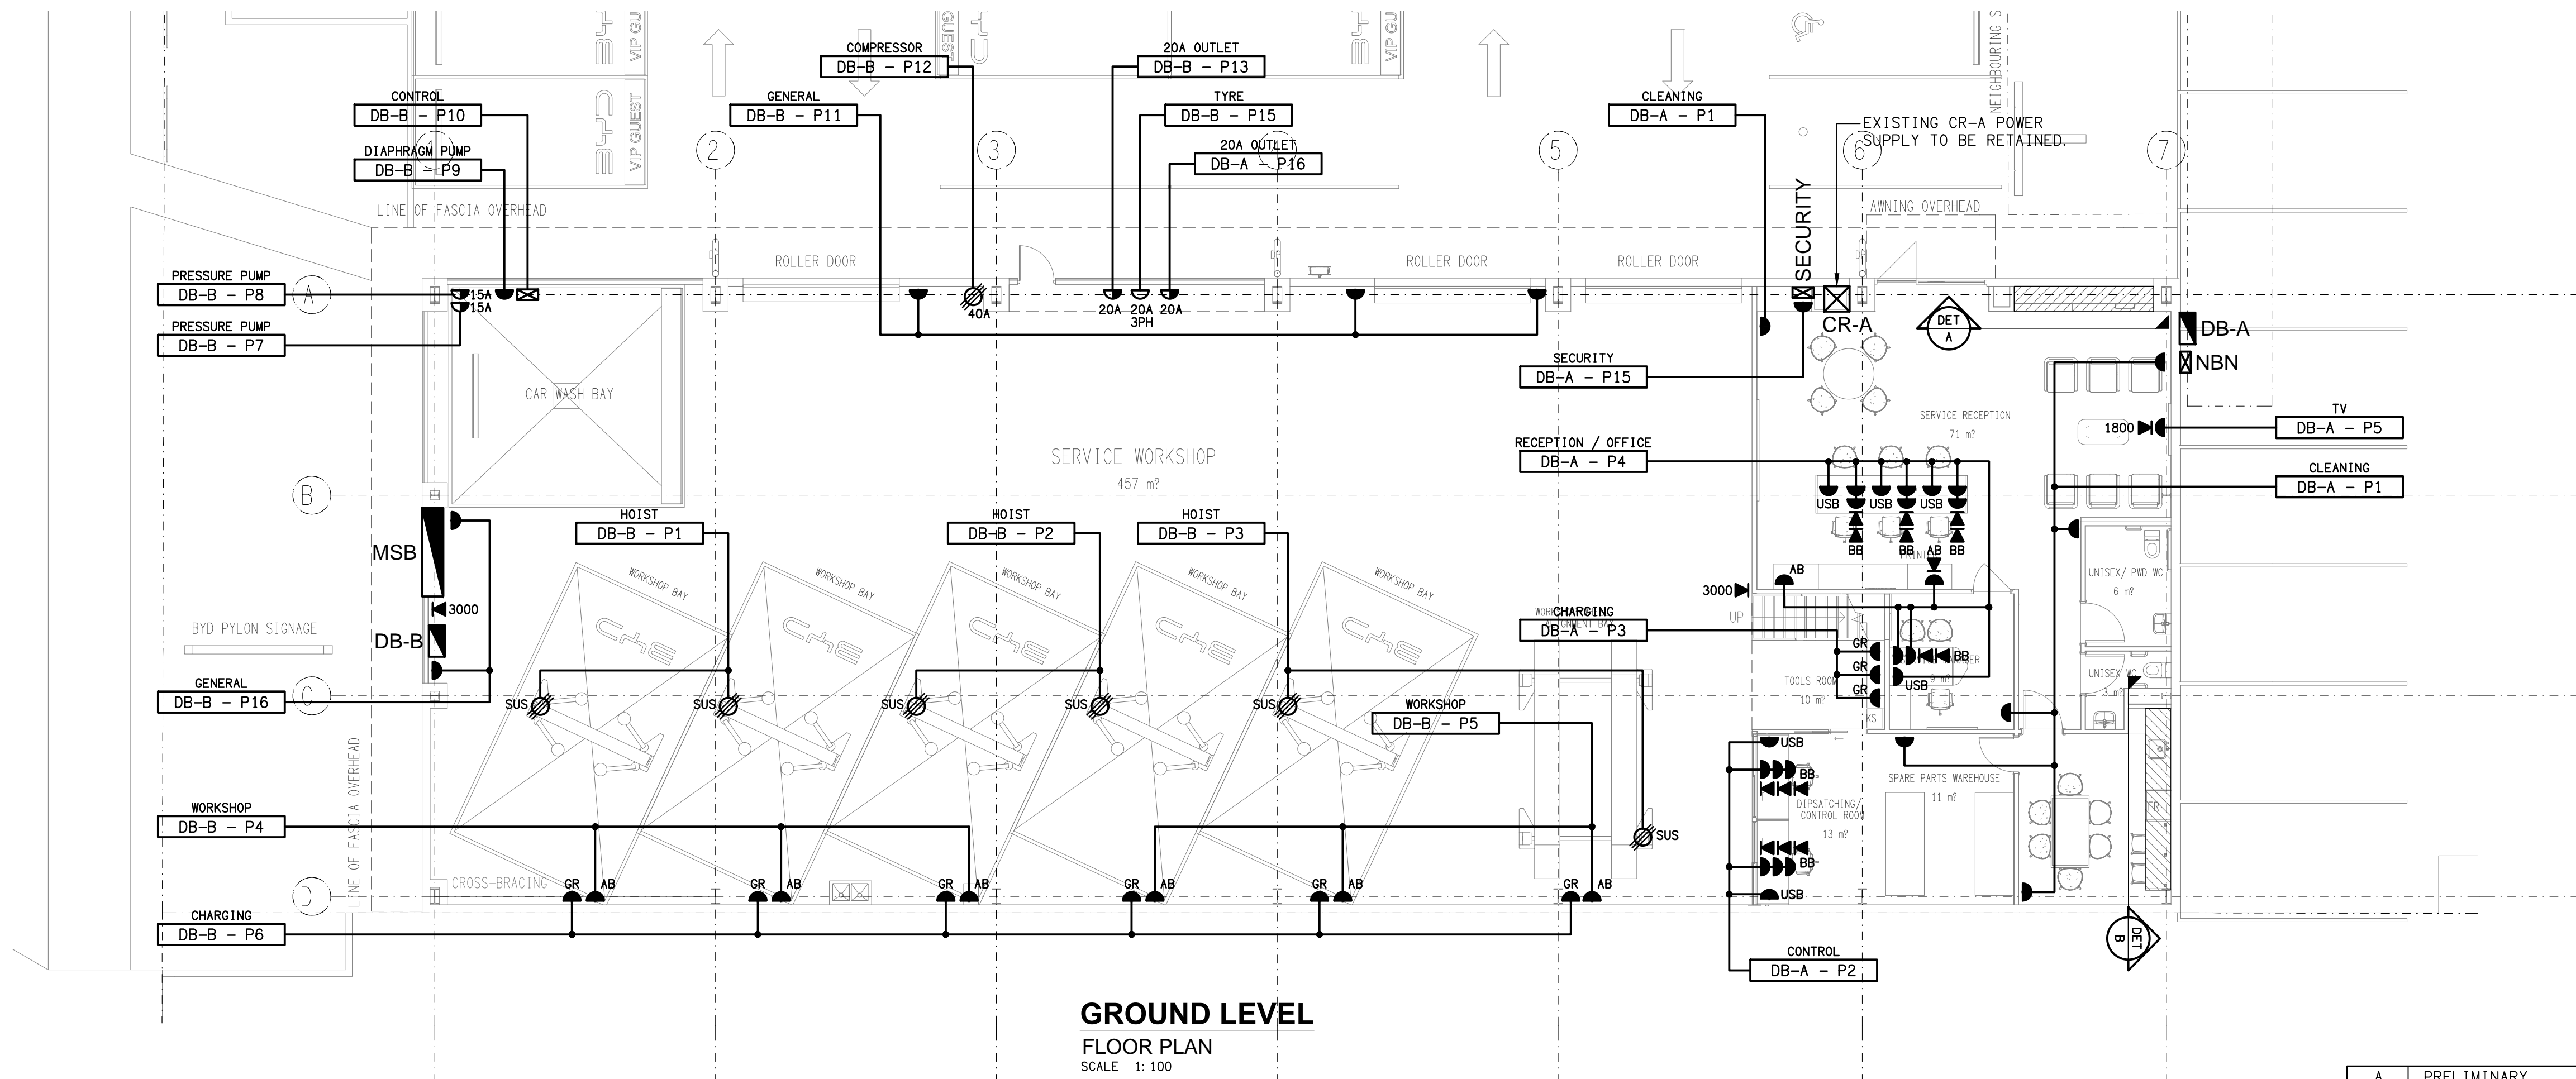

#### GROUND LEVEL

FLOOR PLAN  
SCALE 1: 100

ELECTRICAL DESIGN GROUP BRISBANE  
PTY LTD  
ACN 092 710 793  
TRADING AS:  
ELECTRICAL DESIGN GROUP

THE COPYRIGHT OF THIS DRAWING  
REMAINS THE PROPERTY OF THE  
ELECTRICAL DESIGN GROUP.  
USE FIGURED DIMENSIONS  
IN PREFERENCE TO SCALE.  
ALL DIMENSIONS TO BE  
VERIFIED ONSITE.

**ELECTRICAL DESIGN GROUP**  
ELECTRICAL BUILDING SERVICES CONSULTANTS  
BRISBANE GOLD COAST

P.O. Box 15, Sherwood Q.4075  
Phone: (07) 3278 4375  
Email: brisbane@edg.net.au  
Web: www.edg.net.au

PROJECT:  
EAGERS CAPALABA, BYD SERVICE

1/84 REDLAND BAY ROAD, CAPALABA

|      |              |            |
|------|--------------|------------|
| A    | PRELIMINARY  | 04/06/2026 |
| REV: | DESCRIPTION: | DATE:      |

DRAWING:  
**ELECTRICAL SERVICES  
FLOOR PLAN**

SCALE:  
1:100 UNO

AT A1

PROJECT NO:  
**C3775a**

DRAWING NO:  
**E04**

REVISION:  
**A**