


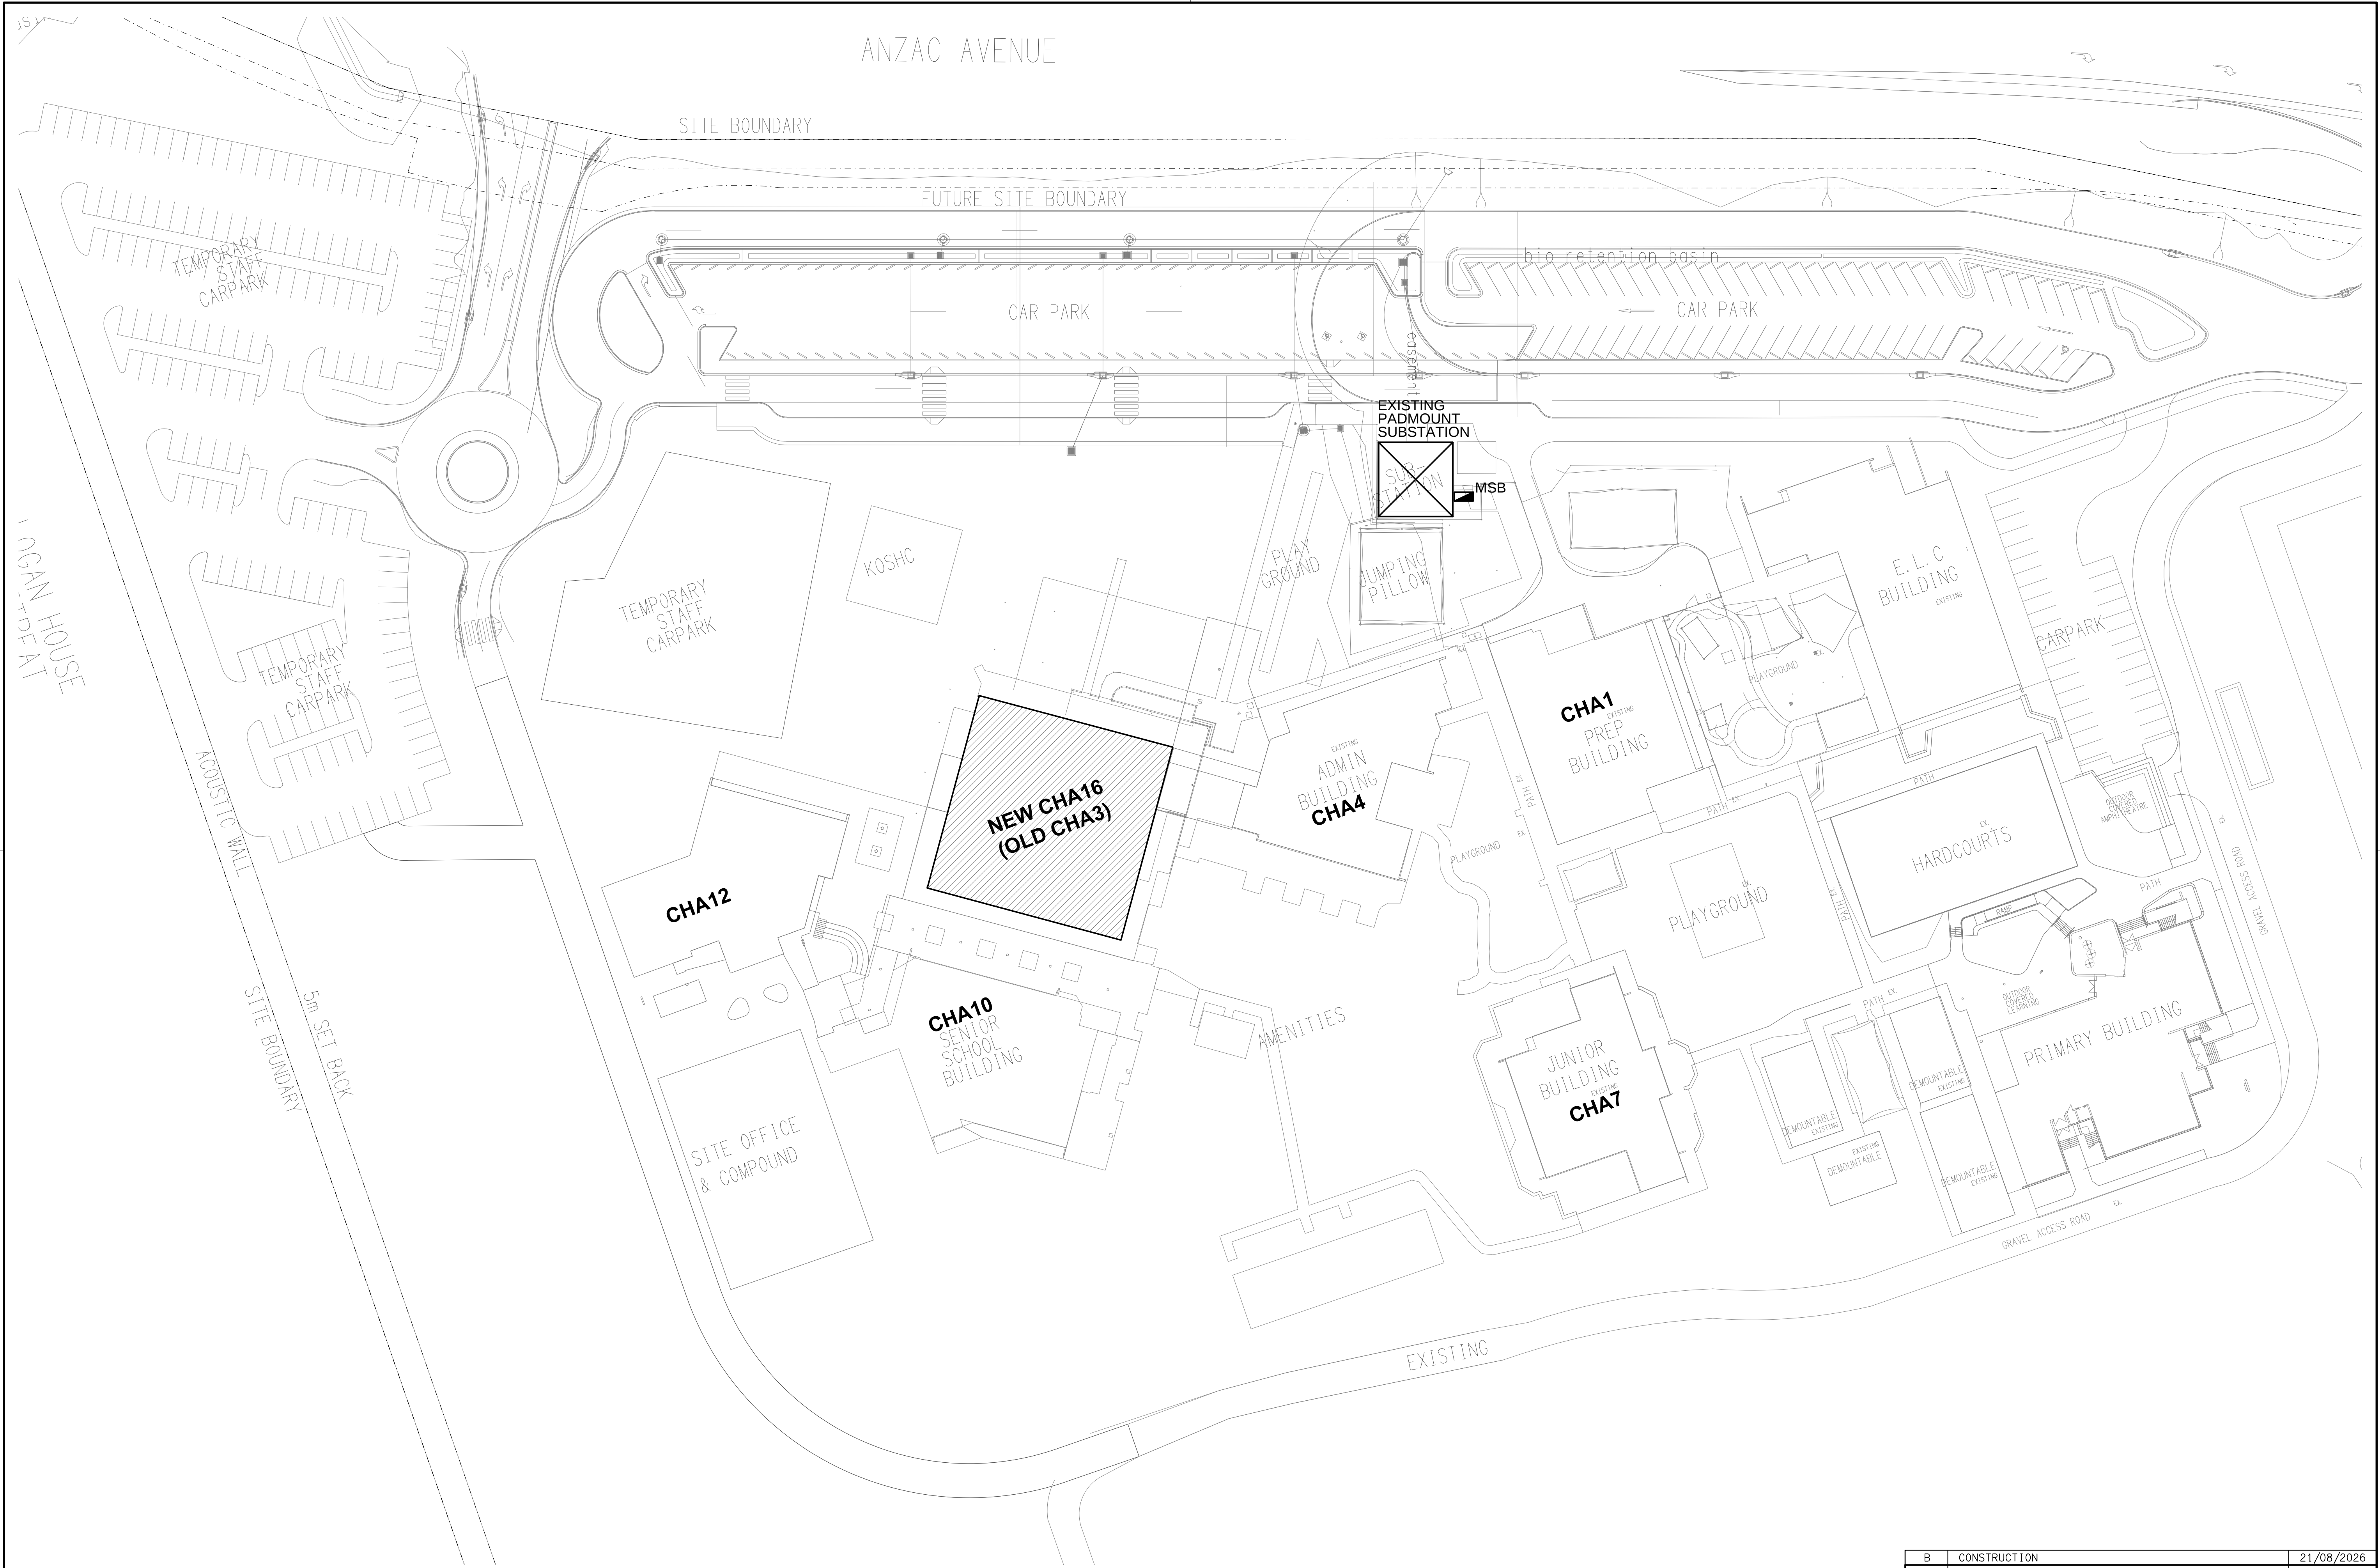

ELECTRICAL DESIGN GROUP BRISBANE PTY LTD ACN 092 710 793 TRADING AS: ELECTRICAL DESIGN GROUP	THE COPYRIGHT OF THIS DRAWING REMAINS THE PROPERTY OF THE ELECTRICAL DESIGN GROUP. USE FIGURED DIMENSIONS IN PREFERENCE TO SCALE. ALL DIMENSIONS TO BE VERIFIED ONSITE.	ELECTRICAL DESIGN GROUP ELECTRICAL BUILDING SERVICES CONSULTANTS BRISBANE GOLD COAST P.O.Box 15, Sherwood Q.4075 Phone: (07) 3278 4375 Email: brisbane@edg.net.au Web: www.edg.net.au	PROJECT: KINGS CHRISTIAN COLLEGE CHAMBERS FLAT, MIDDLE SCHOOL CHA16 AUDITORIUM 38-112 ANZAC AVENUE, CHAMBERS FLAT	DRAWING: ELECTRICAL SERVICES SITE PLAN SCALE: 1:500 AT A1 PROJECT NO: C3777a DRAWING NO: E03 REVISION: B
--	--	--	--	---