



ELECTRICAL DESIGN GROUP

ELECTRICAL BUILDING SERVICES CONSULTANTS

P.O. Box 15, SHERWOOD Q. 4075

Phone: (07) 3278 4375

Website: www.edg.net.au Email: brisbane@edg.net.au

C3811a - SURFERS PARADISE BEER GARDEN

C3811a-0001(A).xls


ELECTRICAL SERVICES CONTRACT DOCUMENT SCHEDULE

REVISION A - 28 JULY 2026


ISSUING INFORMATION				DATE OF ISSUE								
	DAY	MONTH	YEAR	REASON FOR ISSUE	28							
					07							
					26							
					P							
A = APPROVAL C = CONSTRUCTION N = COORDINATION				P = PRELIMINARY T = TENDER								

DISTRIBUTION				NUMBER OF COPIES							
WWW.EDG.NET.AU				1E							
BSPN ARCHITECTURE				1E							
P = PRINT T = TRACING D = DISC E = EMAIL F = FAX											


DOCUMENTS		REVISION									
C3811a-E01.dwg	LEGEND	A									
C3811a-E02.dwg	NOTES	A									
C3811a-E03.dwg	GROUND LEVEL & LEVEL 1 PLANS	A									
C3811a-E04.dwg	LEVEL 2 PLANS	A									
C3811a-0001.xls	CONTRACT DOCUMENT SCHEDULE	A									
C3811a-0002.xls	EQUIPMENT SCHEDULE										
C3811a-0003.xls	STANDARDS SCHEDULE										
C3811a-0004.xls	UNIT RATES SCHEDULE										
C3811a-0005.xls	TENDER BREAK-UP SCHEDULE										
C3811a-0006.xls	INFO TO BE SUBMITTED BY SUBCONTRACTOR										
C3811a-0007.xls	LIGHTING CONTROL SCHEDULE										
C3811a-0008.xls	ABBREVIATIONS SCHEDULE										
C3811a-0009.xls	DISTRIBUTION BOARD DB## SCHEDULE										
C3811a-0001.zip	FITTING & OUTLET DATASHEETS										

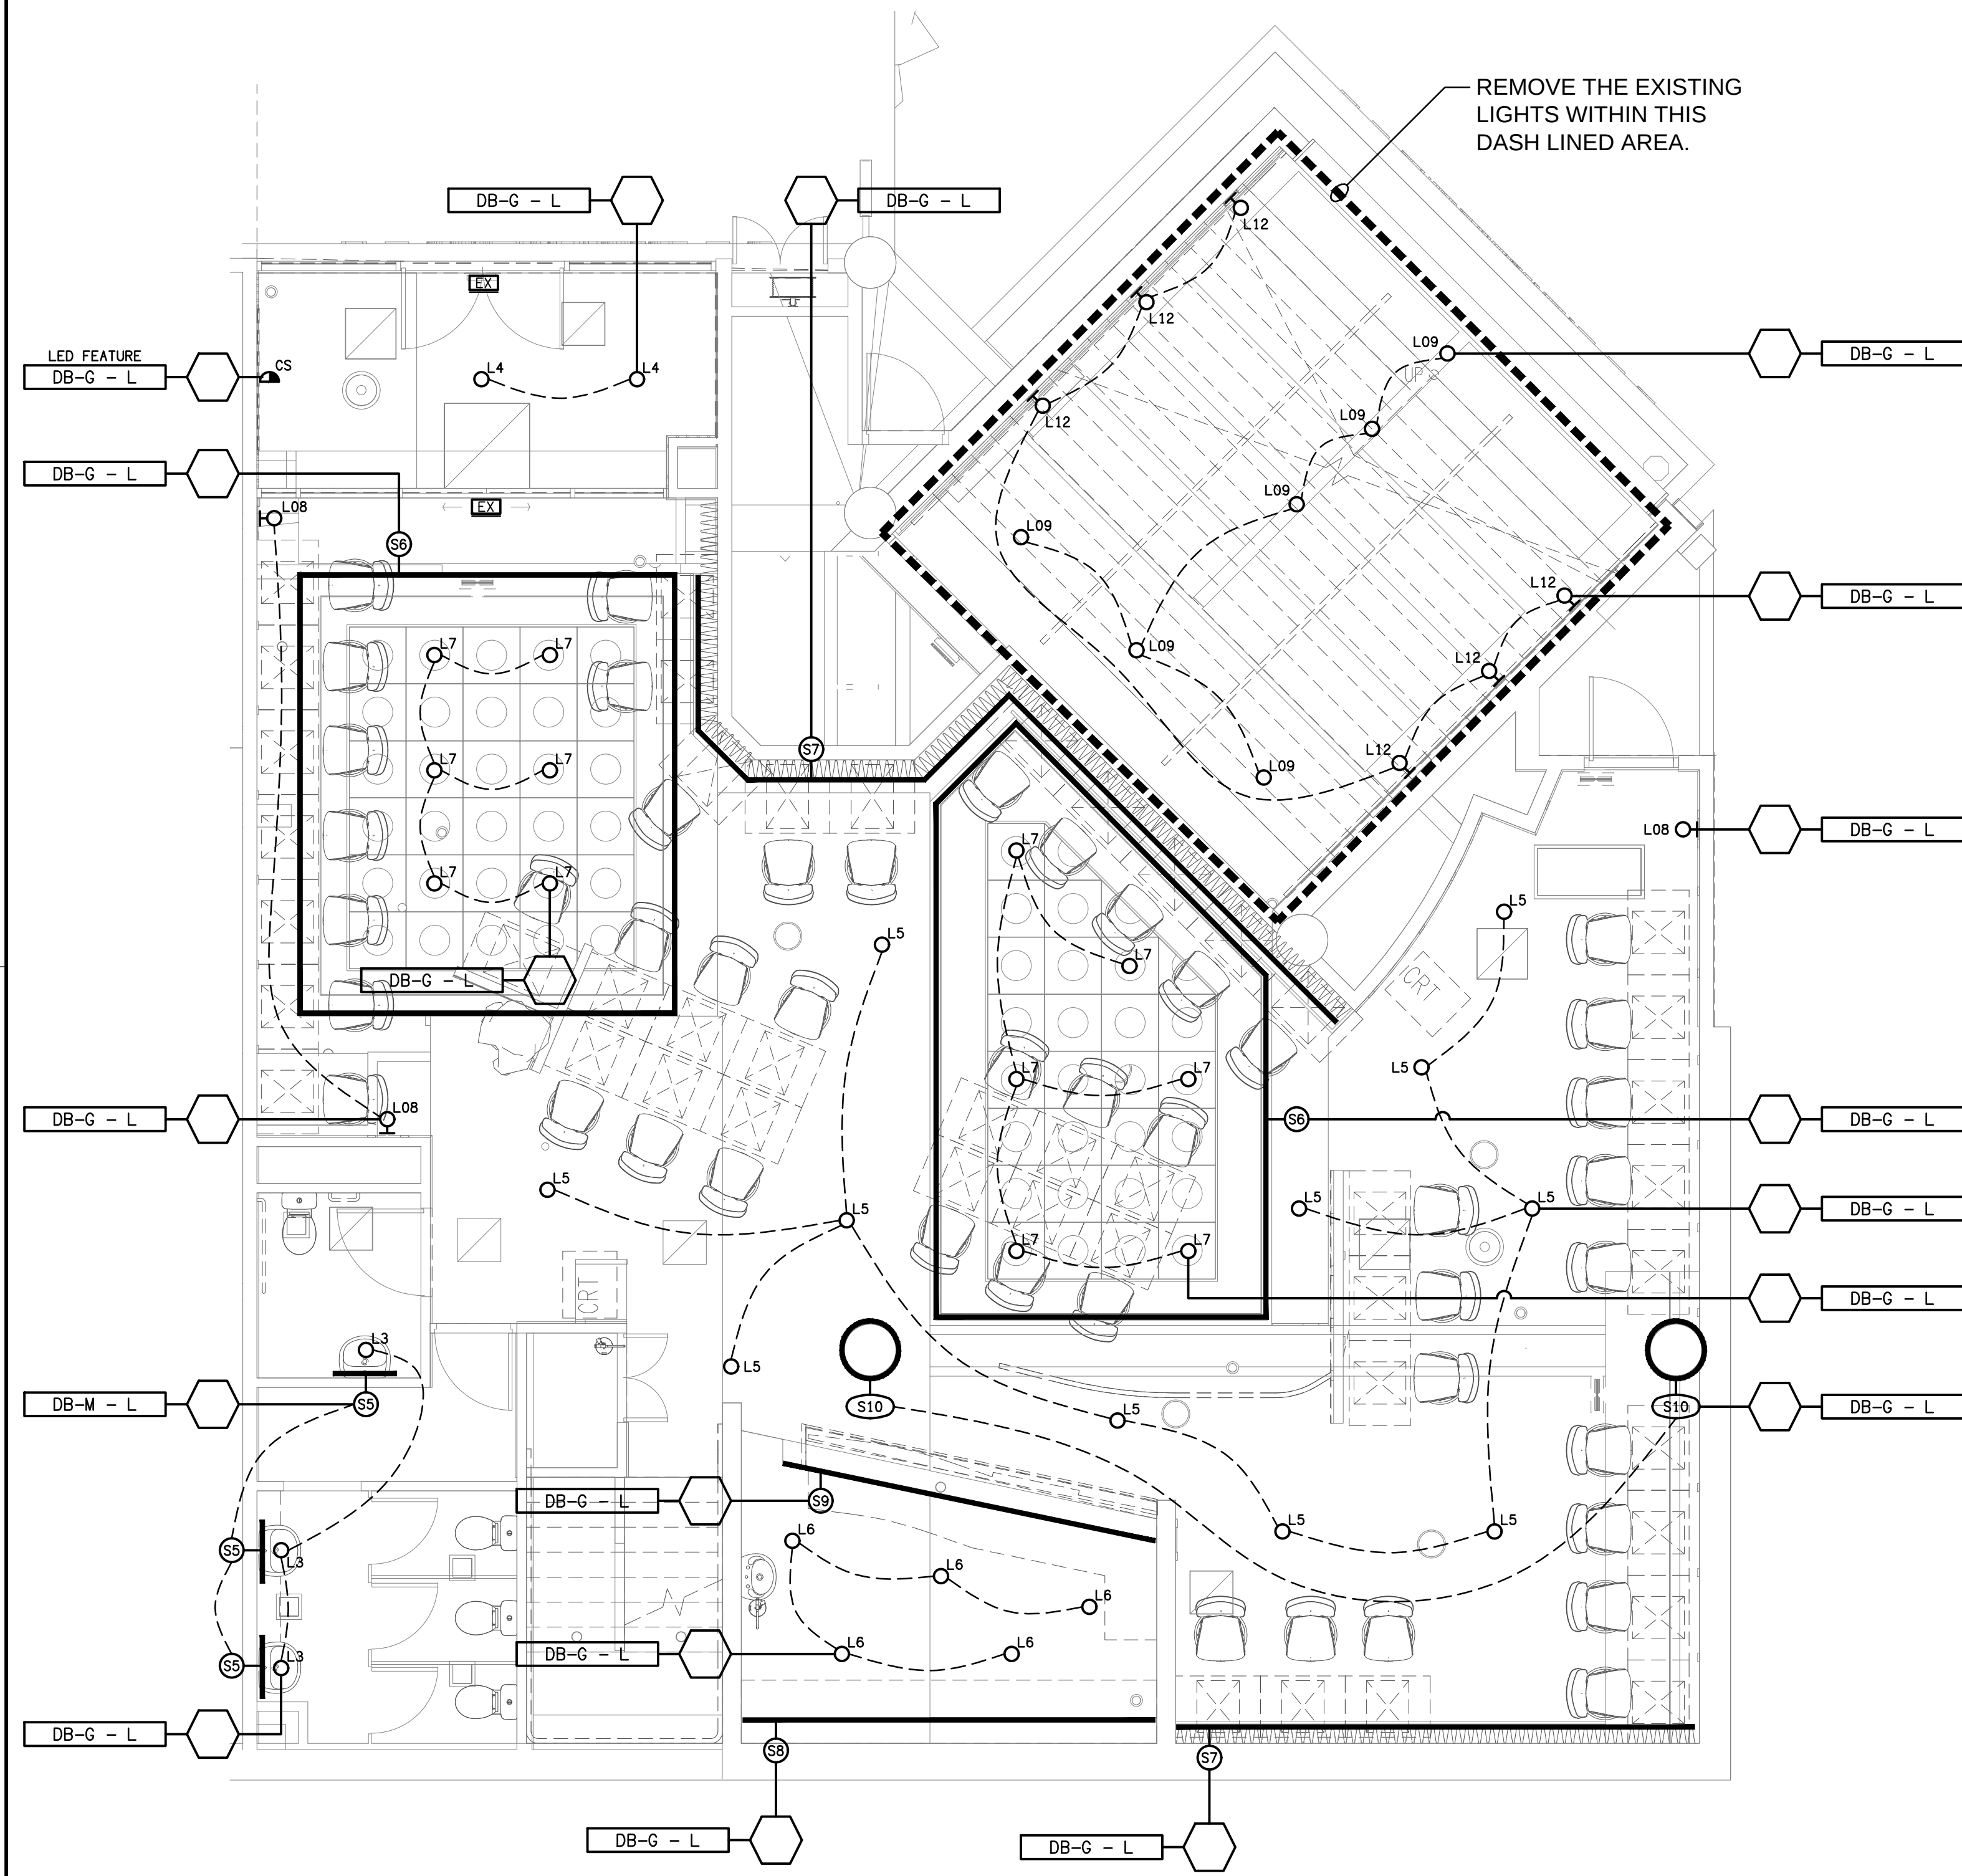


GROUND LEVEL
REFLECTED CEILING PLAN
SCALE 1: 50

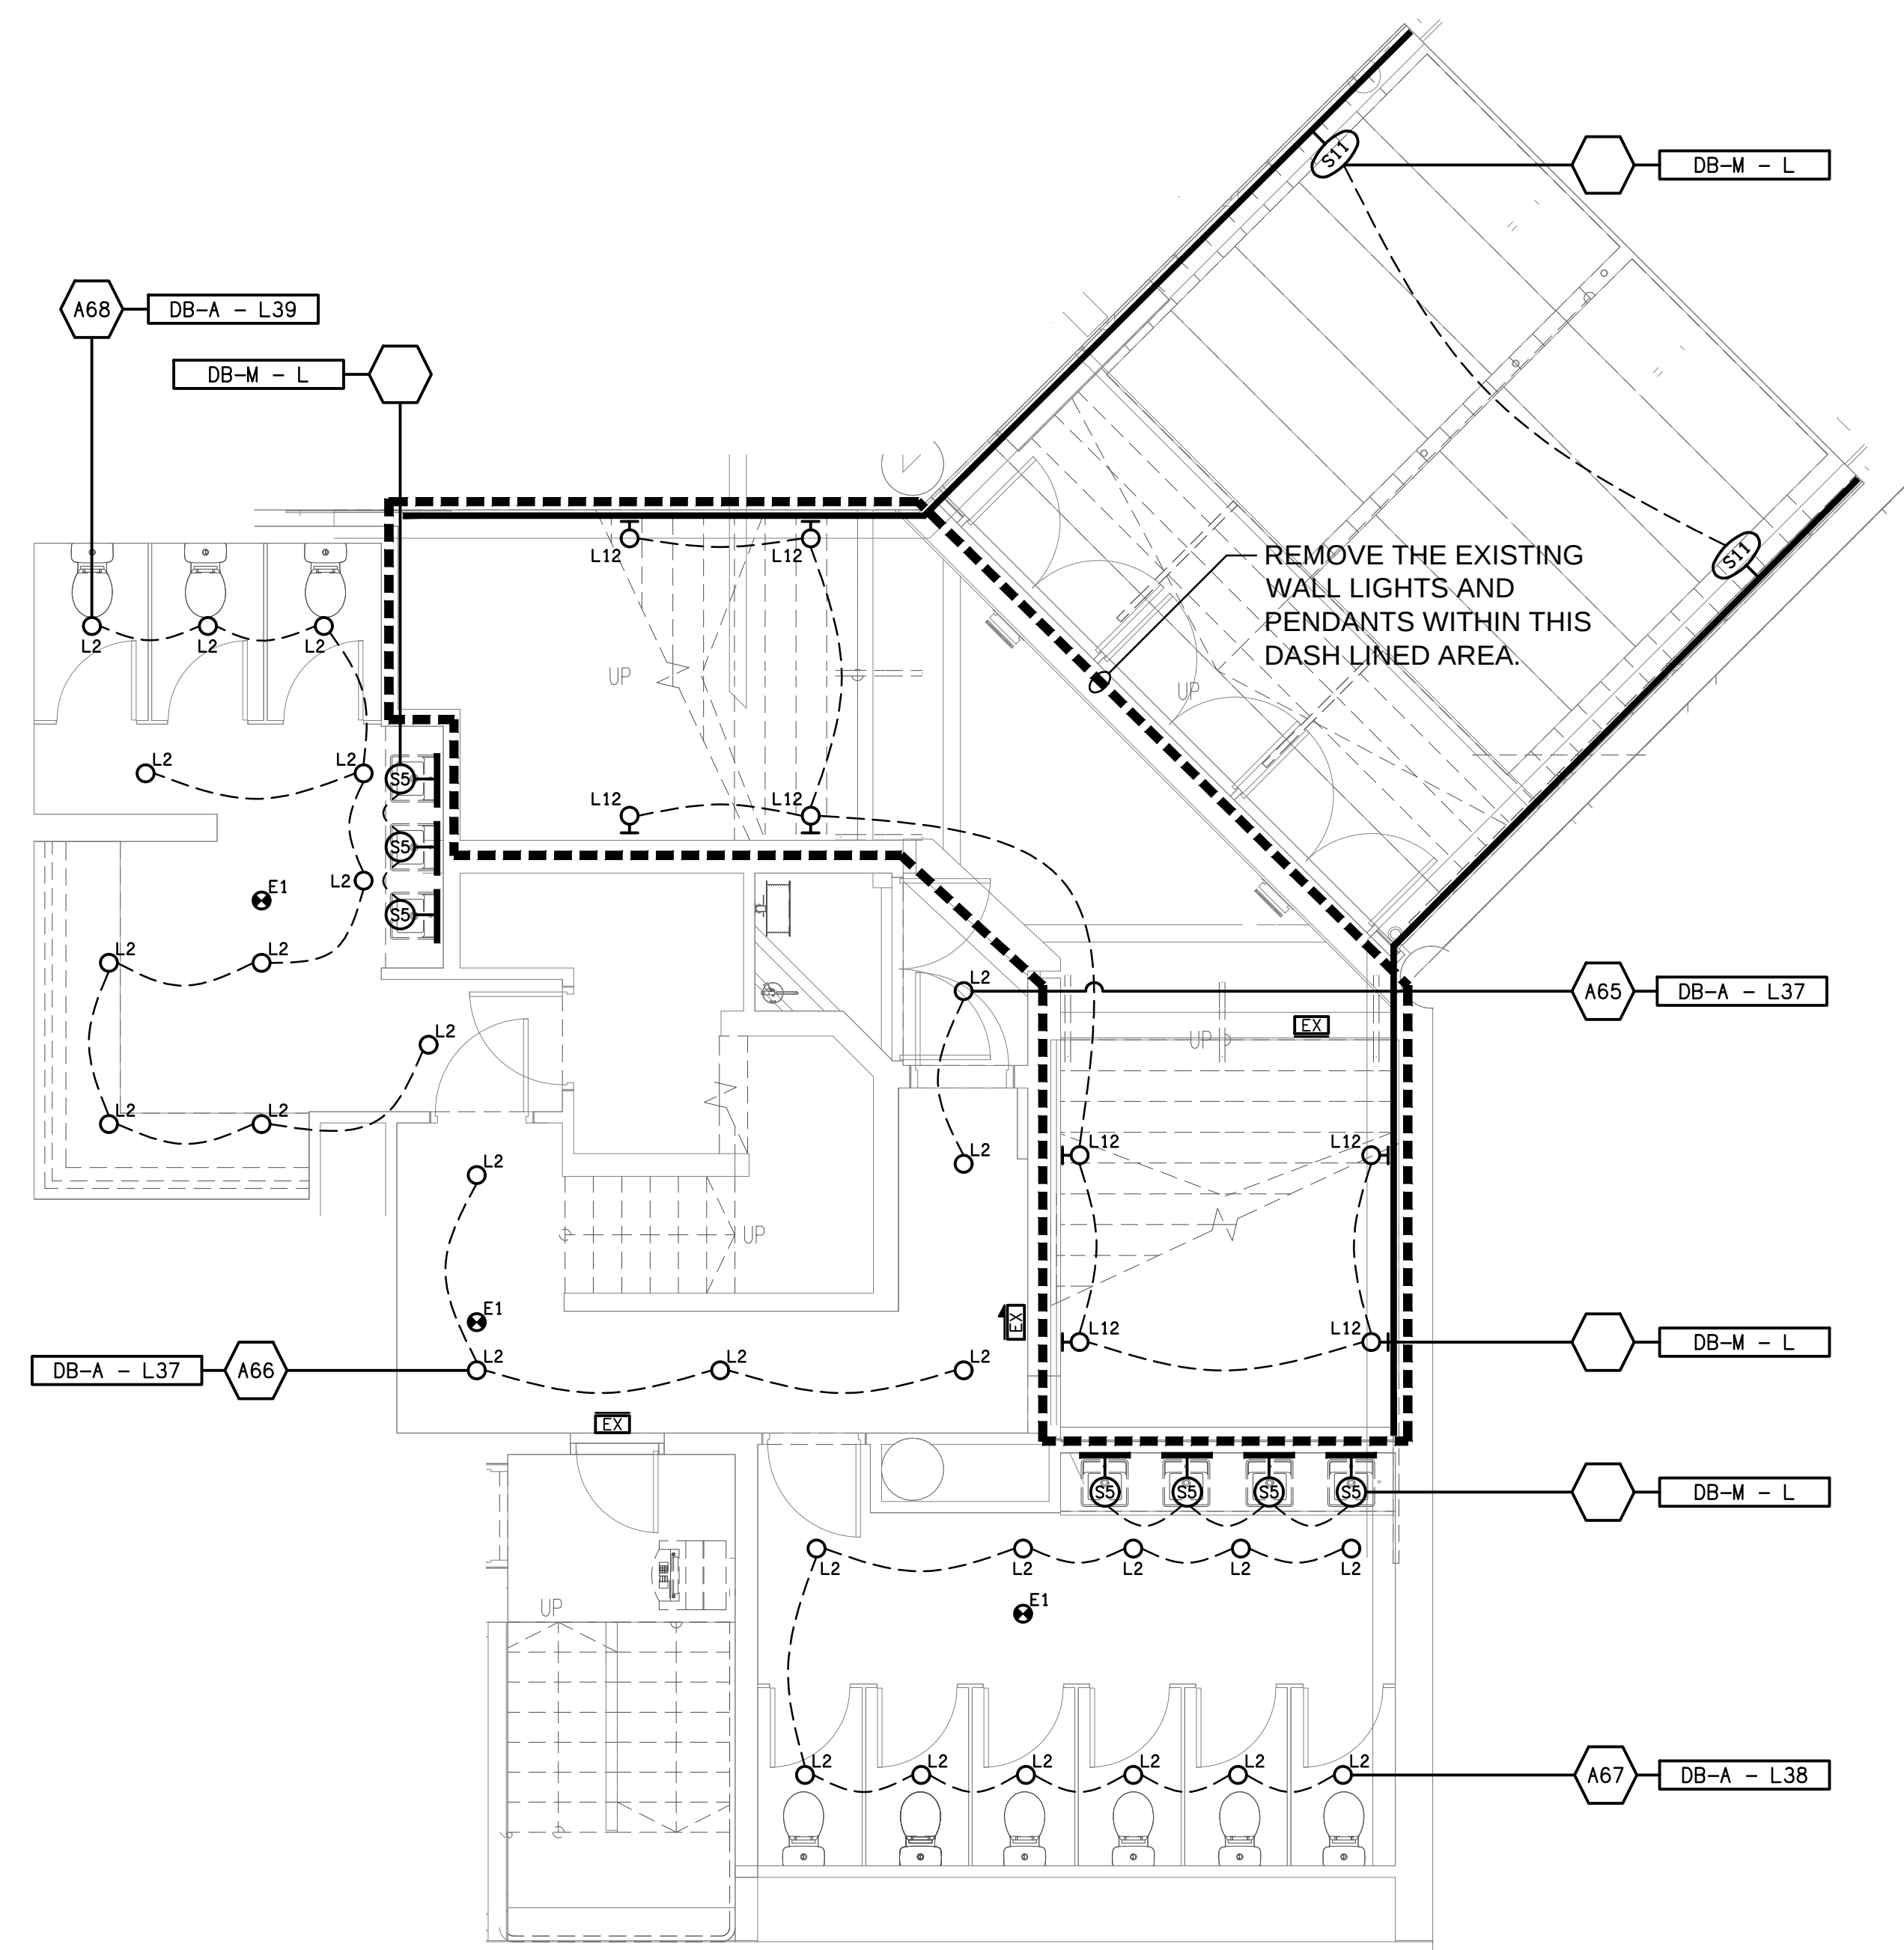


LEVEL 1
REFLECTED CEILING PLAN
SCALE 1: 50

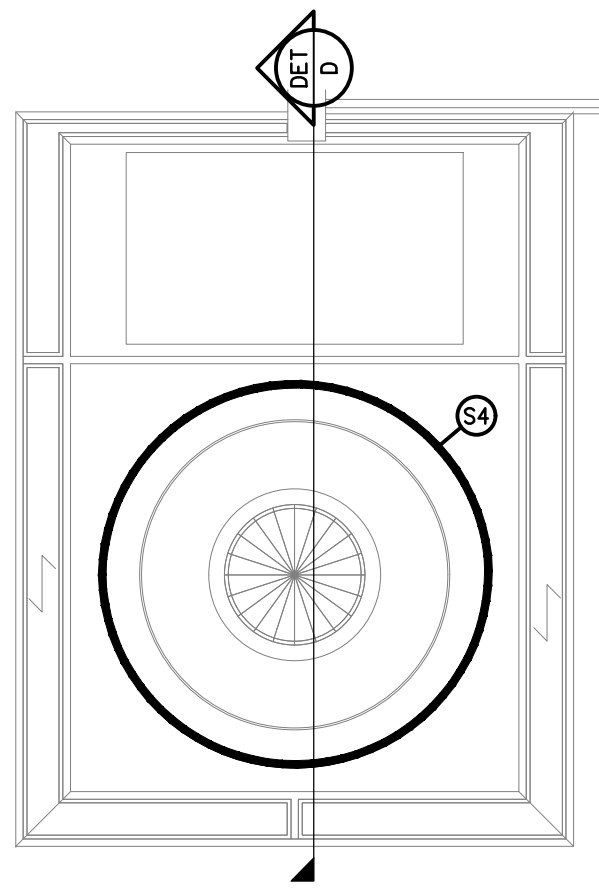


DETAIL C
DART BOARD LED ELEVATION
SCALE 1: 20

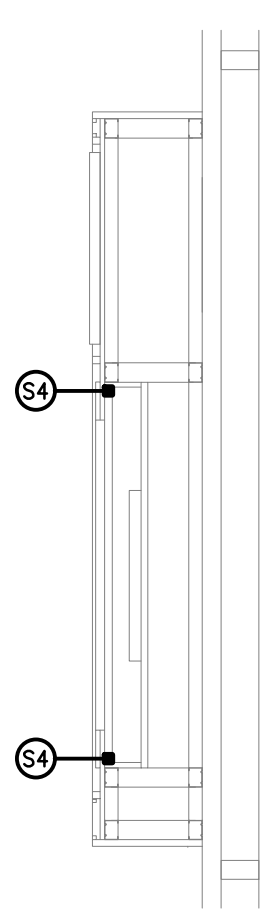


DETAIL D
DART BOARD LED SECTION
SCALE 1: 20

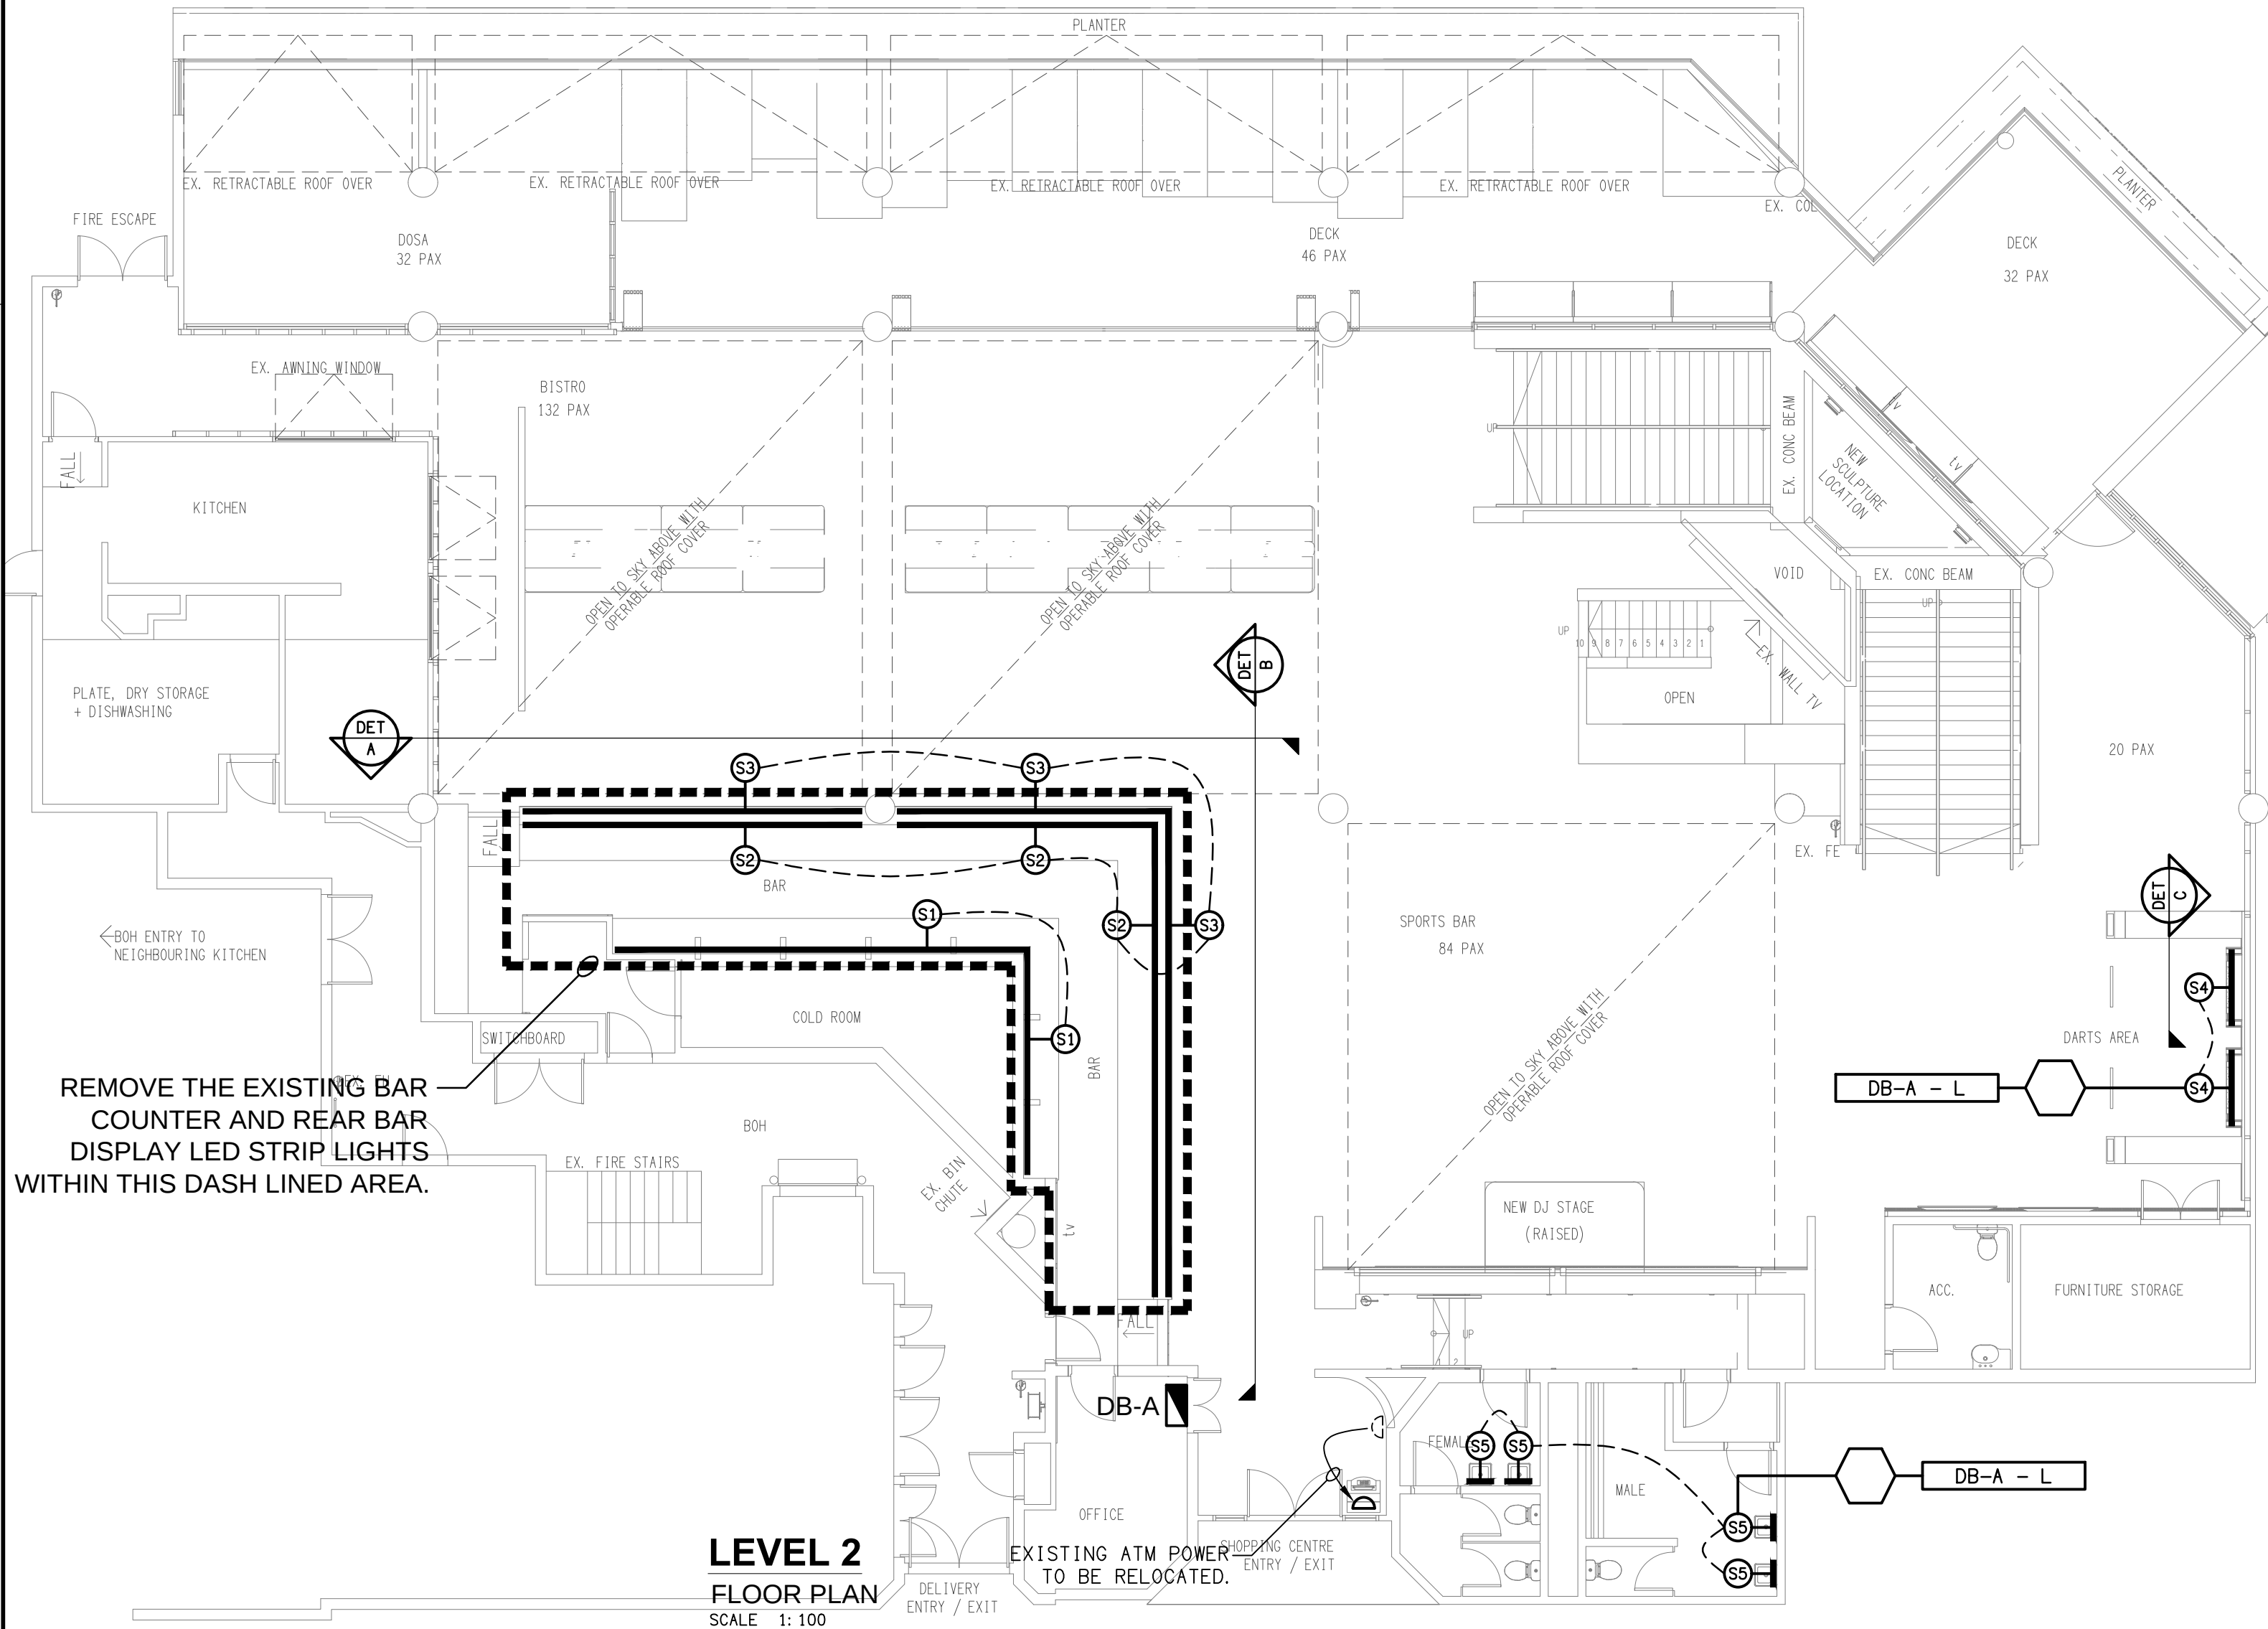


LEVEL 2
FLOOR PLAN
SCALE 1: 100

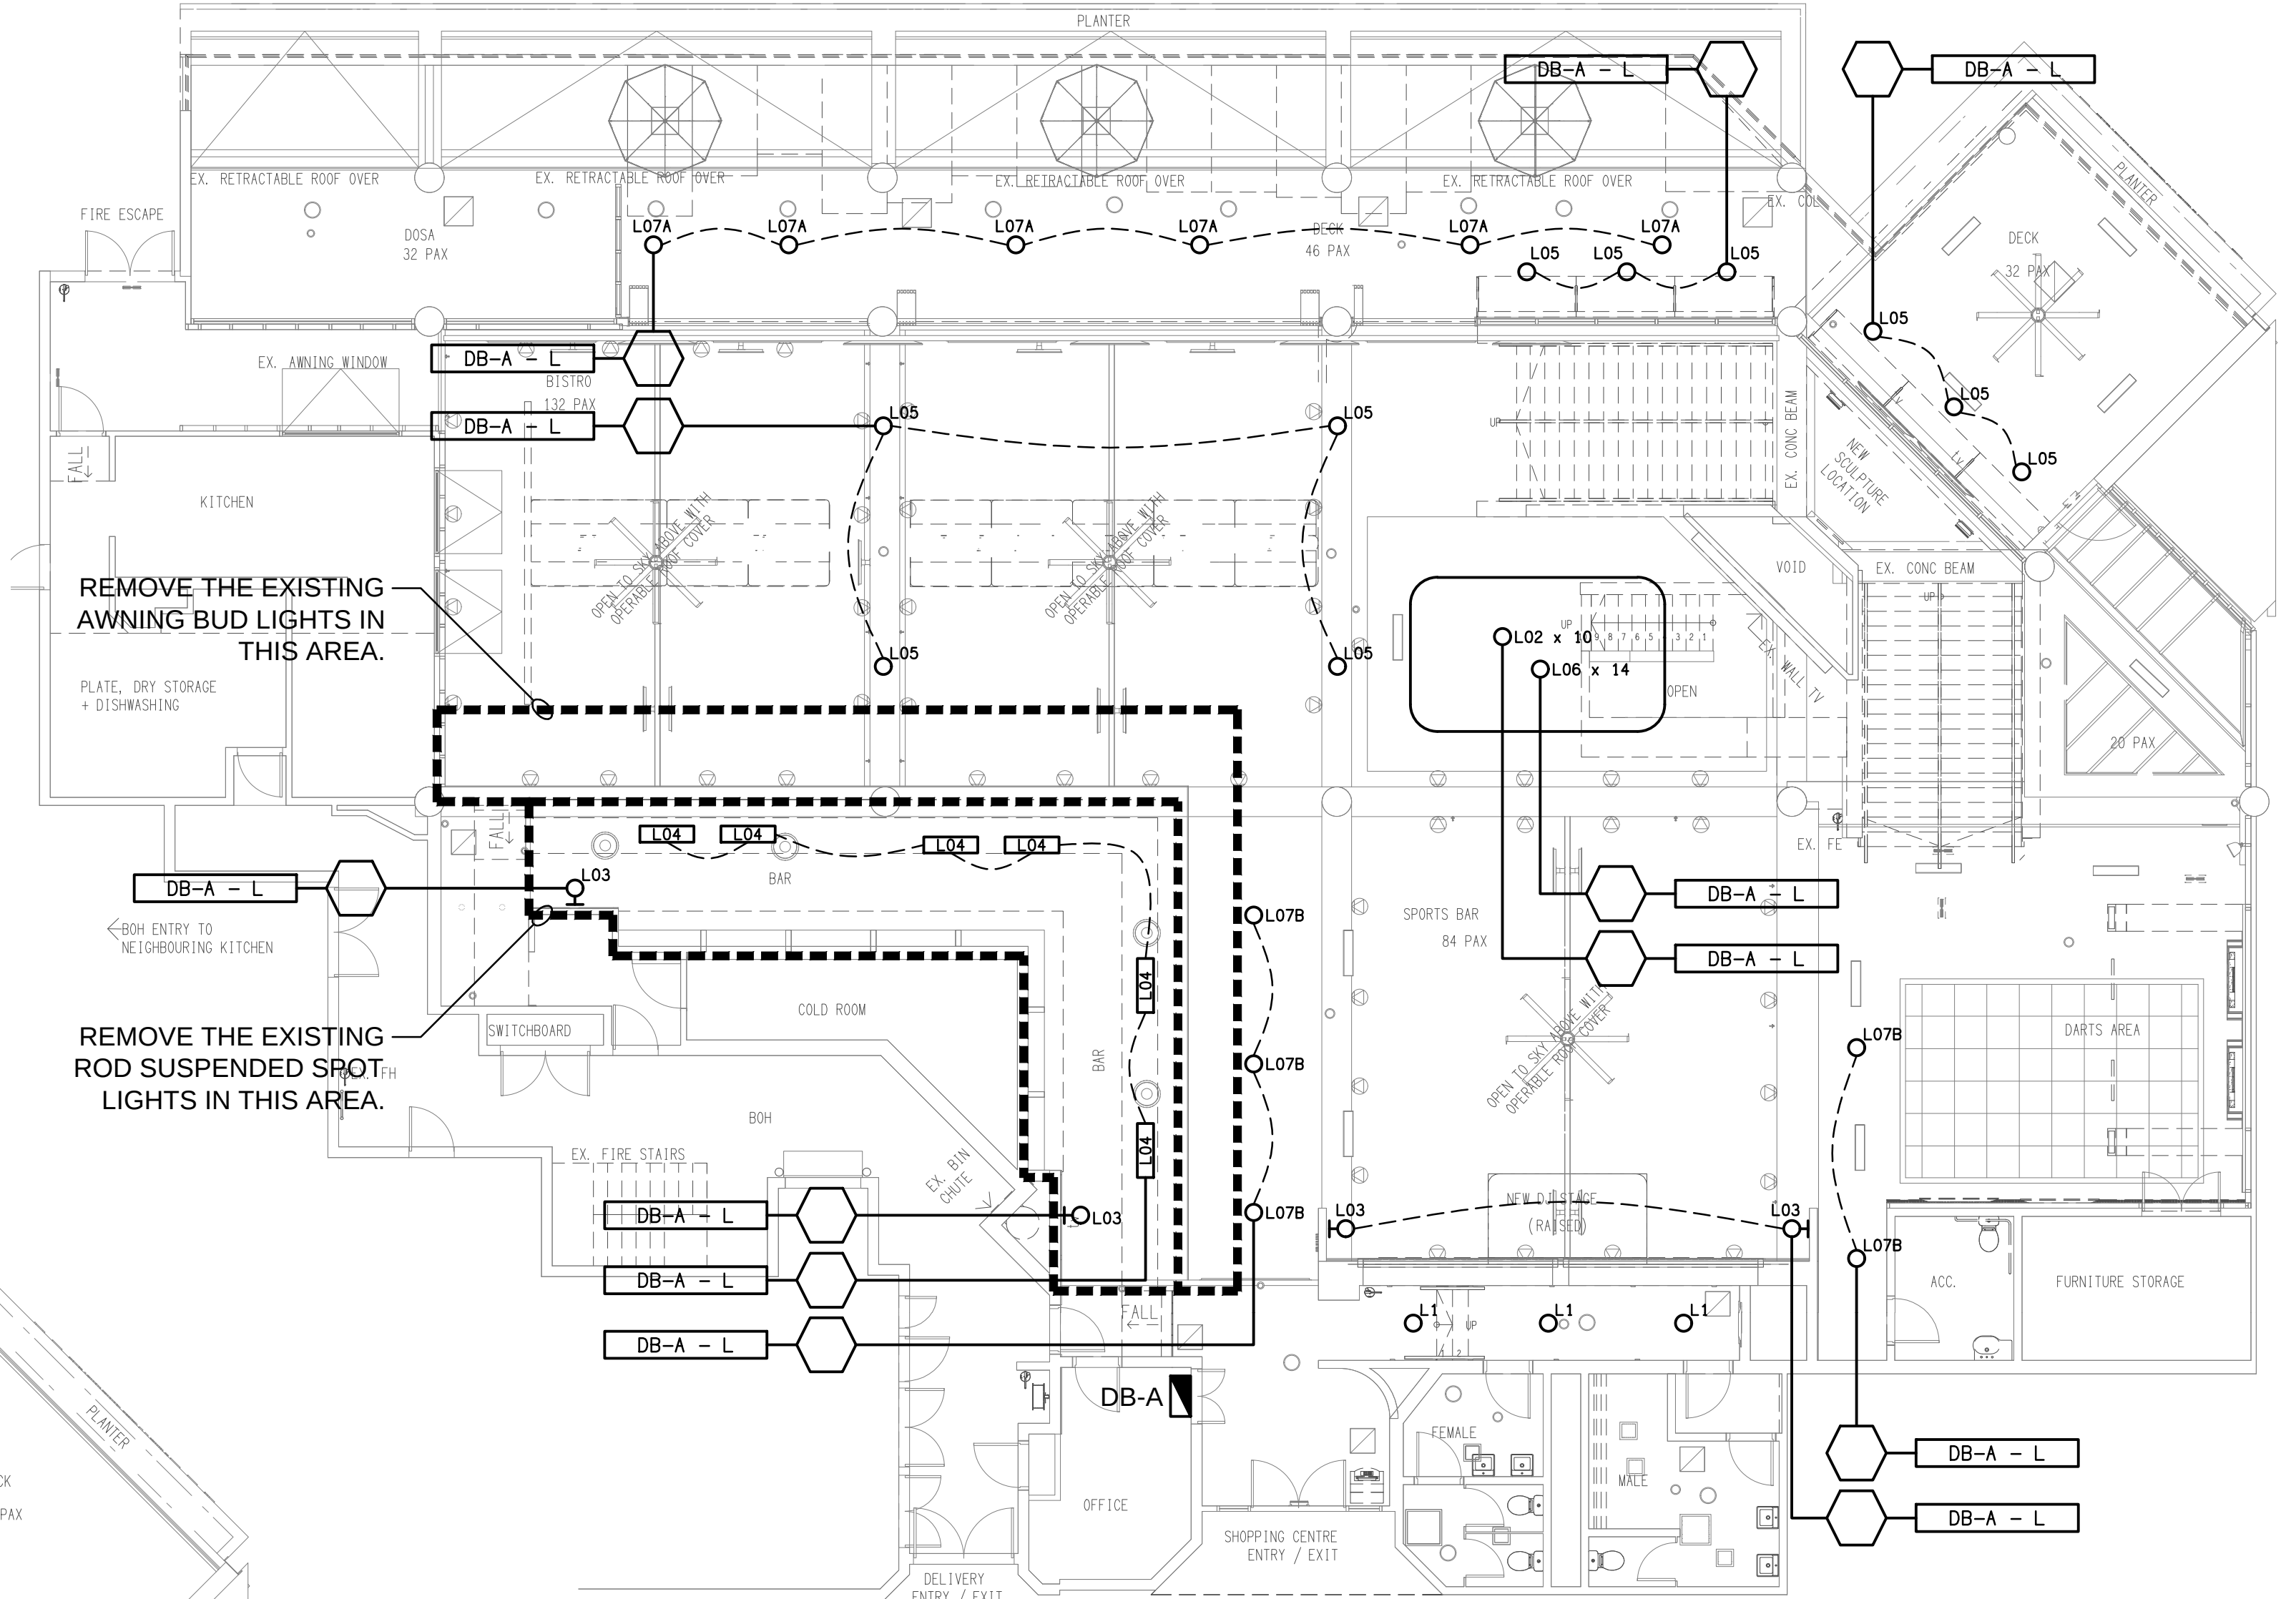

LEVEL 2
REFLECTED CEILING PLAN
SCALE 1: 100

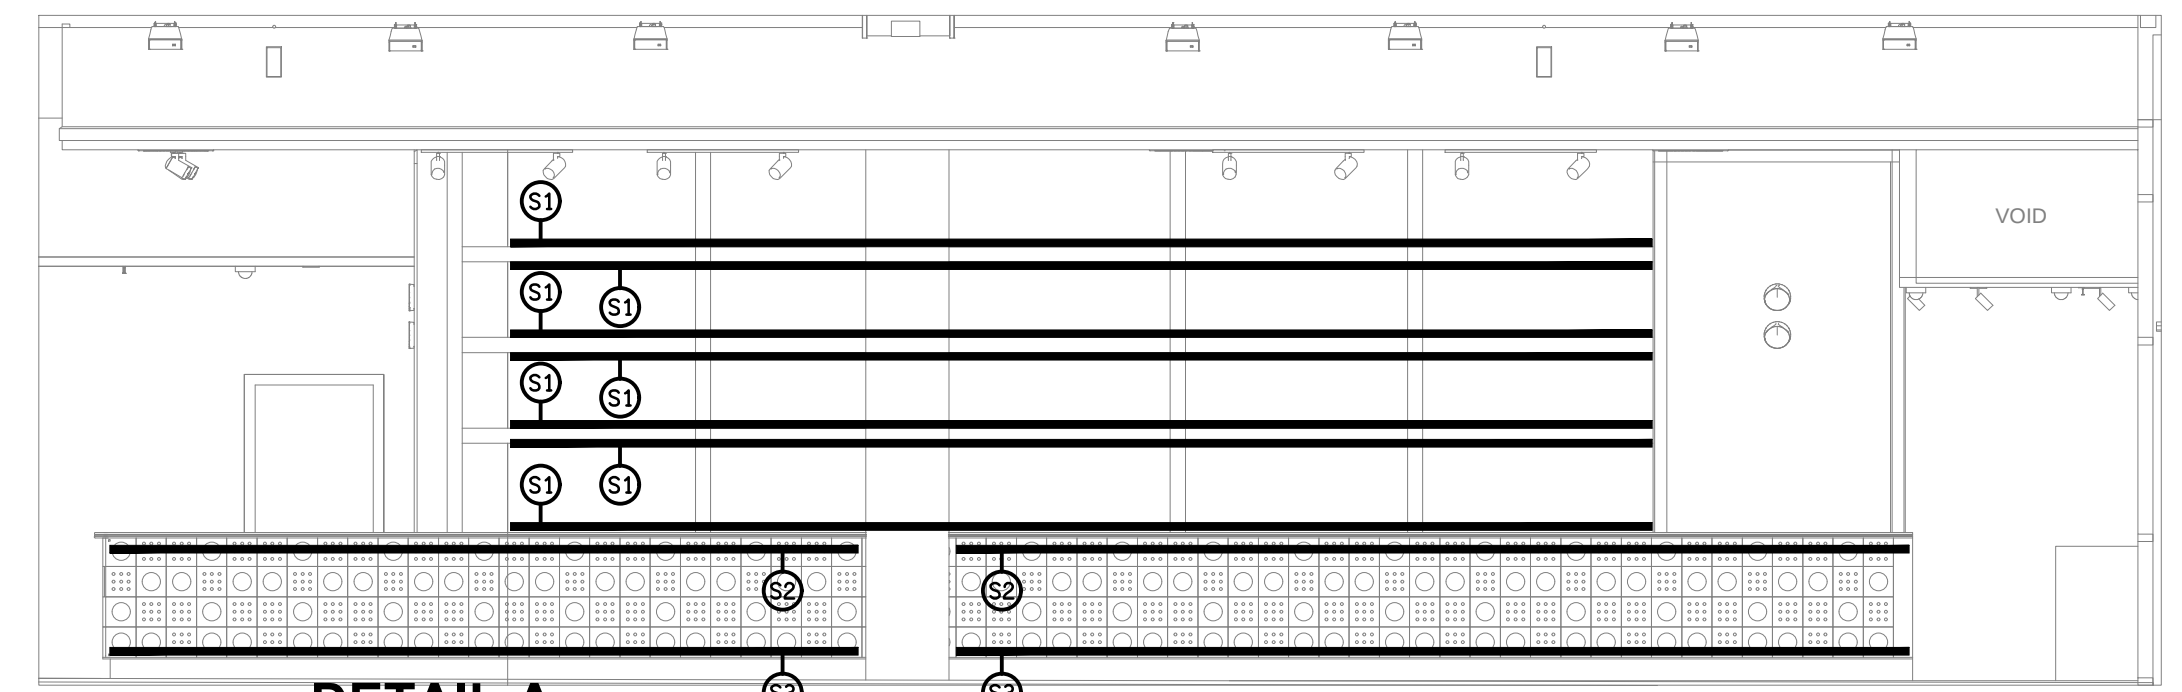

DETAIL A
MAIN BAR ELEVATION 1
SCALE 1: 50

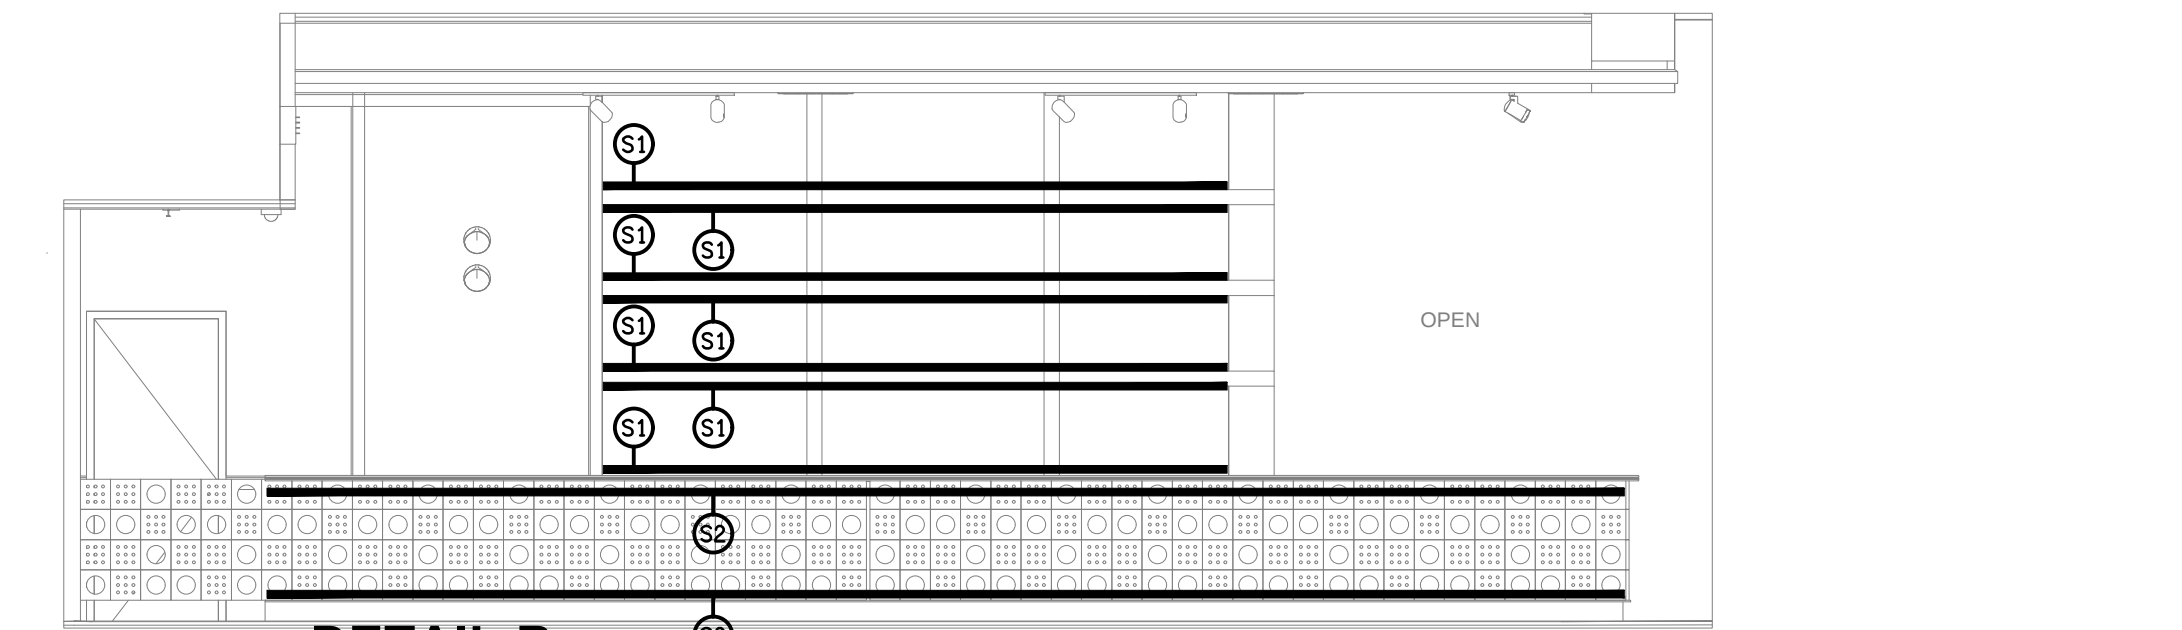

DETAIL B
MAIN BAR ELEVATION 2
SCALE 1: 50