


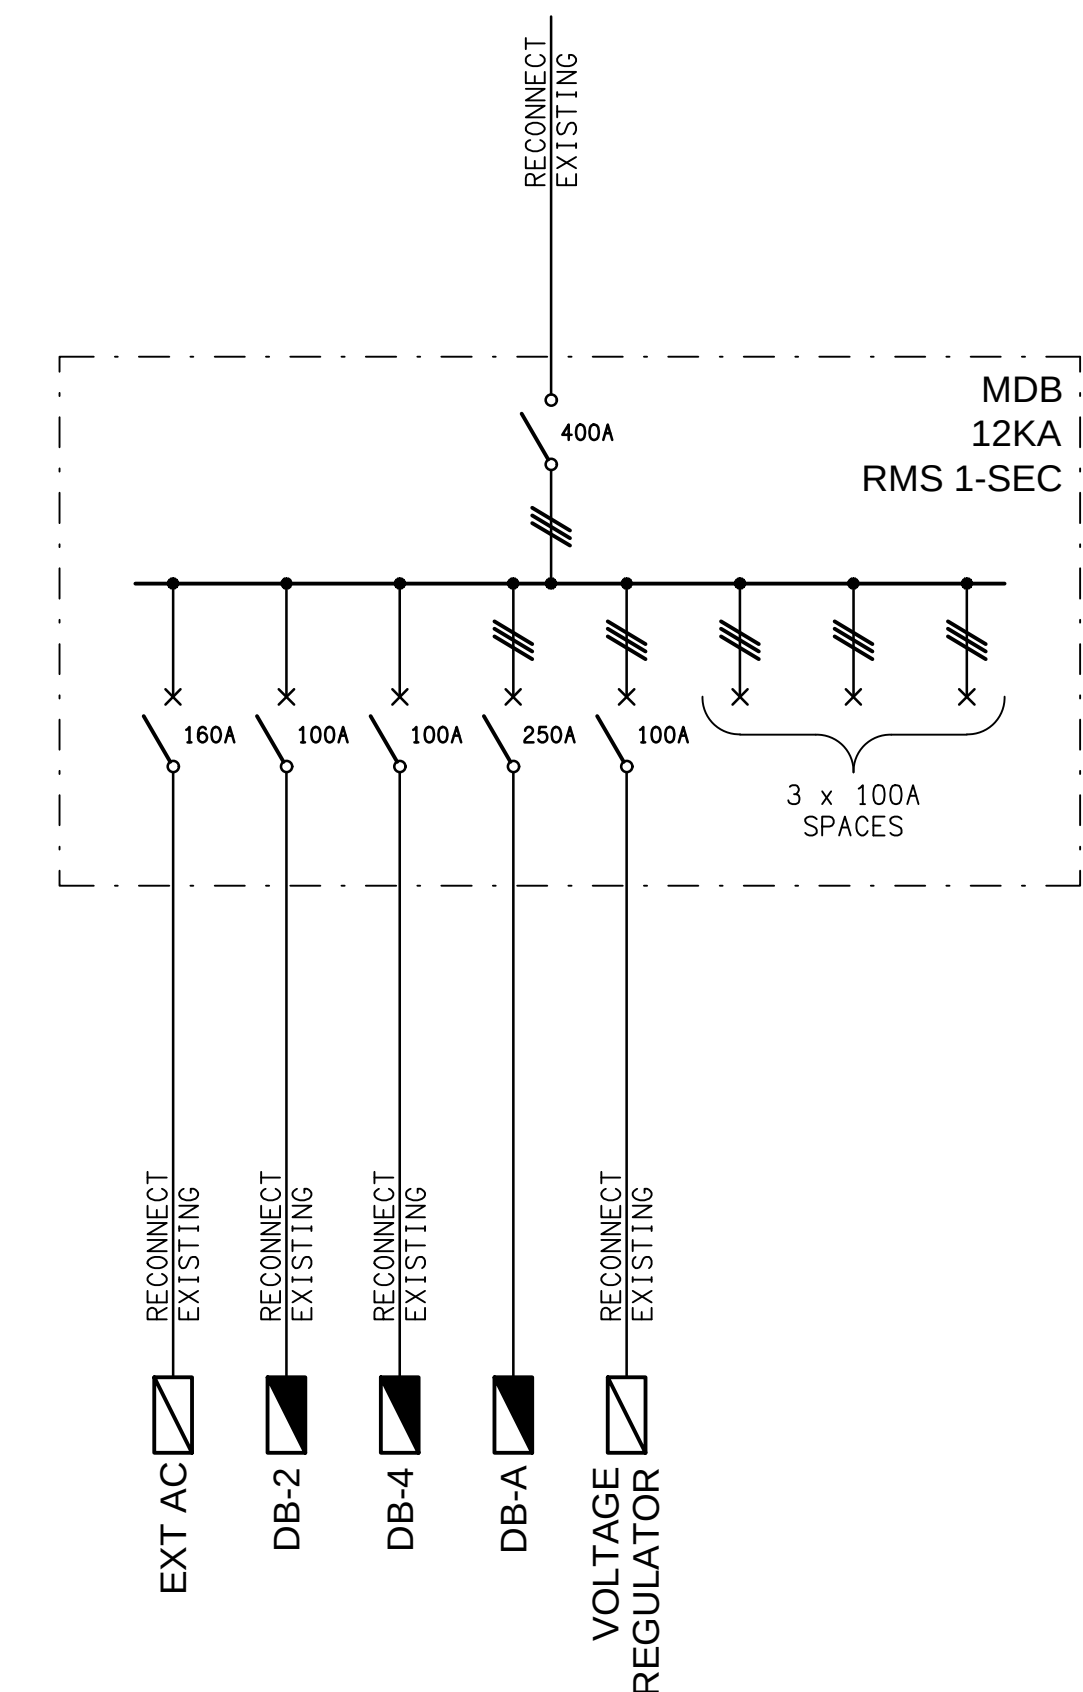

ELECTRICAL DESIGN GROUP BRISBANE PTY LTD ACN 092 710 793 TRADING AS: ELECTRICAL DESIGN GROUP	THE COPYRIGHT OF THIS DRAWING REMAINS THE PROPERTY OF THE ELECTRICAL DESIGN GROUP. USE FIGURED DIMENSIONS IN PREFERENCE TO SCALE. ALL DIMENSIONS TO BE VERIFIED ONSITE.		 ELECTRICAL DESIGN GROUP ELECTRICAL BUILDING SERVICES CONSULTANTS BRISBANE GOLD COAST P.O.Box 15, Sherwood Q.4075 Phone: (07) 3278 4375 Email: brisbane@edg.net.au Web: www.edg.net.au	PROJECT: CAPTAIN COOK TAVERN, KIPPA RING	DRAWING: ELECTRICAL SERVICES FLOOR PLAN			
				PENINSULA FAIR SHOPPING CENTRE, ANZAC AVE, KIPPA RING	SCALE: 1:100			
				AT A1	<table border="1"> <tr> <td data-bbox="2451 1944 2650 1950"> PROJECT NO: C3813a </td> <td data-bbox="2650 1944 2792 1950"> DRAWING NO: E03 </td> <td data-bbox="2792 1944 2878 1950"> REVISION: A </td> </tr> </table>	PROJECT NO: C3813a	DRAWING NO: E03	REVISION: A
PROJECT NO: C3813a	DRAWING NO: E03	REVISION: A						