


**NOTE:**

REFER TO DRAWING C3813a-E05.dwg FOR THE  
ADDITIONAL JOINERY & WALL LIGHTING PLAN.

EXISTING LIGHT WITHIN THIS  
HATCHED AREA TO BE RETAINED  
AND RESUPPLIED FROM CIRCUIT  
DB-A - L?? CHANNEL ??

EXISTING LIGHT WITHIN THIS  
HATCHED AREA TO BE RETAINED  
AND RESUPPLIED FROM CIRCUIT  
DB-A - L?? CHANNEL ??

EXISTING LIGHTING WITHIN THIS DASH  
LINED AREA ARE TO BE REMOVED,  
UNLESS NOTED OTHERWISE.

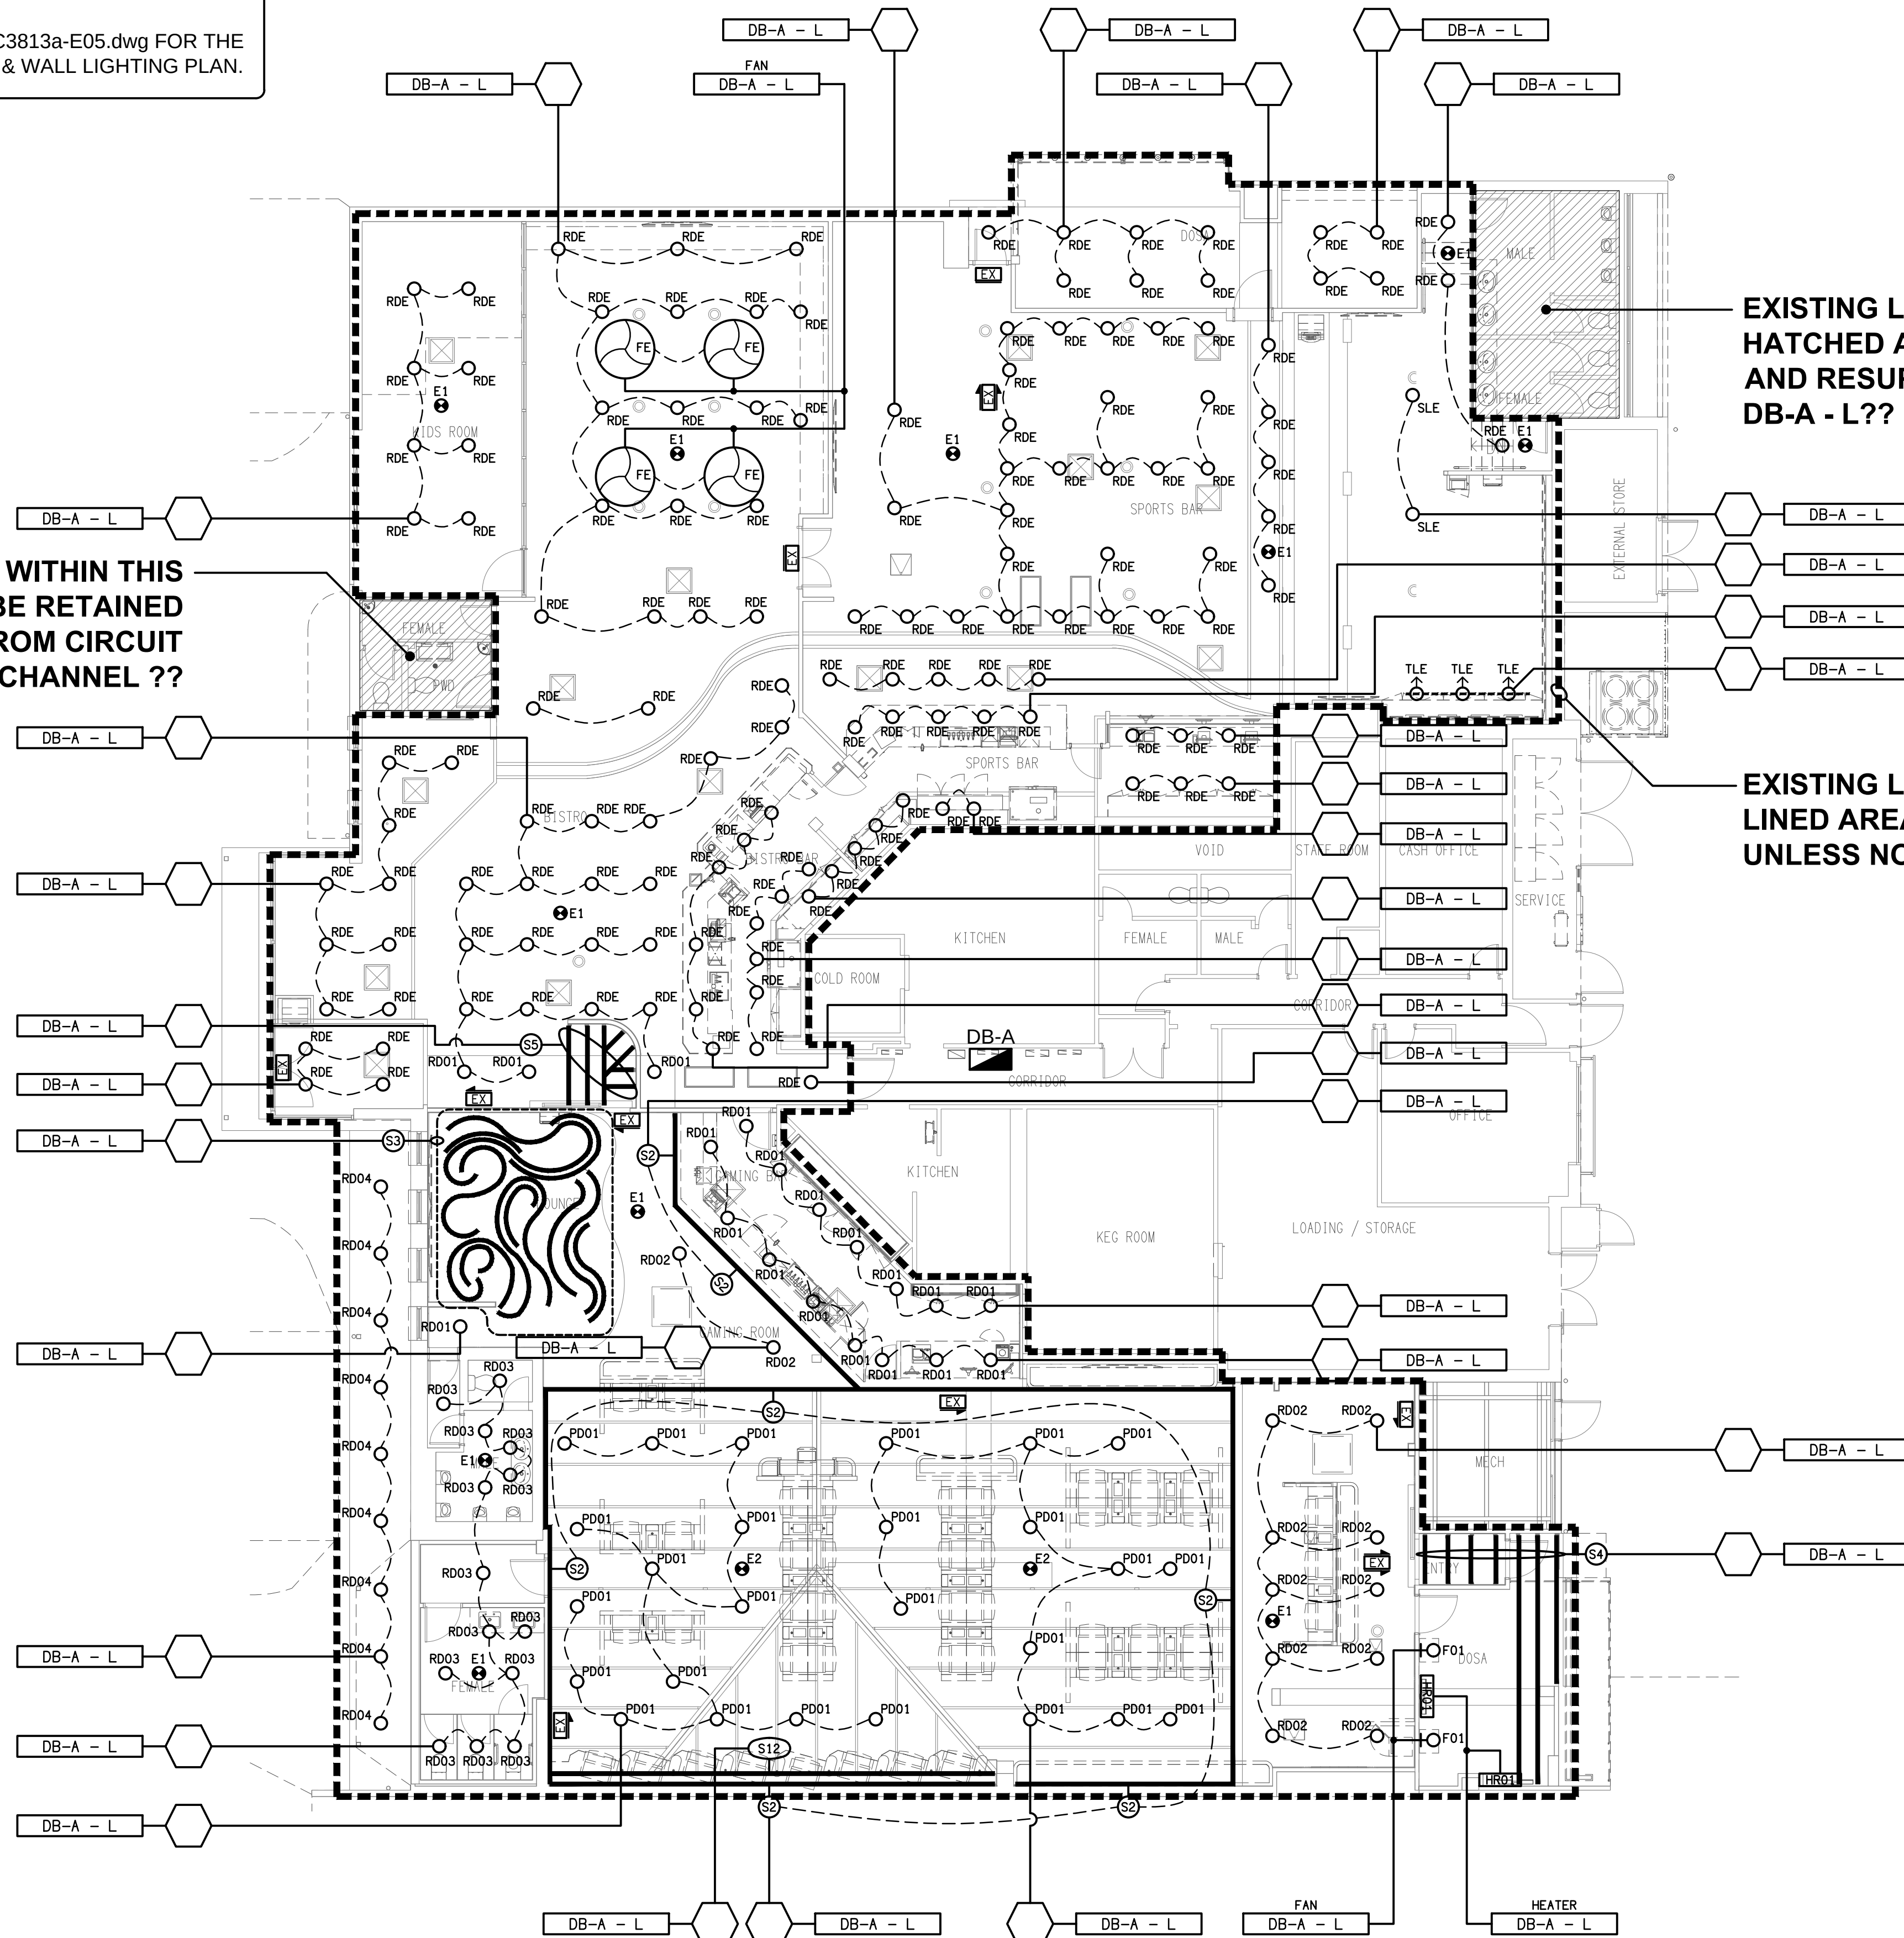

ELECTRICAL DESIGN GROUP BRISBANE  
PTY LTD  
ACN 092 710 793  
TRADING AS:  
ELECTRICAL DESIGN GROUP

THE COPYRIGHT OF THIS DRAWING  
REMAINS THE PROPERTY OF THE  
ELECTRICAL DESIGN GROUP.  
USE FIGURED DIMENSIONS  
IN PREFERENCE TO SCALE.  
ALL DIMENSIONS TO BE  
VERIFIED ONSITE.

**ELECTRICAL DESIGN GROUP**  
ELECTRICAL BUILDING SERVICES CONSULTANTS  
BRISBANE GOLD COAST

P.O. Box 15, Sherwood Q.4075  
Phone: (07) 3278 4375  
Email: brisbane@edg.net.au  
Web: www.edg.net.au

PROJECT:  
CAPTAIN COOK TAVERN, KIPPA RING

PENINSULA FAIR SHOPPING CENTRE, ANZAC AVE, KIPPA RING

|      |              |            |
|------|--------------|------------|
| A    | PRELIMINARY  | 18/08/2026 |
| REV. | DESCRIPTION: | DATE:      |

DRAWING:  
**ELECTRICAL SERVICES  
REFLECTED CEILING PLAN**

SCALE:  
1:100

AT A1

PROJECT NO:  
**C3813a**

DRAWING NO:  
**E04**

REVISION:  
**A**