

 
LEGEND

- MSB  EXISTING MAIN SWITCH BOARD (MSB) TO REMAIN AS IS.
- DB-B  NEW DISTRIBUTION BOARD DB-B.
- DB-G  EXISTING DISTRIBUTION BOARD DB-G TO BE MODIFIED.
-  SWITCHBOARD / CONTROL PANEL NOT PROVIDED AS PART OF THE ELECTRICAL SUBCONTRACT.
-  SINGLE POWER OUTLET.
-  DOUBLE POWER OUTLET.
-  SINGLE PHASE ISOLATOR.
-  THREE PHASE ISOLATOR.
-  SIGNAGE CONNECTION.

 LIGHTING CONTROL SWITCHPANEL, TYPE x.

 CIRCUIT LINE.

 SWITCH LINE.

 POWER CIRCUIT DESIGNATION.
DENOTES DB AND CIRCUIT.

 LIGHTING CONTROL CHANNEL REFERENCE.

 ELECTRICAL EQUIPMENT AS NOTED.

 REFER TO DETAIL NOTED FOR THE AREA SHOWN HATCHED.
ADDITIONAL OUTLETS & FITTINGS MAY BE SHOWN ON DETAIL.

RD01  RD01: EXISTING RECESSED DOWNLIGHT TO BE REPLACED WITH NEW.

RD02  RD02: EXSTING RECESSED DOWNLIGHT TO BE REPLACED WITH NEW.

RD03  RD03: RECESSED DOWNLIGHT.

RDE  RDE: EXISTING RECESSED DOWNLIGHT TO BE REMOVED.

TL01  TL01: EXISTING TRACK AND TRACK LIGHT FITTING TO BE REPLACED WITH NEW.

TL02  TL02: TRACK LIGHT TO SUPPLEMENT THE TL01 LIGHT FITTINGS.

SLE  SLE: EXISTING SURFACE MOUNTED FITTING TO BE REMOVED.

S1  S1: CEILING PELMET STRIP LIGHT.

S2  S2: HAND BASIN MIRROR STRIP LIGHT.

S3  S3: COUNTER FRONT STRIP LIGHT.

S4  S4: ISLAND BAR SHELIVING STRIP LIGHT.

FS01  FL01: EXTERNAL FESTOON LIGHTS.

BL01  BL01: EXISTING TREE BUD LIGHTS TO BE REPLACED WITH NEW.

PD01  PD01: EXISTING DECORATIVE PENDANT TO BE REPLACED WITH NEW.

PD02  PD02: DECORATIVE PENDANT.

PD03  PD03: DECORATIVE PENDANT.


PD04  PD04: DECORATIVE PENDANT.

PD05  PD05: DECORATIVE PENDANT.


PD06  PD06: EXISTING POOL TABLE LIGHT TO BE RETAINED.

WL01  WL01: EXISTING WALL LIGHT TO BE REPLACED WITH NEW.

HRE  HRE: EXISTING HEATER TO BE RETAINED.

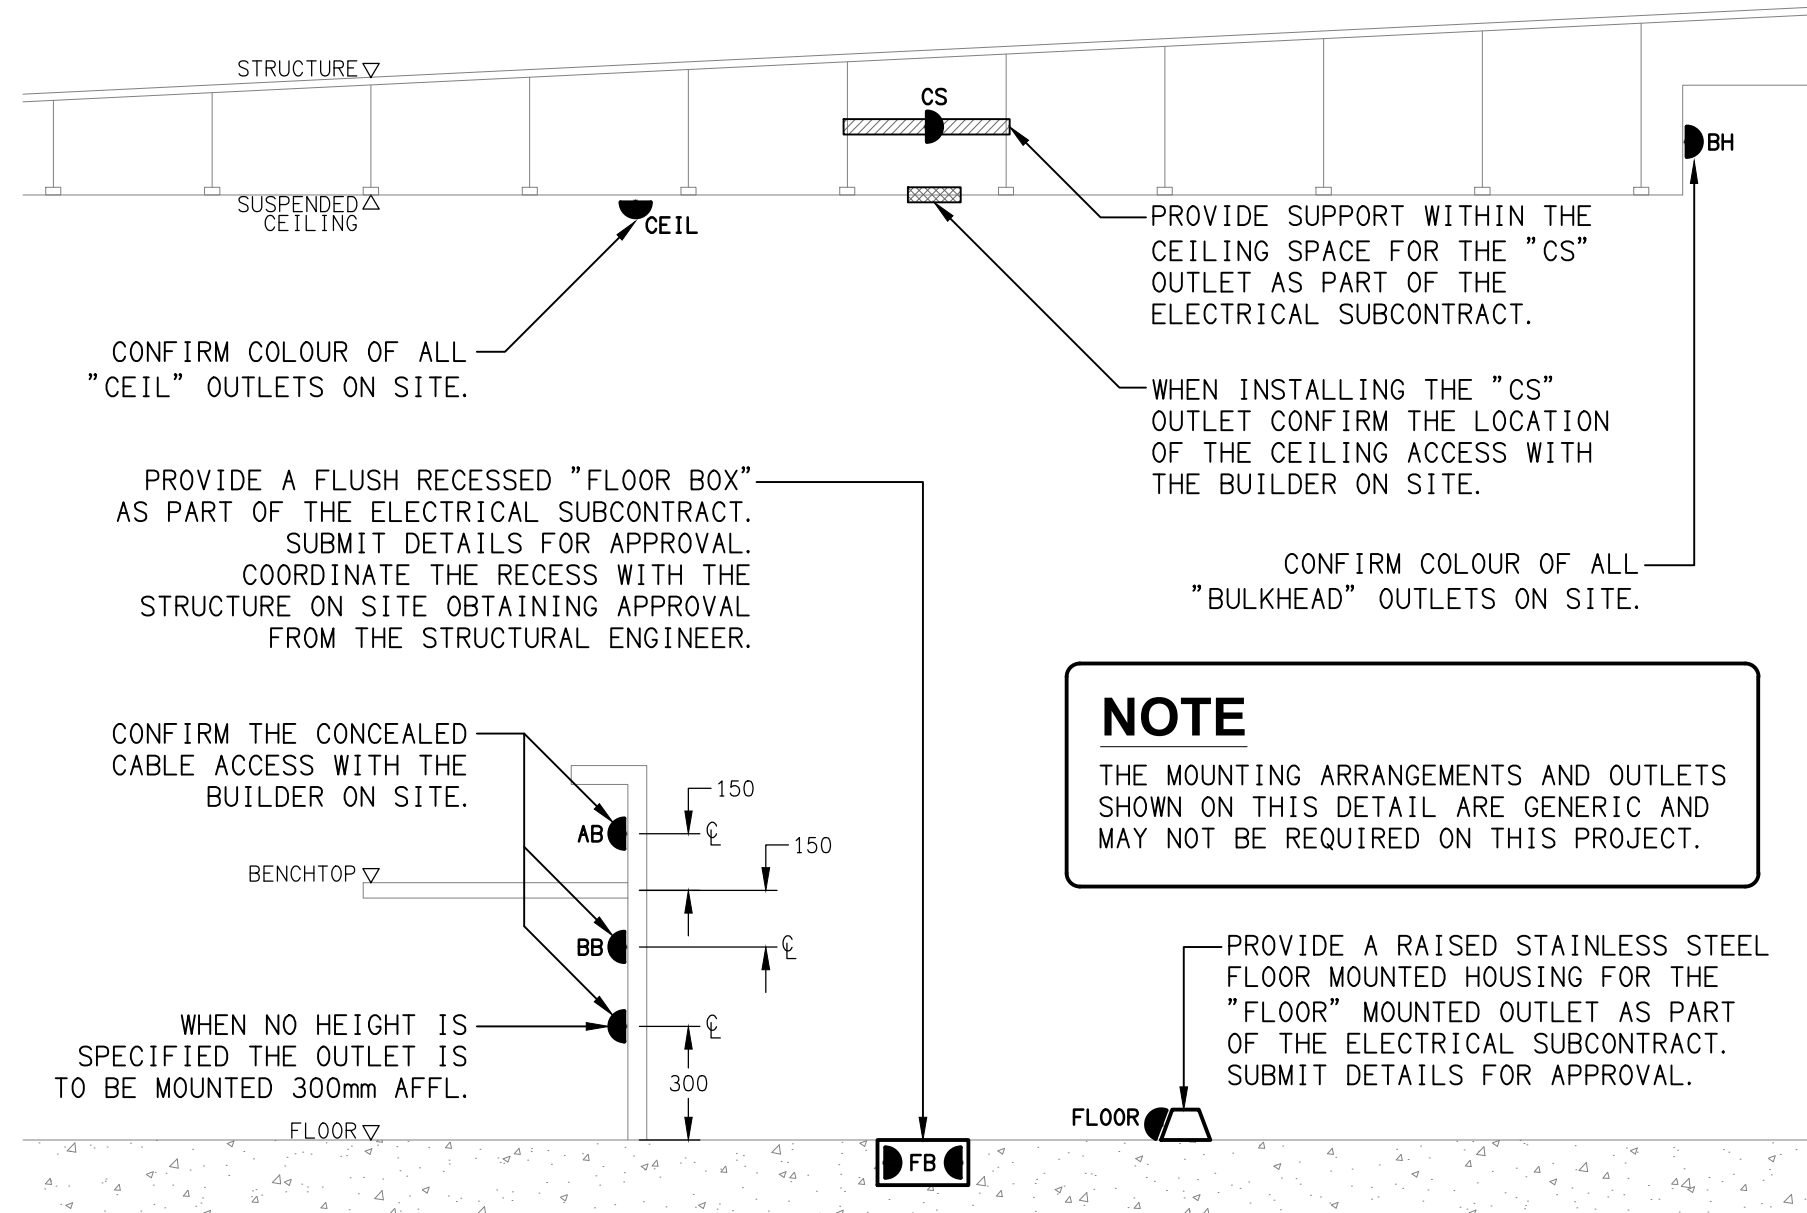

DETAIL
TYPICAL OUTLET MOUNTINGS
NOT TO SCALE

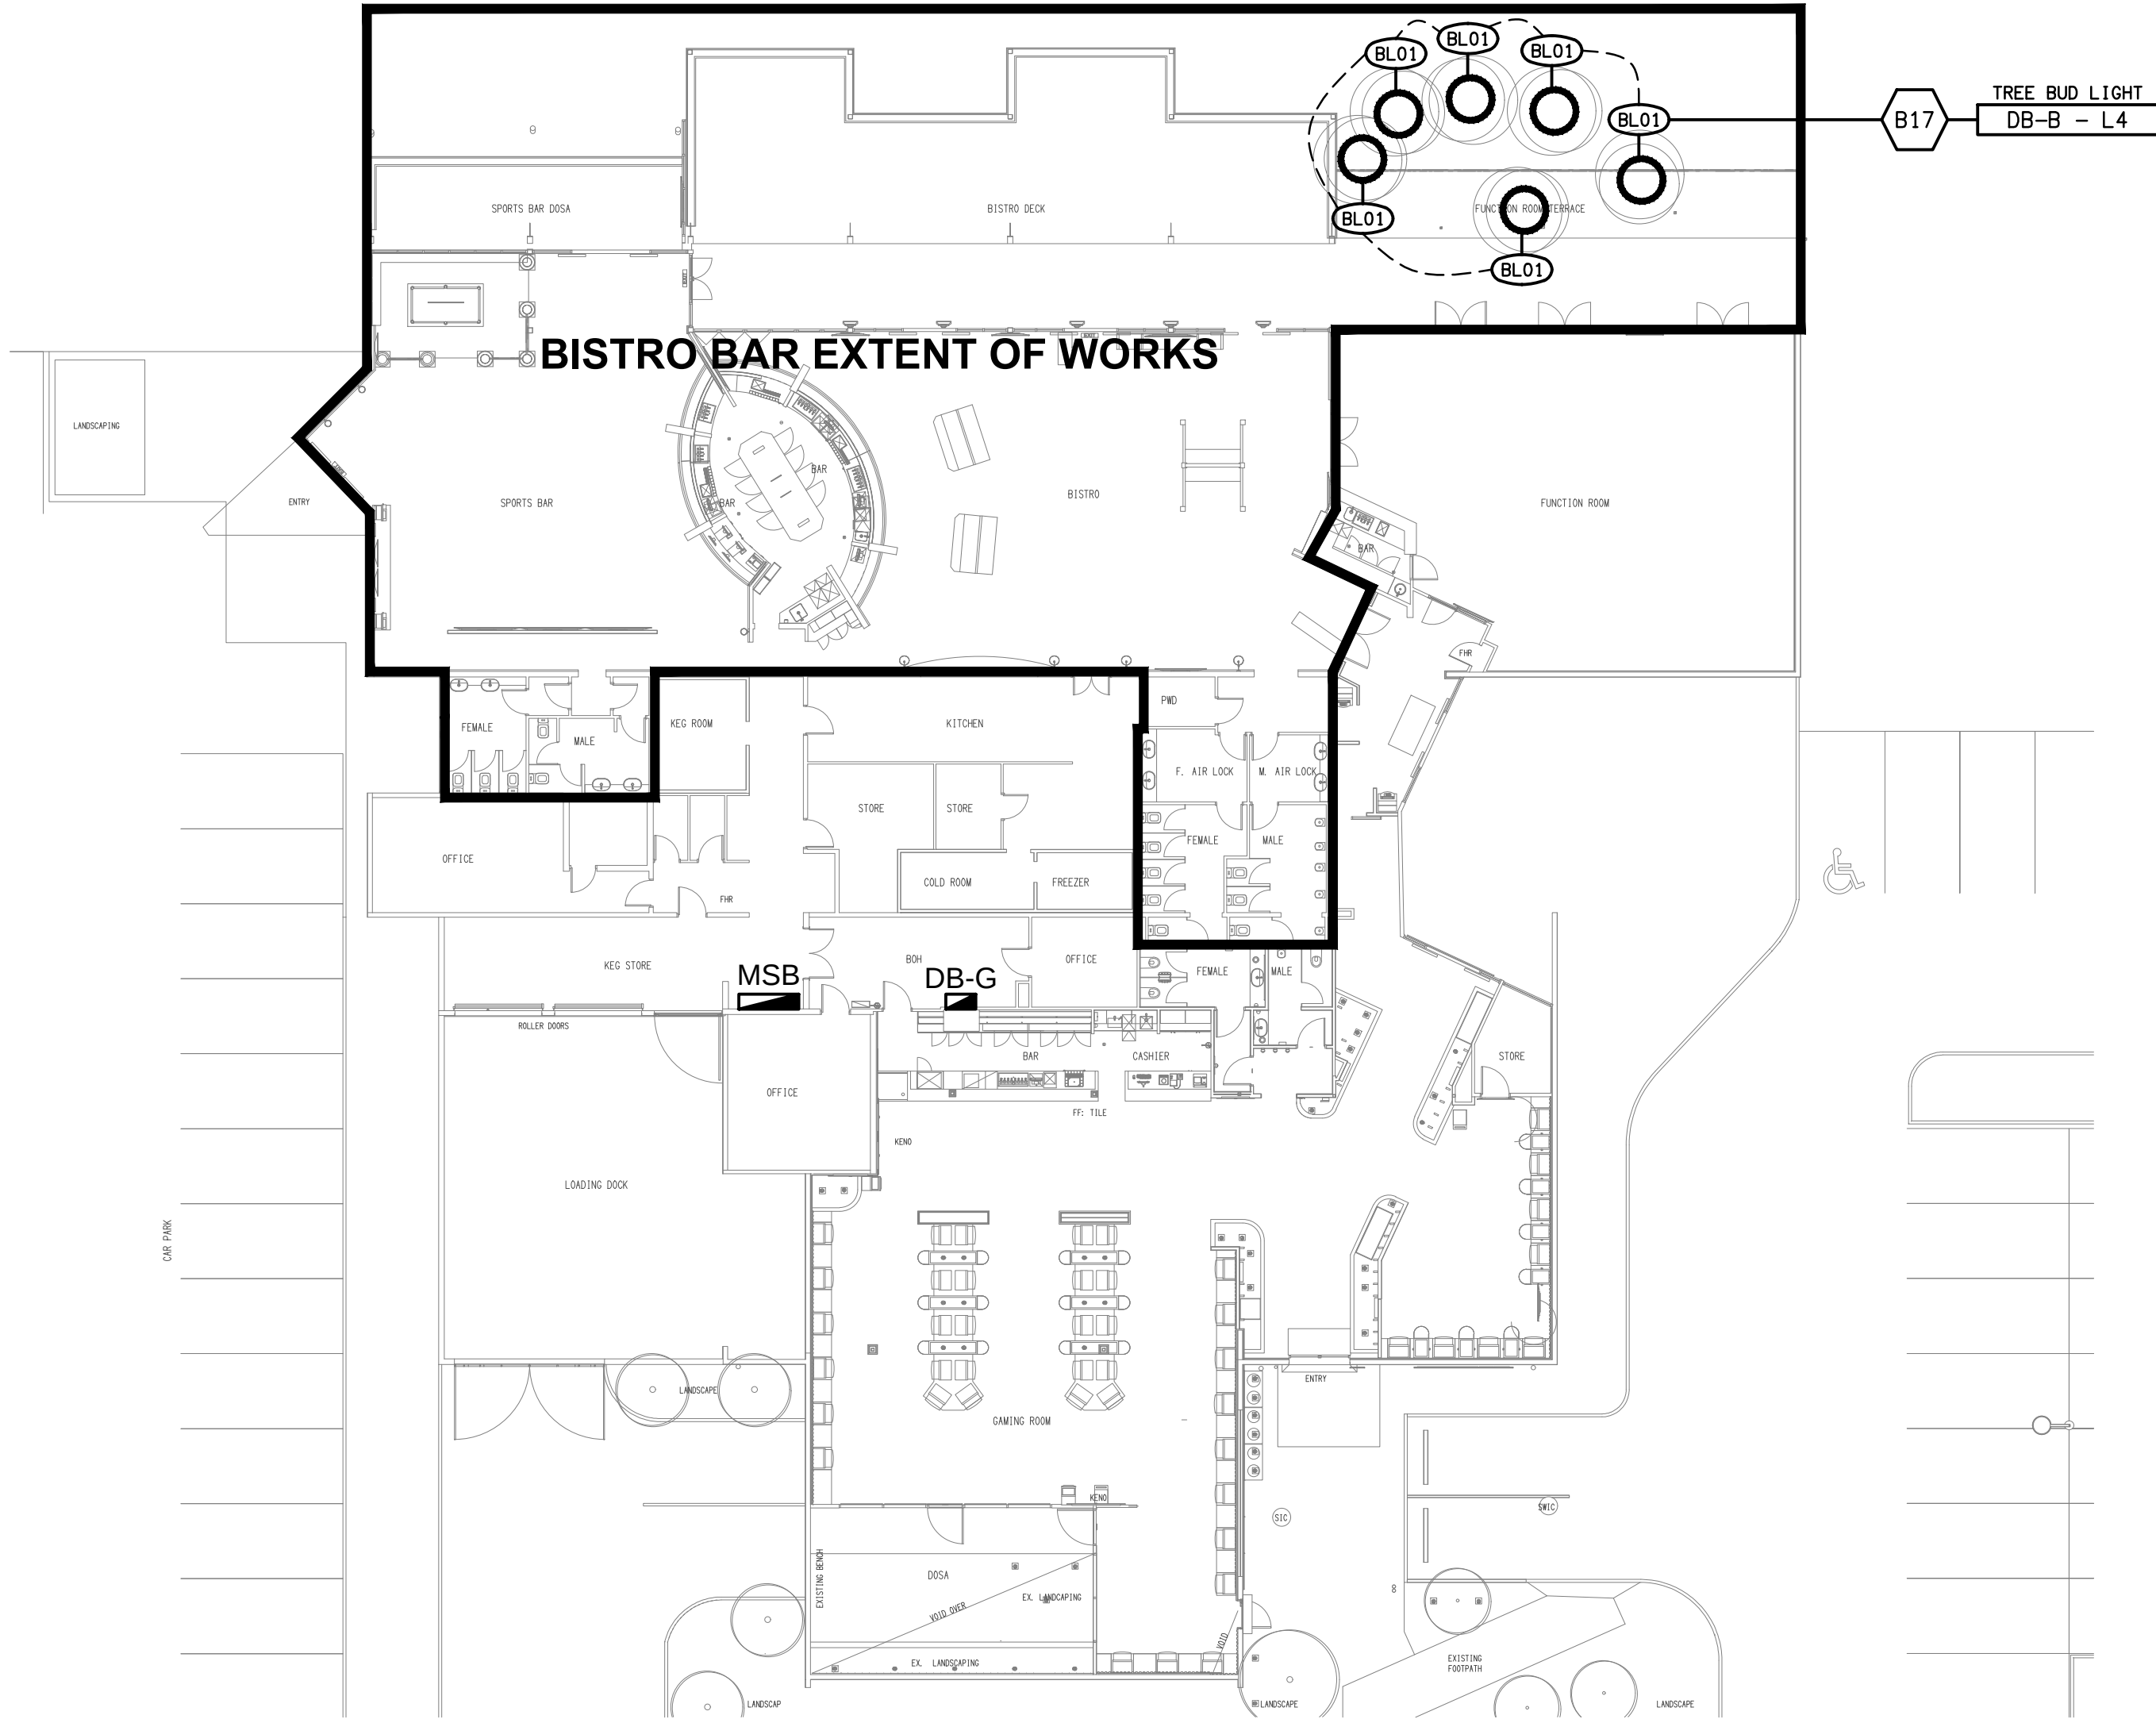

SITE PLAN
BISTRO BAR EXTENT OF WORKS
SCALE 1: 200

ELECTRICAL DESIGN GROUP BRISBANE
PTY LTD
ACN 092 710 793
TRADING AS:
ELECTRICAL DESIGN GROUP

THE COPYRIGHT OF THIS DRAWING
REMAINS THE PROPERTY OF THE
ELECTRICAL DESIGN GROUP.
USE FIGURED DIMENSIONS
IN PREFERENCE TO SCALE.
ALL DIMENSIONS TO BE
VERIFIED ONSITE.

 **ELECTRICAL DESIGN GROUP**
ELECTRICAL BUILDING SERVICES CONSULTANTS
BRISBANE GOLD COAST

P.O.Box 15, Sherwood Q.4075
Phone: (07) 3278 4375
Email: brisbane@edg.net.au
Web: www.edg.net.au

PROJECT:
DUBLIN DOCKS TAVERN, BIGGERA WATERS
BISTRO BAR

HARBOURTOWN SHOPPING CENTRE, BIGGERA WATERS

A	PRELIMINARY	28/08/2026
REV.	DESCRIPTION:	DATE:

DRAWING:
**ELECTRICAL SERVICES
LEGEND & DETAILS**

SCALE: AS SHOWN	AT A1	PROJECT NO: C3824a	DRAWING NO: E01	REVISION: A
--------------------	-------	------------------------------	---------------------------	-----------------------