

LEGEND

- MSB



EXISTING MAIN SWITCH BOARD (MSB) TO REMAIN AS IS.
- DB-B



NEW DISTRIBUTION BOARD DB-B.
- DB-G



EXISTING DISTRIBUTION BOARD DB-G TO BE MODIFIED.
- 

SWITCHBOARD / CONTROL PANEL NOT PROVIDED AS PART OF THE ELECTRICAL SUBCONTRACT.
- 

SINGLE POWER OUTLET.
- 

DOUBLE POWER OUTLET.
- 

SINGLE PHASE ISOLATOR.
- 

THREE PHASE ISOLATOR.
- 

SIGNAGE CONNECTION.
- 

LIGHTING CONTROL SWITCHPANEL, TYPE x.
- 

CIRCUIT LINE.
- 

SWITCH LINE.
- DB-x - Py

POWER CIRCUIT DESIGNATION.
DENOTES DB AND CIRCUIT.
- 

LIGHTING CONTROL CHANNEL REFERENCE.
- 

ELECTRICAL EQUIPMENT AS NOTED.
- 

REFER TO DETAIL NOTED FOR THE AREA SHOWN HATCHED.
ADDITIONAL OUTLETS & FITTINGS MAY BE SHOWN ON DETAIL.
- RD01



RD01: EXISTING RECESSED DOWNLIGHT TO BE REPLACED WITH NEW.
- RD02



RD02: EXSTING RECESSED DOWNLIGHT TO BE REPLACED WITH NEW.
- RD03



RD03: RECESSED DOWNLIGHT.
- RDE



RDE: EXISTING RECESSED DOWNLIGHT TO BE REMOVED.
- TL01



TL01: EXISTING TRACK AND TRACK LIGHT FITTING TO BE REPLACED WITH NEW.
- TL02



TL02: TRACK LIGHT TO SUPPLEMENT THE TL01 LIGHT FITTINGS.
- SLE



SLE: EXISTING SURFACE MOUNTED FITTING TO BE REMOVED.
- S1



S1: CEILING PELMET STRIP LIGHT.
- S2



S2: HAND BASIN MIRROR STRIP LIGHT.
- S3



S3: COUNTER FRONT STRIP LIGHT.
- S4



S4: ISLAND BAR SHELIVING STRIP LIGHT.
- FS01



FL01: EXTERNAL FESTOON LIGHTS.
- BL01



BL01: EXISTING TREE BUD LIGHTS TO BE REPLACED WITH NEW.
- PD01



PD01: EXISTING DECORATIVE PENDANT TO BE REPLACED WITH NEW.
- PD02



PD02: DECORATIVE PENDANT.
- PD03



PD03: DECORATIVE PENDANT.
- PD04



PD04: DECORATIVE PENDANT.
- PD05



PD05: DECORATIVE PENDANT.
- PD06




PD06: EXISTING POOL TABLE LIGHT TO BE REPLACED WITH NEW.
- WL01




WL01: EXISTING WALL LIGHT TO BE REPLACED WITH NEW.
- HRE



HRE: EXISTING HEATER TO BE RETAINED.

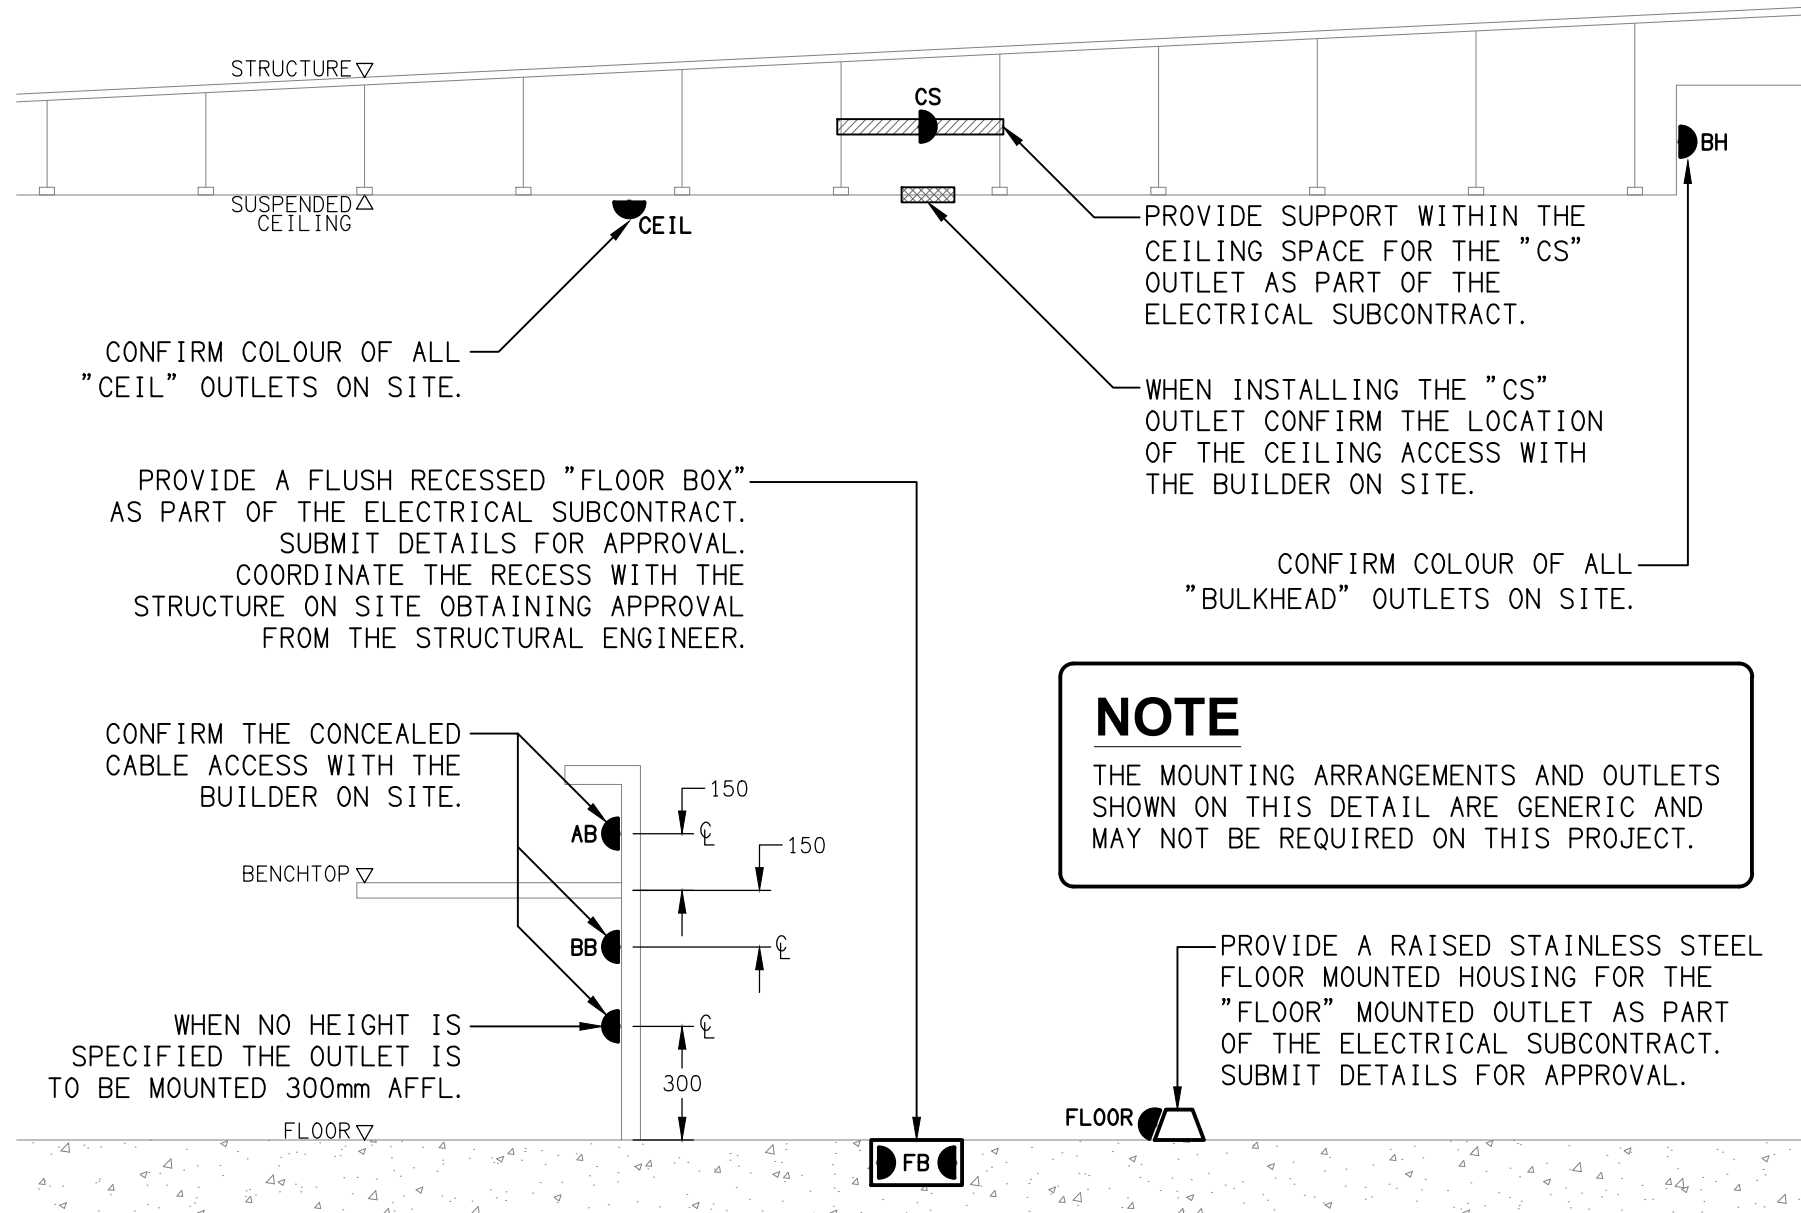

DETAIL
TYPICAL OUTLET MOUNTINGS
NOT TO SCALE

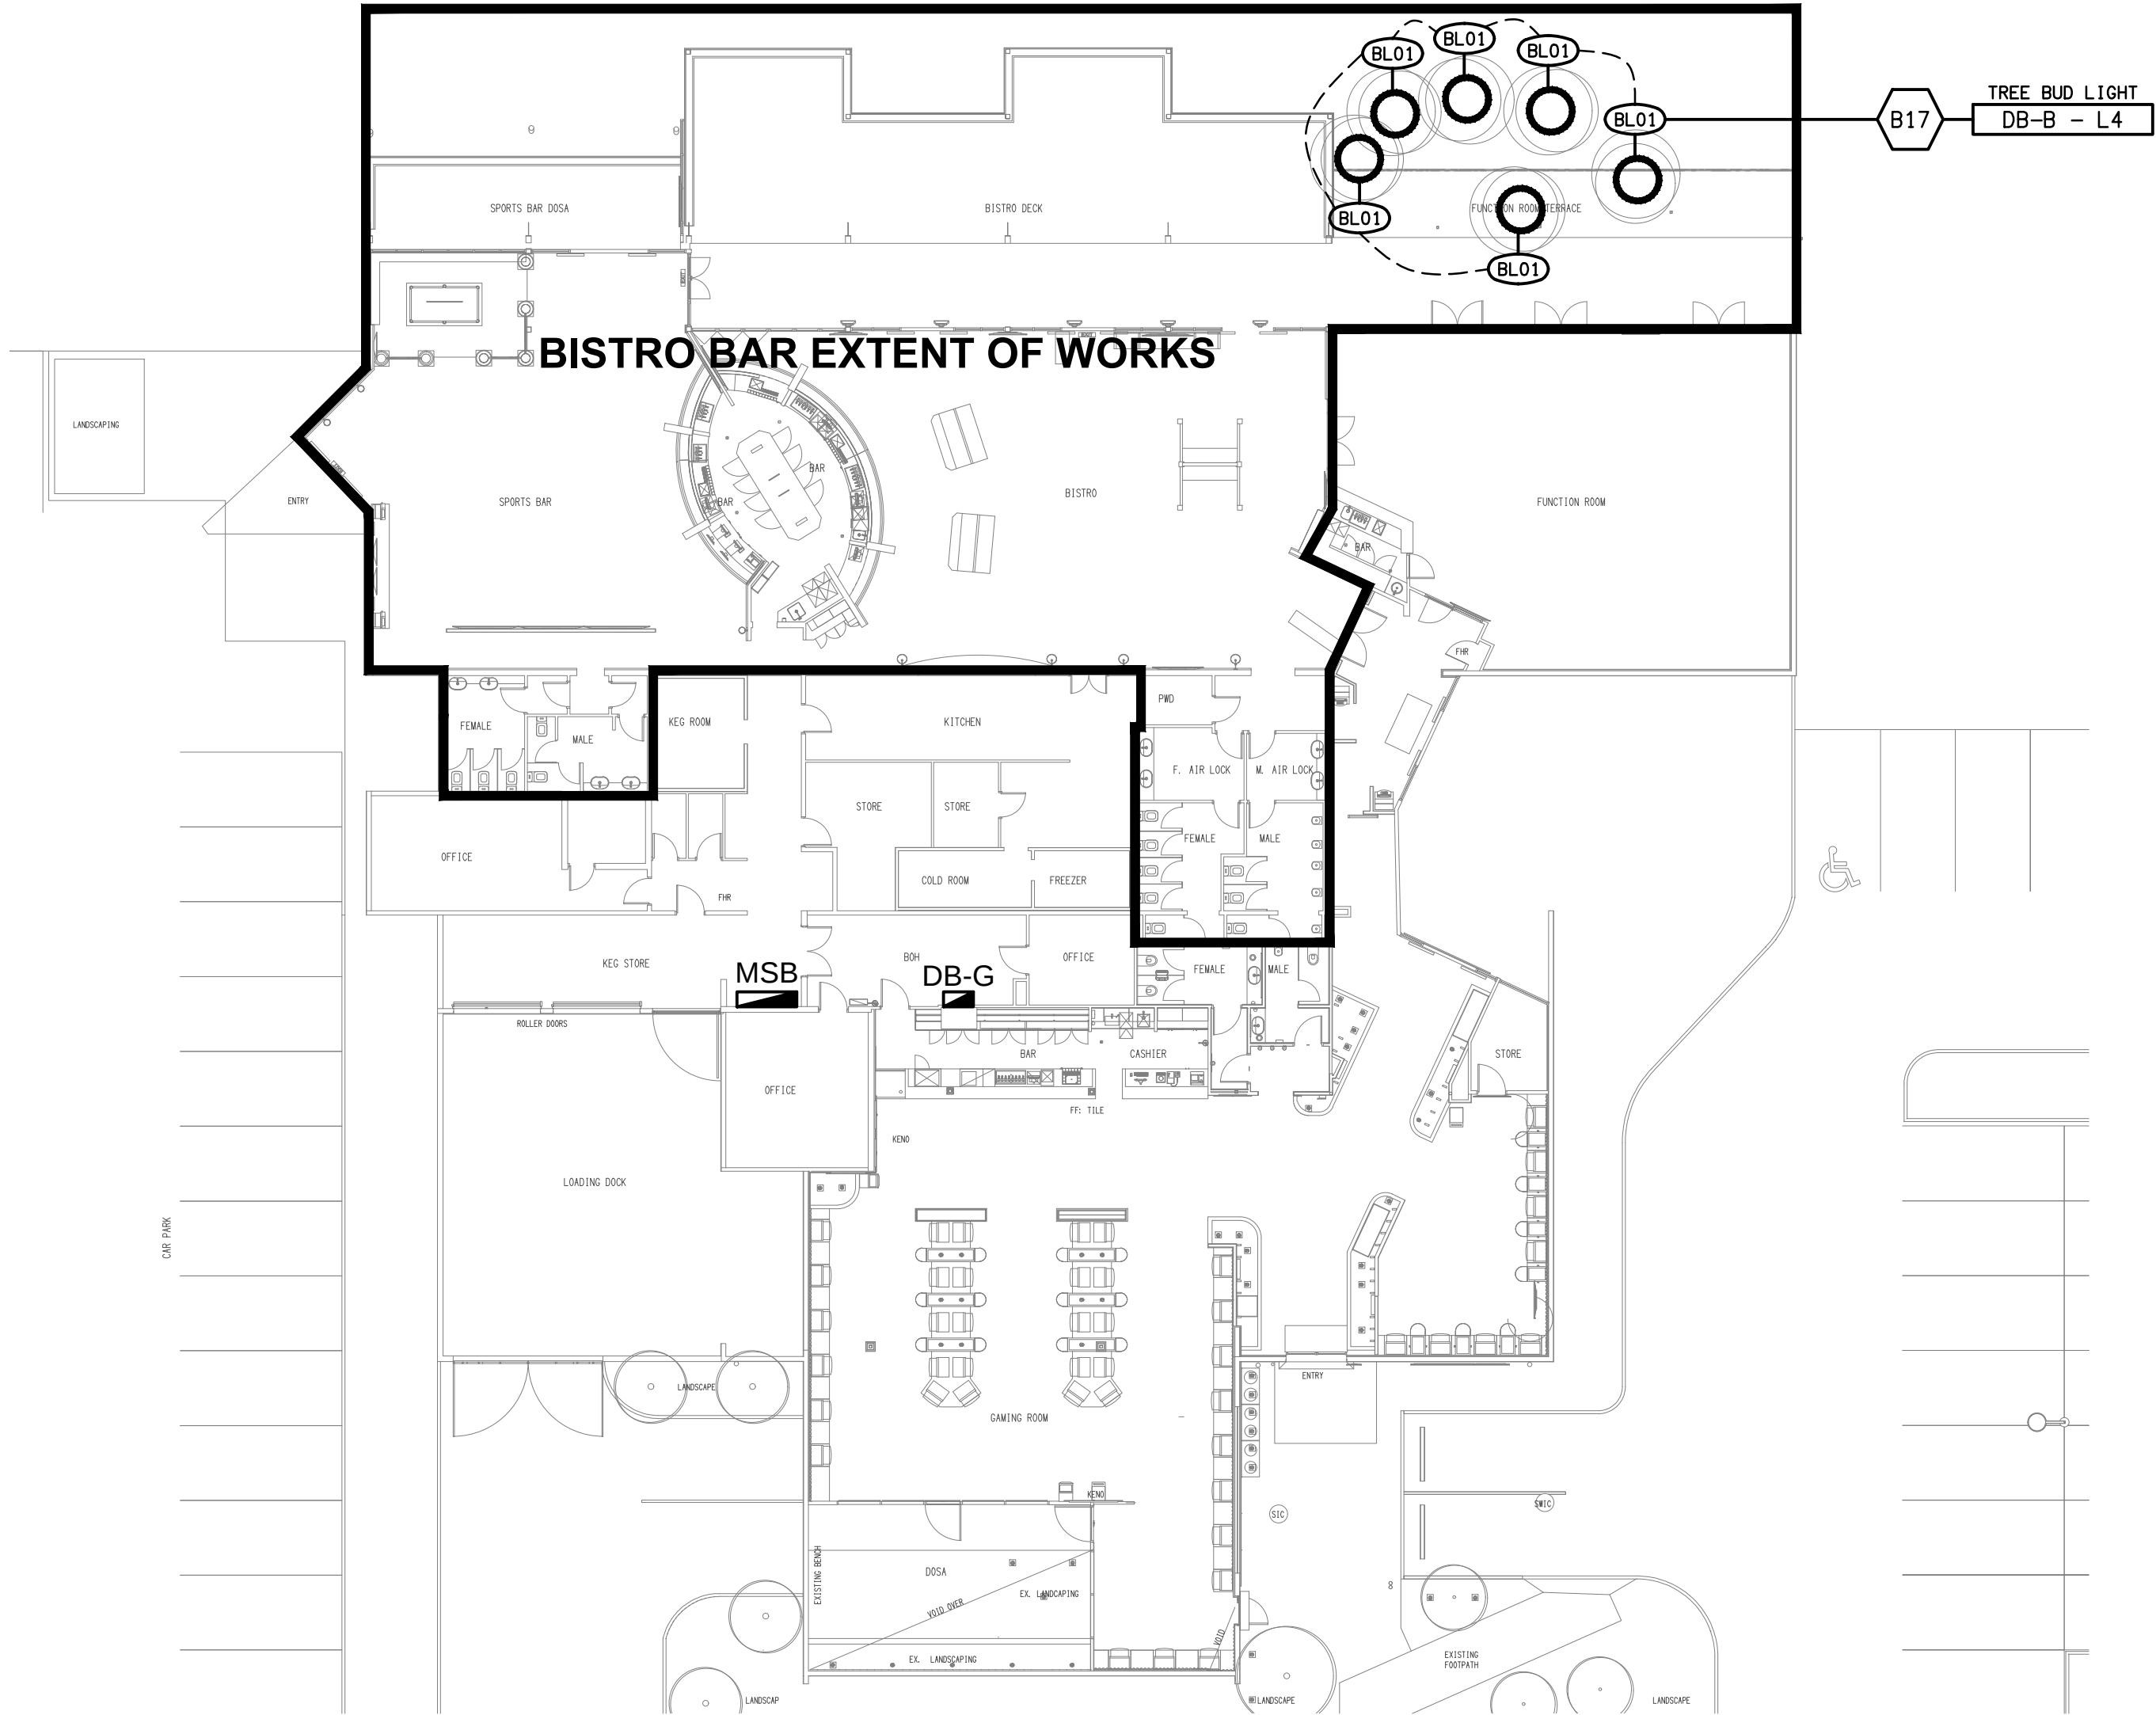

SITE PLAN
BISTRO BAR EXTENT OF WORKS
SCALE 1:200