


NOTE:
REFER TO DRAWING C3824a-E01 FOR THE
ADDITIONAL TREE BUD LIGHTING PLAN

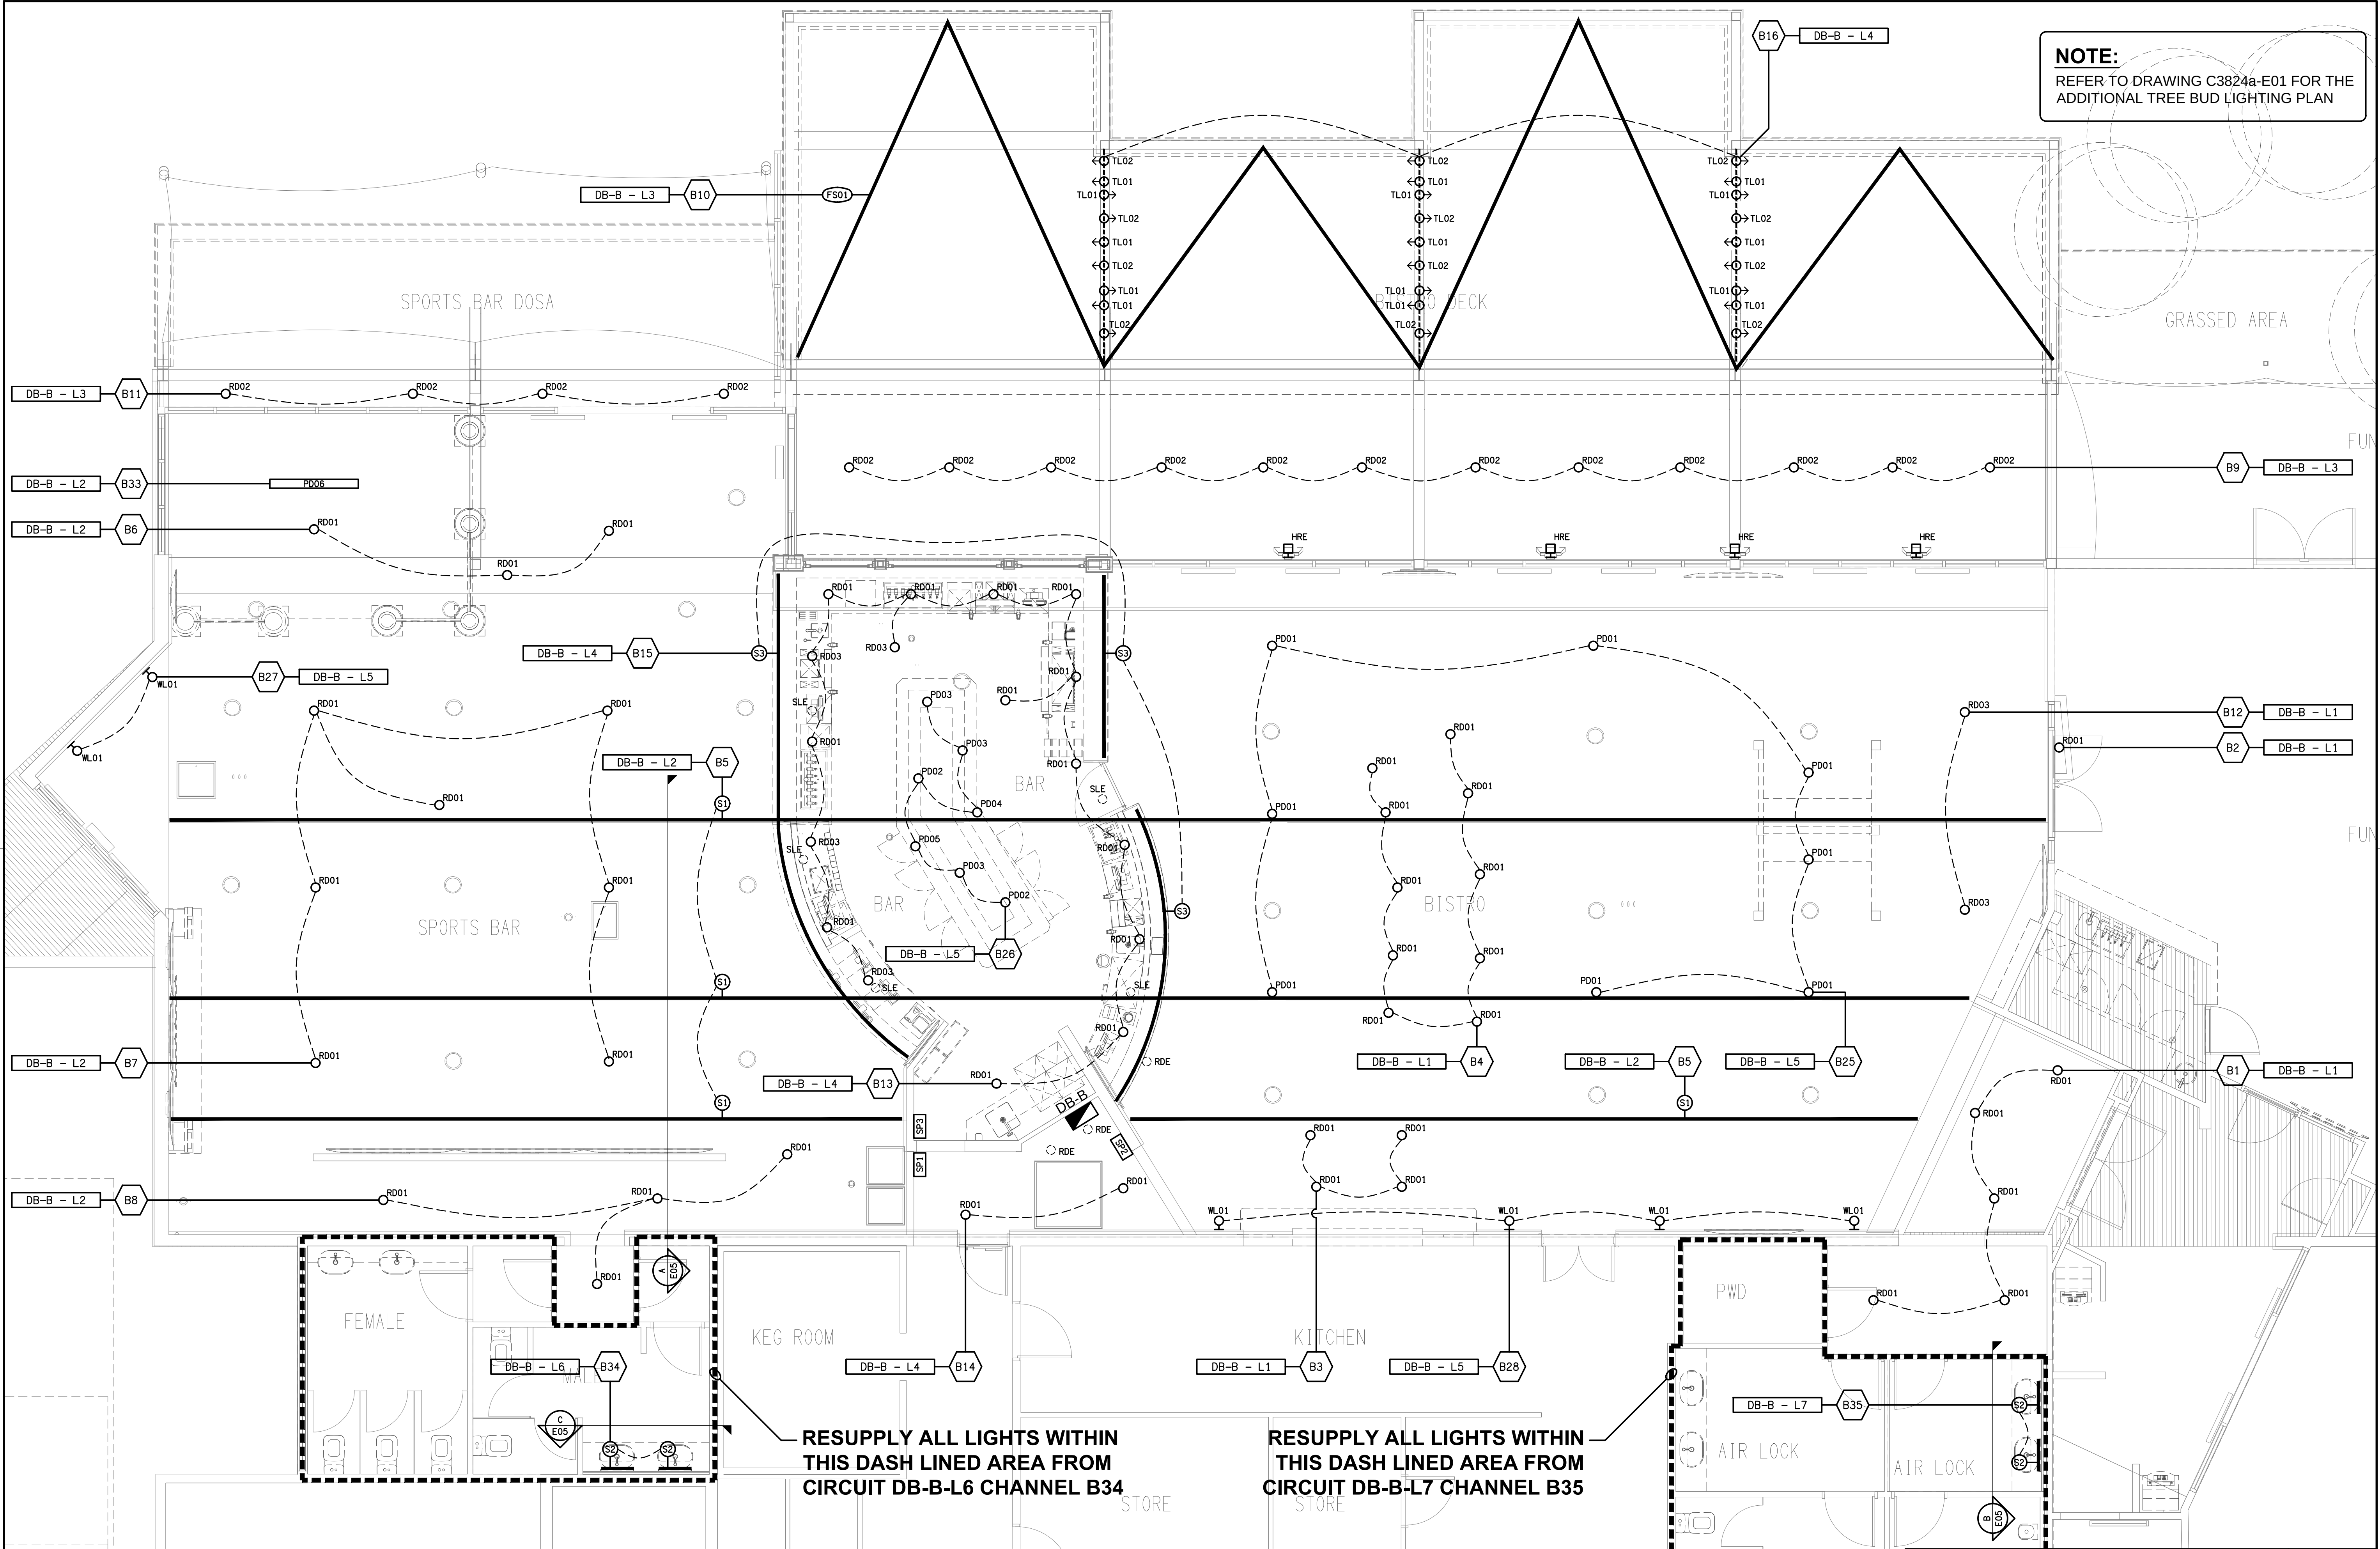

RESUPPLY ALL LIGHTS WITHIN
THIS DASH LINED AREA FROM
CIRCUIT DB-B-L6 CHANNEL B34

RESUPPLY ALL LIGHTS WITHIN
THIS DASH LINED AREA FROM
CIRCUIT DB-B-L7 CHANNEL B35

ELECTRICAL DESIGN GROUP BRISBANE
PTY LTD
ACN 092 710 793
TRADING AS:
ELECTRICAL DESIGN GROUP

THE COPYRIGHT OF THIS DRAWING
REMAINS THE PROPERTY OF THE
ELECTRICAL DESIGN GROUP.
USE FIGURED DIMENSIONS
IN PREFERENCE TO SCALE.
ALL DIMENSIONS TO BE
VERIFIED ONSITE.

ELECTRICAL DESIGN GROUP
ELECTRICAL BUILDING SERVICES CONSULTANTS
BRISBANE GOLD COAST

P.O.Box 15, Sherwood Q, 4075
Phone: (07) 3278 4375
Email: brisbane@edg.net.au
Web: www.edg.net.au

PROJECT:
DUBLIN DOCKS TAVERN, BIGGERA WATERS
BISTRO BAR

HARBOURTOWN SHOPPING CENTRE, BIGGERA WATERS

A	PRELIMINARY	28/08/2026
REV:	DESCRIPTION:	DATE:

DRAWING:
**ELECTRICAL SERVICES
REFLECTED CEILING PLAN**

SCALE:
1:50

AT A1

PROJECT NO:
C3824a

DRAWING NO:
E04

REVISION:
A