


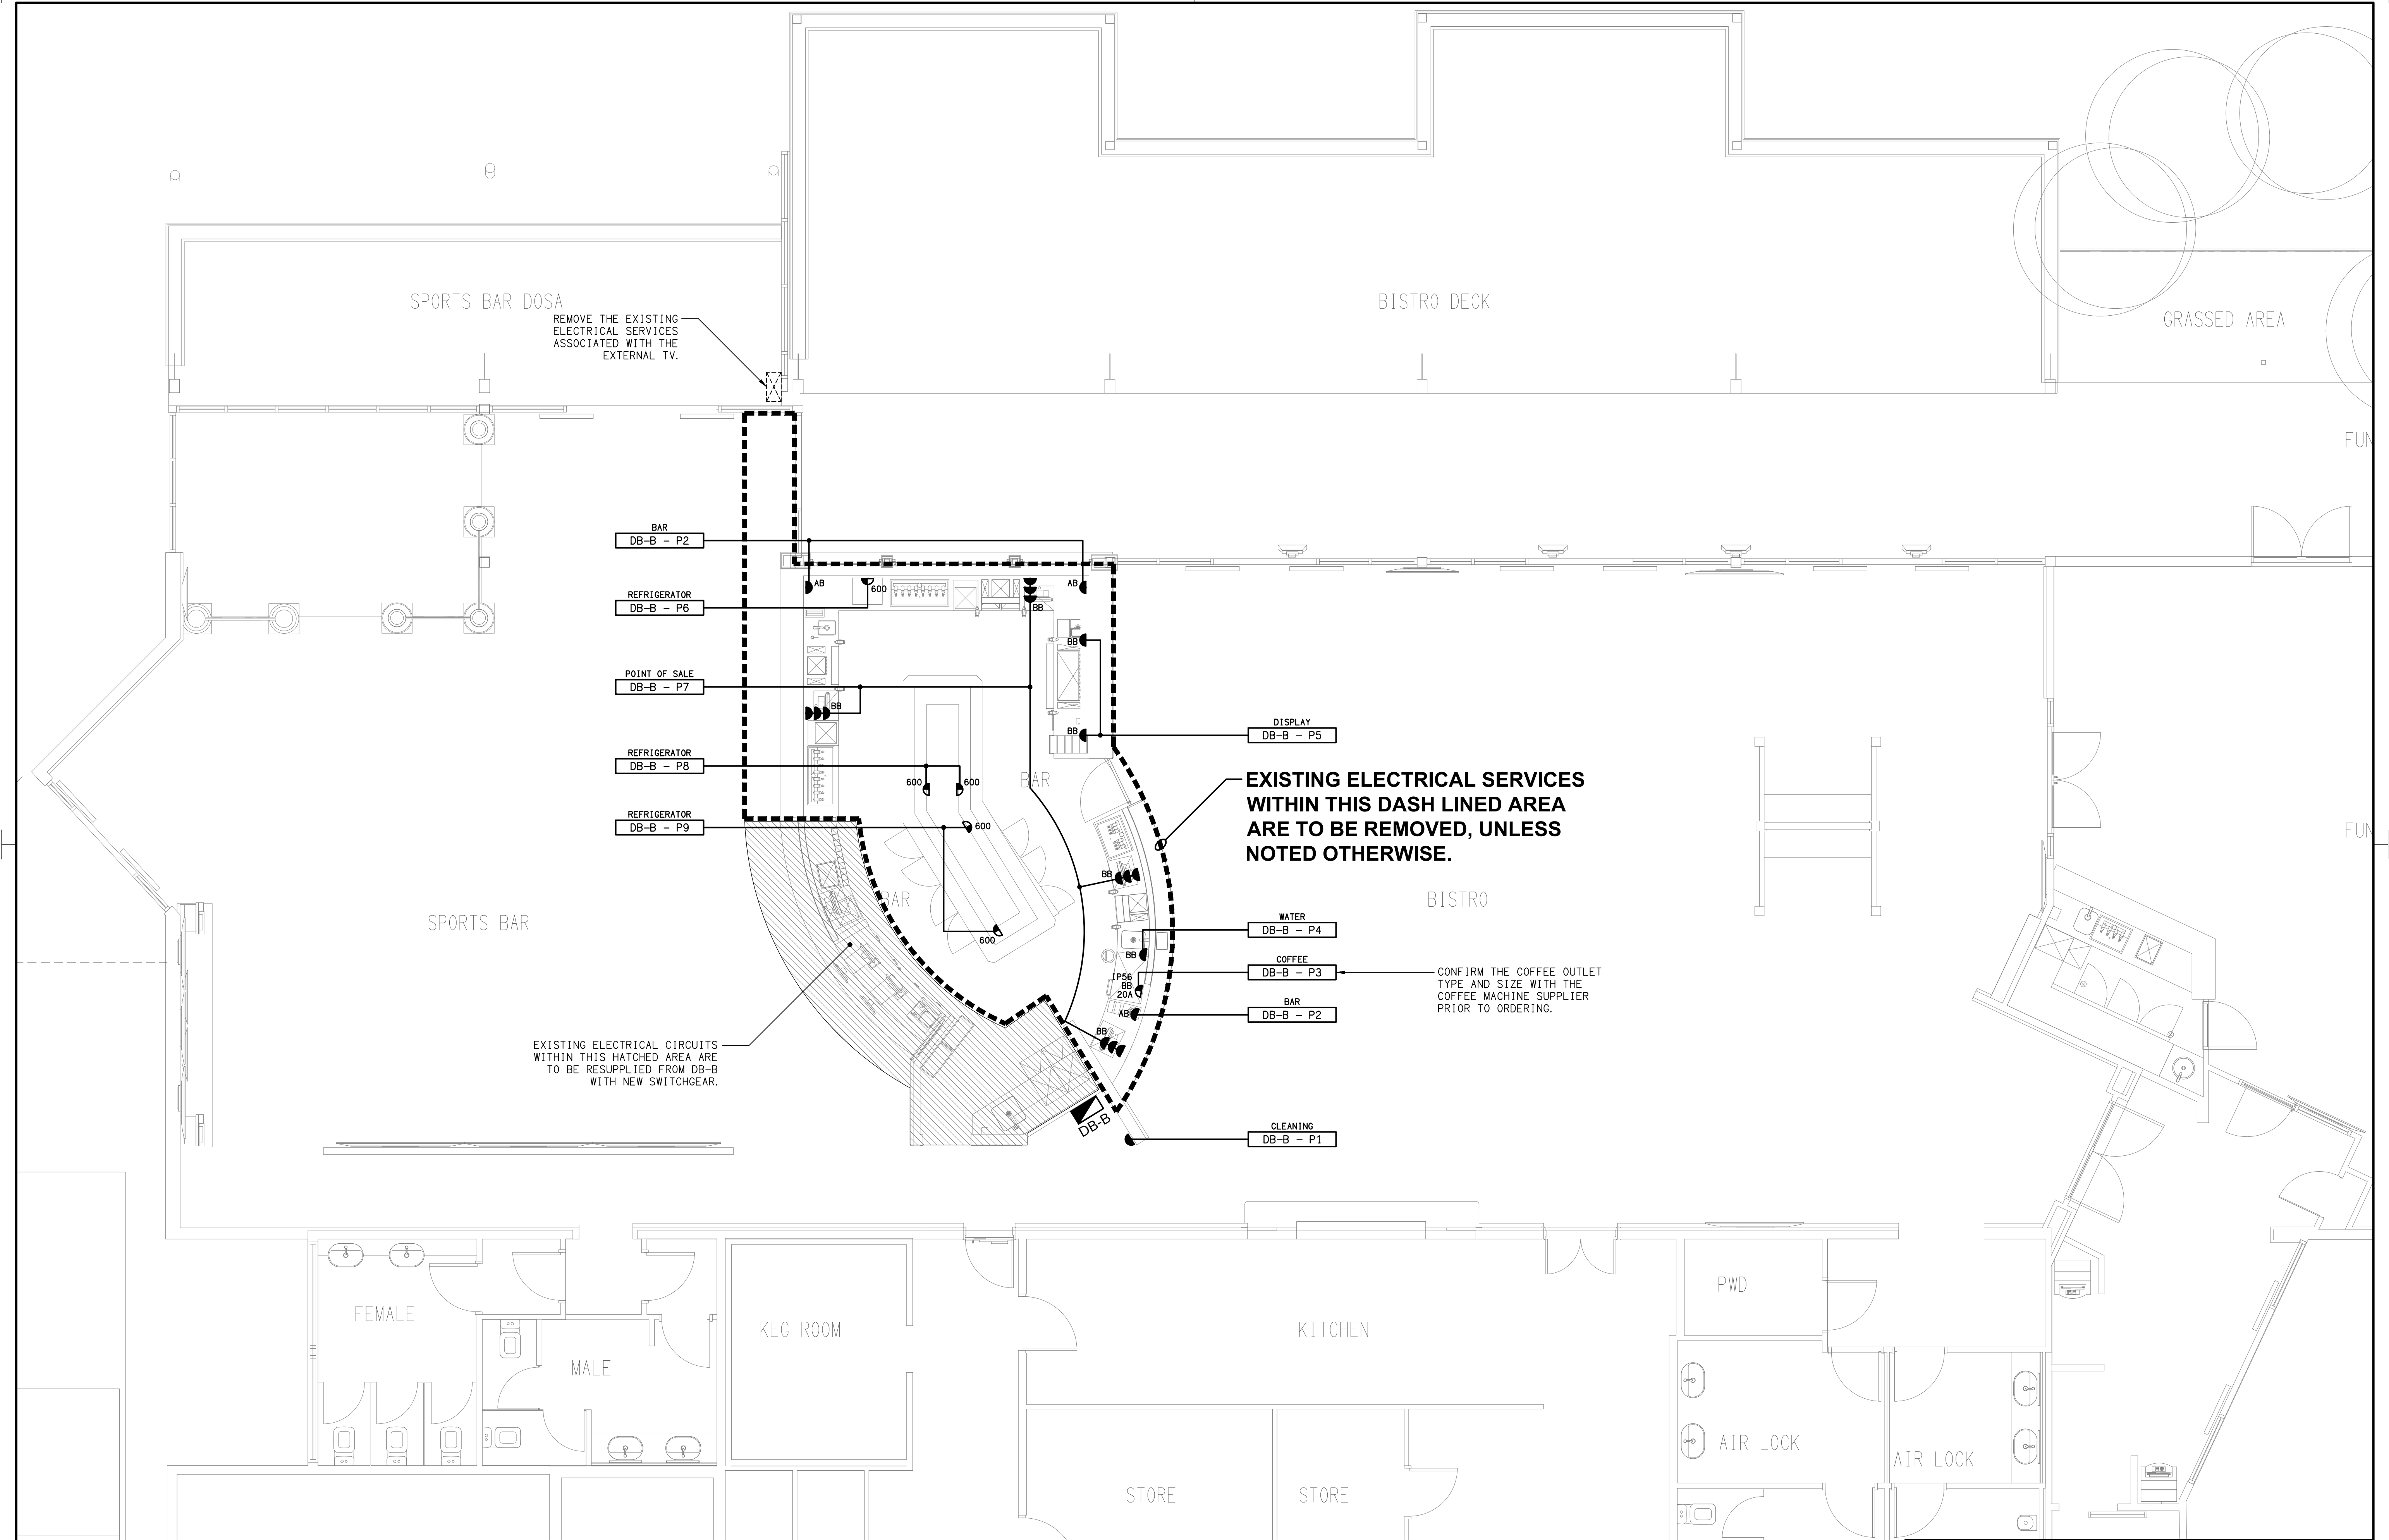

ELECTRICAL DESIGN GROUP BRISBANE PTY LTD ACN 092 710 793 TRADING AS: ELECTRICAL DESIGN GROUP		THE COPYRIGHT OF THIS DRAWING REMAINS THE PROPERTY OF THE ELECTRICAL DESIGN GROUP. USE FIGURED DIMENSIONS IN PREFERENCE TO SCALE. ALL DIMENSIONS TO BE VERIFIED ONSITE.	ELECTRICAL DESIGN GROUP ELECTRICAL BUILDING SERVICES CONSULTANTS BRISBANE GOLD COAST P.O.Box 15, Sherwood Q.4075 Phone: (07) 3278 4375 Email: brisbane@edg.net.au Web: www.edg.net.au	PROJECT: DUBLIN DOCKS TAVERN, BIGGERA WATERS BISTRO BAR HARBOURTOWN SHOPPING CENTRE, BIGGERA WATERS	<table><tr><td>A</td><td>PRELIMINARY</td><td>28/08/2026</td></tr><tr><td>REV:</td><td>DESCRIPTION:</td><td>DATE:</td></tr></table> DRAWING: ELECTRICAL SERVICES FLOOR PLAN SCALE: 1:50 AT A1 PROJECT NO: C3824a DRAWING NO: E03 REVISION: A	A	PRELIMINARY	28/08/2026	REV:	DESCRIPTION:	DATE:
A	PRELIMINARY	28/08/2026									
REV:	DESCRIPTION:	DATE:									